


HEAT TAPE RECEPT ON UNDERSIDE OF FLOOR

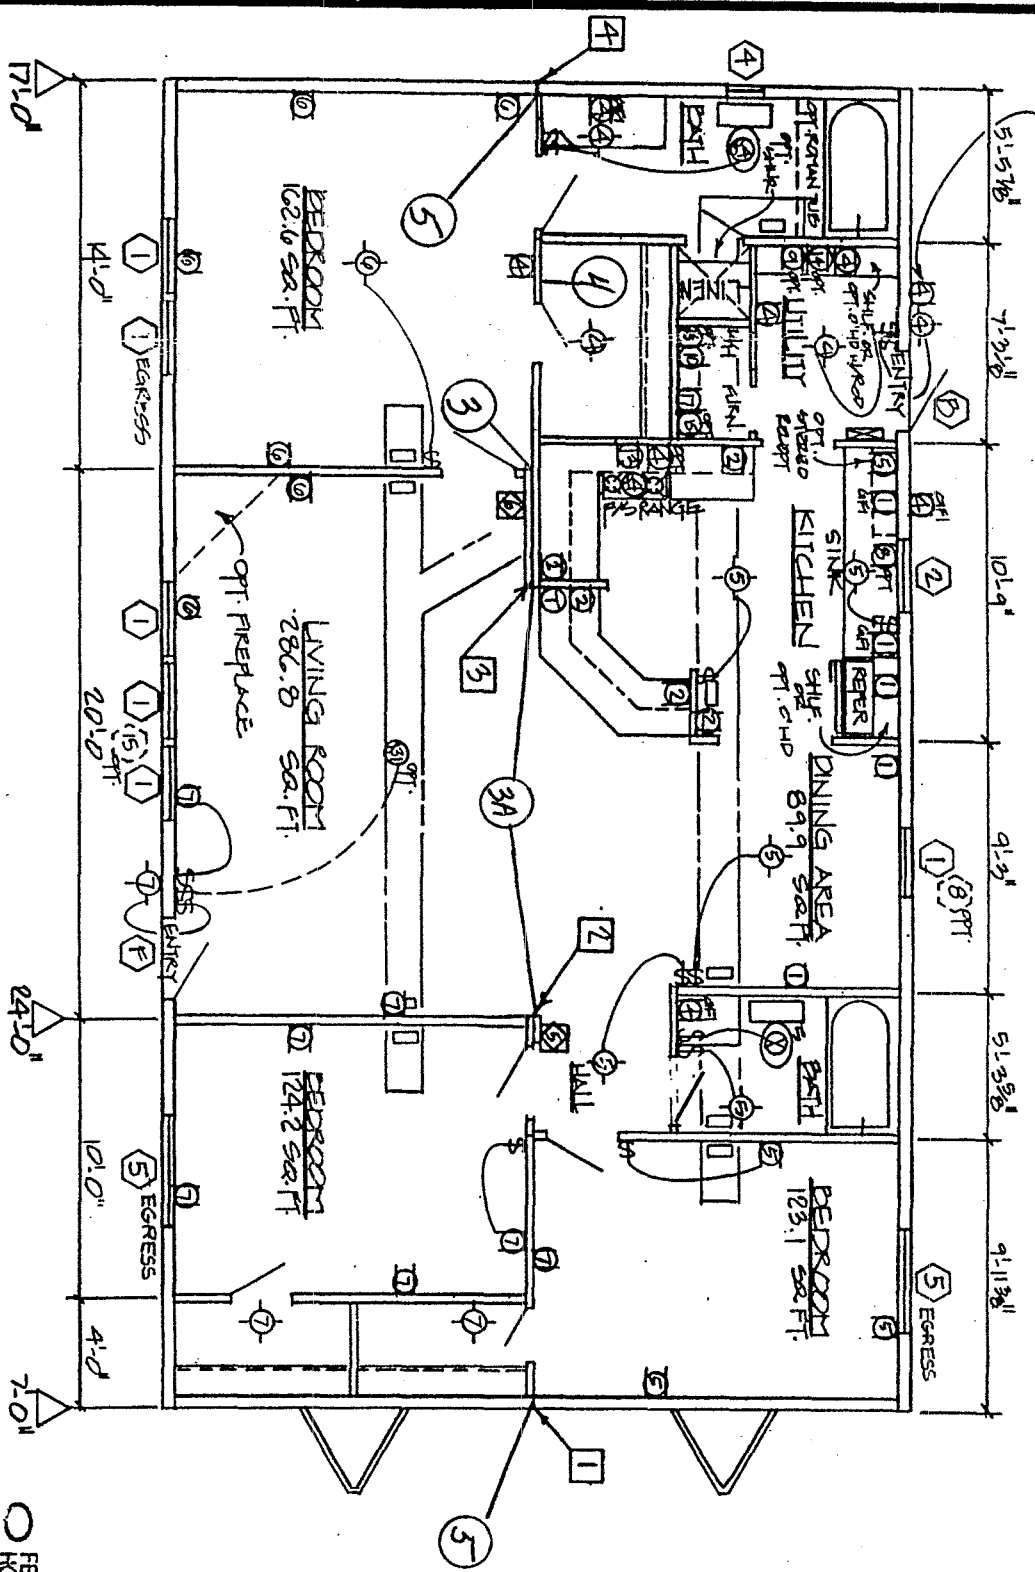

WINDOW/DOOR SCHEDULE

NO.	SIZE	DESCRIPTION	GLAZ	VENT	NO.	SIZE	DESCRIPTION	GLAZ	VENT
1	30" x 53"	V. SLIDER	9.1	5.0	F	34" x 80"	GUINSLAT	2.1	-
4	14" x 40"	V. SLIDER	2.7	1.5	B	32" x 80"	GUINSLAT	2.1	-
5	16" x 53"	V. SLIDER	15.5	7.9					
15	84" x 68"	PICTURE	91.0	16.0					

LEGEND:

SEE ELECT. CIR. SPECS.

SWITCH

LIGHT FIXTURE

THERMOSTAT

EXHAUST & CEIL. FAN

SMOKE DETECTOR

DOOR BELL TRANSFORMER

MAIN DISTRIBUTION PANEL

SUPPLY AIR GRILL/REG

4 x 10 TYP

AIR SUPPLY

CEILING REGISTER

SHEARWALL

SUPPORT POST

RETURN AIR GRILLE

RADCO
FEDERAL MANUFACTURED
HOUSING & CONSTRUCTION
& SAFETY STANDARDS
OCT 8 0 1997
4
APPROVED

MIN.	20.
PER	LOADS
(LBS)	
3900	1 A
6900	2 B
7800	3 A
4800	4 B

SALES LINE: 1314x41

DRAWN BY: DA

DATE: 10/27/95

SCALE: 3/16" = 1'-0"