



FRONT ELEVATION

SCALE: 1/8" = 1'-0"

x Jerry Garren

x Cindy Garren



RIGHT END ELEVATION

SCALE: 1/8" = 1'-0"



REAR ELEVATION

SCALE: 1/8" = 1'-0"



LEFT END ELEVATION

SCALE: 1/8" = 1'-0"

TRINITY MOUNTAIN HOMES dba
TRINITY CUSTOM HOMES
15230 HIGHWAY 515 S., ELLIJAY, GA 30540
Phone (706) 313-1139

SQUARE FOOTAGE

MAIN LEVEL 1138
PORCH 412

TOTAL FINISHED 1550


CUSTOM HOME DESIGN FOR:
JERRY AND CINDY GARREN
DRAWING NO. #51362-1 DATE: 12/20/02 REV. 1/23

SHEET 1 OF 4
ELEVATIONS

WINDOW SCHEDULE					
ITEM	QTY	SIZE	TYPE	REMARKS	ROUGH OPENING
(A)	4	3050	SINGLE HUNG		36" X 40"
(B)	1	3050-3	SINGLE HUNG	TWIN	35 1/2" X 40"
(C)	1	2030	SINGLE HUNG		24" X 36"
(D)	1	2026	SINGLE HUNG		24" X 30"
(E)	2	2444	SINGLE HUNG		28" X 52"

* DORMER WINDOWS

DOOR SCHEDULE					
ITEM	QTY	SIZE	TYPE	REMARKS	ROUGH OPENING
(1)	2	3'-0" X 6'-8"	1-LITE	EXTERIOR	38" X 82"
(2)	1	6'-0" X 6'-8"	FRENCH	EXTERIOR	74" X 82"
(3)	1	2'-8" X 6'-8"	6 PANEL	INTERIOR	34" X 82"
(4)	5	2'-4" X 6'-8"	6 PANEL	INTERIOR	32" X 82"
(5)	1	2'-4" X 6'-8"	6 PANEL	INTERIOR	30" X 82"
(6)	6	2'-0" X 6'-8"	6 PANEL	INTERIOR	24" X 82"

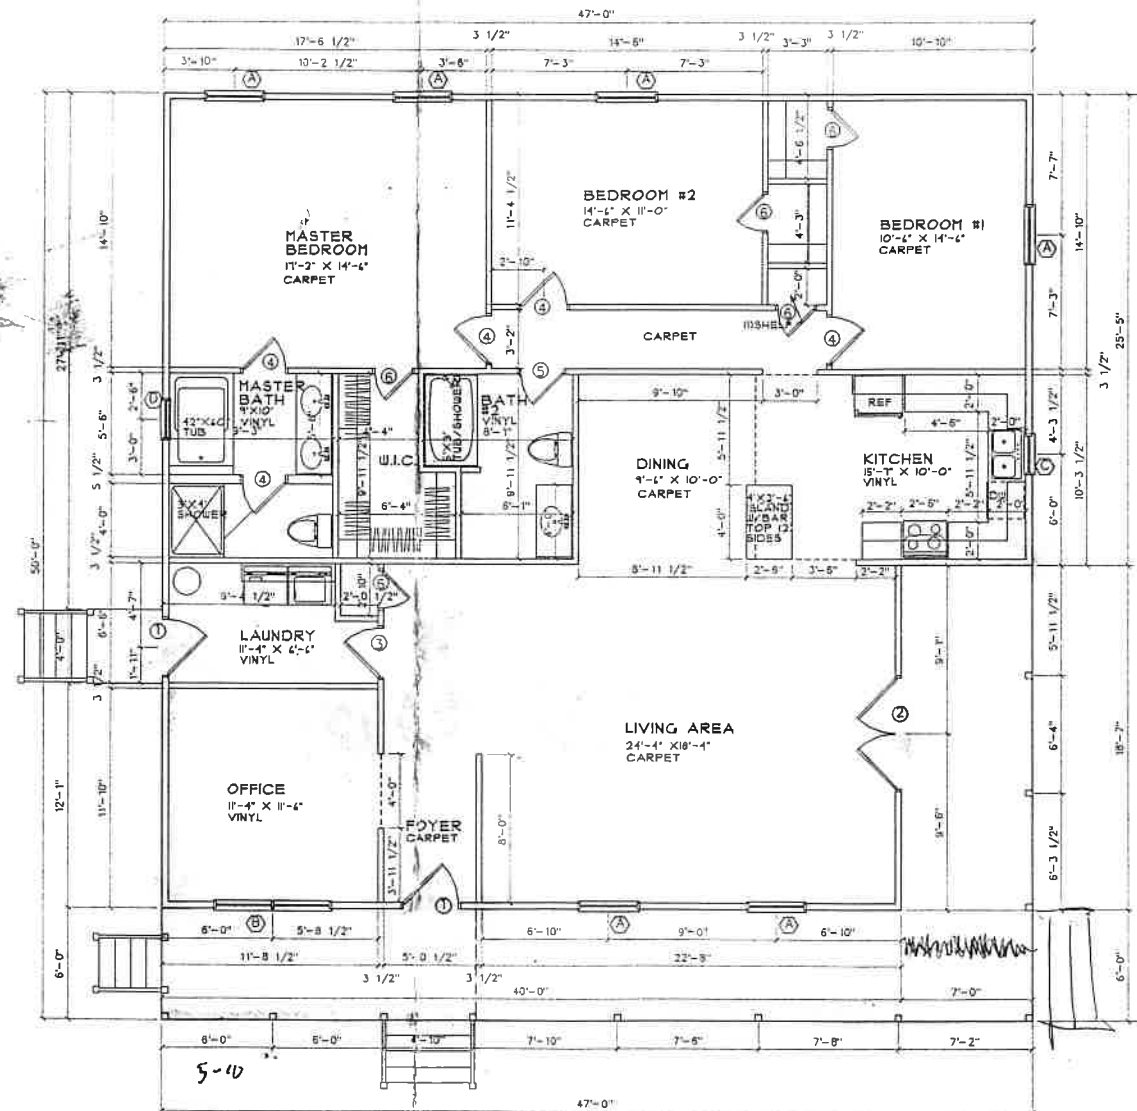

FLOOR PLAN
SCALE: 1/8" = 1'-0"

TRINITY MOUNTAIN HOMES dba
TRINITY CUSTOM HOMES
15230 HIGHWAY 515 S., ELLIJAY, GA 30540
Phone (706) 313-1139

SQUARE FOOTAGE

MAIN LEVEL 1138


PORCH 42

TOTAL FINISHED 1180

CUSTOM HOME DESIGN FOR:
JERRY AND CINDY GARREN
DRAWING NO. #S1362-1 DATE: 12/20/02 REV. 1/23

SHEET 2 OF 4
FLOOR PLAN

Cindy Garren *[Signature]*

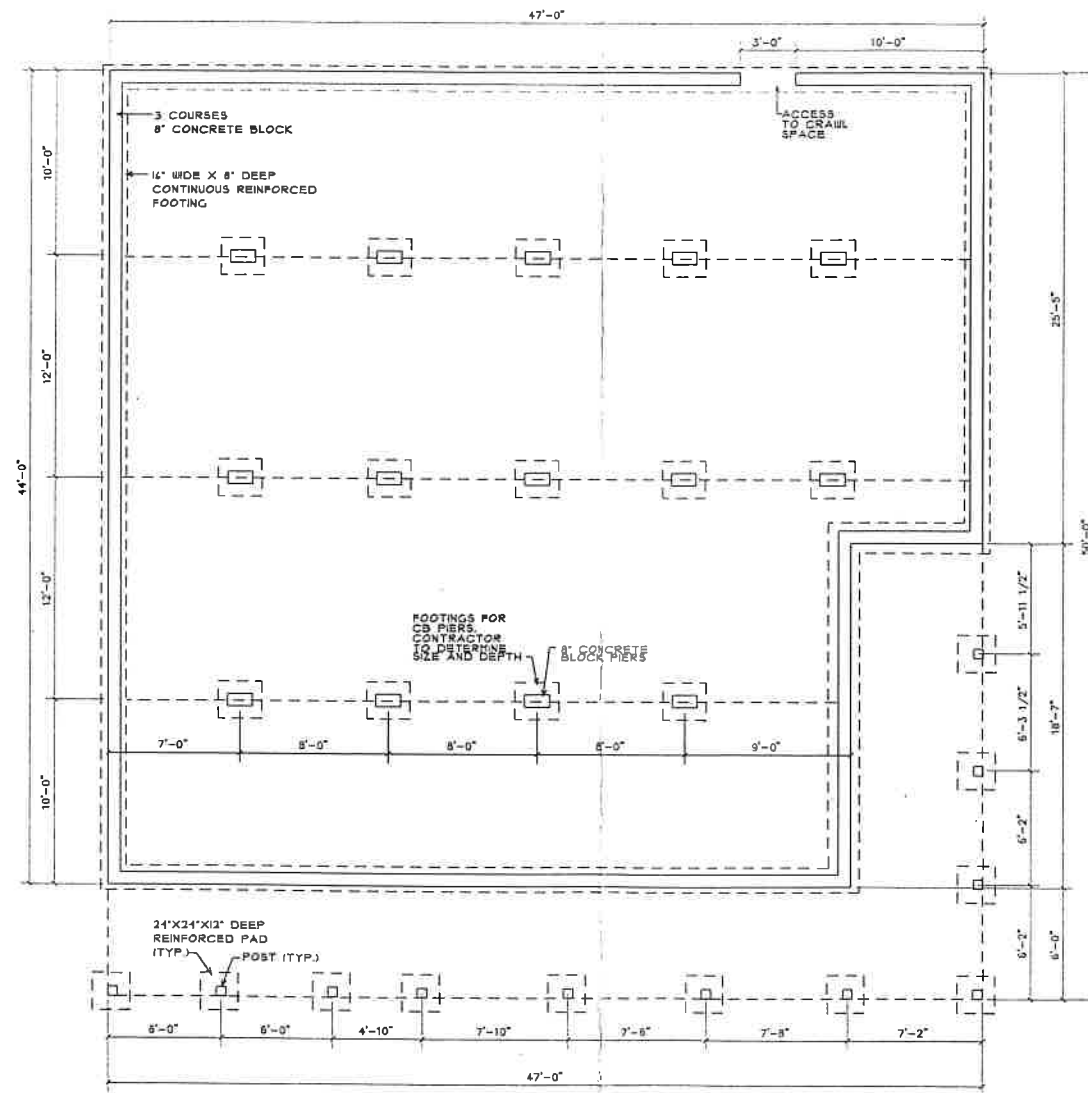

FOUNDATION PLAN

SCALE: 1/8" = 1'-0"

TRINITY MOUNTAIN HOMES dba
TRINITY CUSTOM HOMES
15230 HIGHWAY 515 S., ELLIJAY, GA 30540
Phone (706) 313-7139

SQUARE FOOTAGE

MAIN LEVEL 1338
PORCH 412

TOTAL FINISHED 1750


CUSTOM HOME DESIGN FOR:
JERRY AND CINDY GARREN

DRAWING NO. #S1362-1 DATE: 12/20/02 REV. 1/23

SHEET 3 OF 4
FOUNDATION

Handwritten signature: Cindy Garren

ELECTRICAL SCHEDULE	
SYMBOL	DESCRIPTION
	CEILING FAN W/LIGHT
	FLOOD LIGHT
	TELEPHONE
	FLUORESCENT LIGHT
	LIGHT FIXTURE (CEILING)
	LIGHT FIXTURE (RECESSED)
	LIGHT FIXTURE (RECESSED WATER PROOF)
	LIGHT FIXTURE (WALL)
	WALL OUTLET
	WATER PROOF WALL OUTLET
	GROUND-FAULT CIRCUIT-INTERRUPTER
	VENT FAN W/LIGHT
	3-WAY SWITCH
	SWITCH
	220 OUTLET
	EXHAUST
	CABLE
	HOSE BIB
	SMOKE DETECTOR

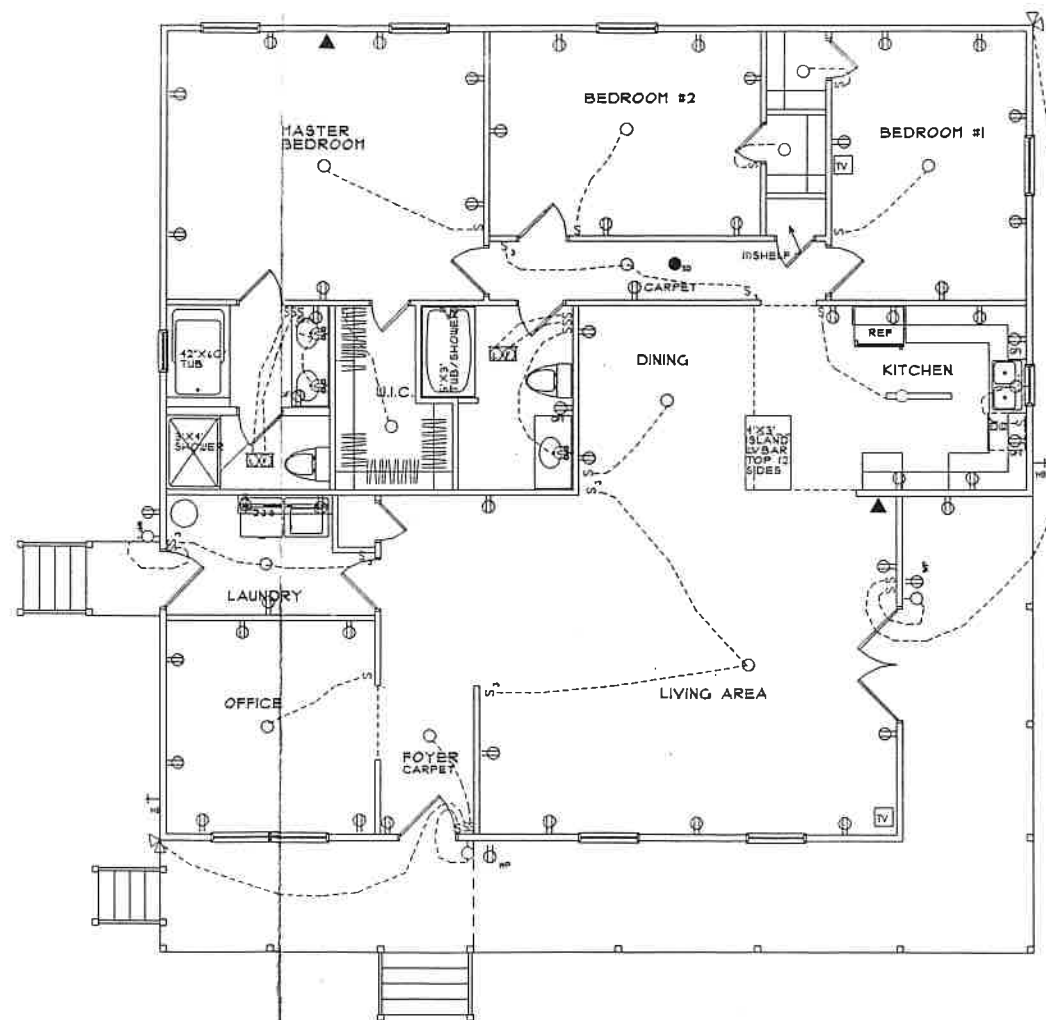

ELECTRICAL PLAN
SCALE: 1/8" = 1'-0"

TRINITY MOUNTAIN HOMES dba
TRINITY CUSTOM HOMES
15230 HIGHWAY 515 S., ELLIJAY, GA 30540
Phone (706) 313-1139

SQUARE FOOTAGE
MAIN LEVEL 1938
PORCH 412
TOTAL FINISHED 1938

CUSTOM HOME DESIGN FOR:
JERRY AND CINDY GARREN
DRAWING NO. #51342-1 DATE: 12/20/02 REV. 1/23

Cindy Garren