

GENERAL PLAN NOTES

These working drawings have been prepared by VirtuActive, LLC to meet average building conditions and were designed under standard interpretation of the 2009 International Residential Code (IRC 2009) and the amendments adopted by the City of Omaha, NE. Because codes and requirements can change and may vary from jurisdiction to jurisdiction, VirtuActive, LLC cannot warrant compliance with any specific codes or regulations. Therefore, each individual contractor, sub-contractor, and supplier on the jobsite should consult their local building official to determine the appropriateness between the plan and actual jobsite conditions and applications.

CONCRETE and FOUNDATIONS:

Footing design assumes 1500 PSF allowable bearing pressure. Foundation wall designs assume 30 PSF equivalent hydrostatic pressure. Concrete contractor to verify soil conditions prior to concrete placement.

Re-enforcing footing as follows:

- Spread footings - as noted on plan
- 20"x10" continuous footing (3) #4's cont.
- 16"x8" continuous footing (2) #4's cont.
- Deck piers - 18"x42" deep - below grade (no rebar required)

Provide footing dowels to match vertical wall reinforcing.
Reinforcing bars shall be Grade 60 or better.
Concrete contractor to provide ground rebar in footing for electrical contractor.
All concrete shall be min 3000 PSI (28 day comp strength).
All footings shall be a min of 42" bellow finished grade or deeper.
Anchor bolts must be at least 5/8" in diameter and must extend at least 7" into concrete.
There must be at least 2 anchor bolts per plate section on walls longer that 24".
Anchor bolts must be spaced no more than 6' on center.
One anchor bolt must be located not more than 12" from each end of the plate section

Contractors, sub-contractors, and suppliers shall be aware of and responsible for, but not limited to, the following:

- Contractors, sub-contractors, and suppliers shall verify all conditions and dimensions prior to construction and be solely responsible for any changes necessary as a result of conditional or dimensional differences.
- Contractors, sub-contractors, and suppliers shall verify all dimensions and elevations against the plan and actual site conditions.
- Calculated dimensions take precedence over scaled dimensions.
- All dimensions are from framing edge, unless otherwise noted.

STRUCTURAL and FRAMING:


All structural members are for bidding purposes only. All structural member sizes shall be verified by the contractor, sub-contractor, and/or supplier.
All additional structural members required for specific framing techniques shall be sized by the contractor, sub-contractor, and/or supplier.
All steel pipe columns shall be 3.5", unless otherwise noted.
Ceiling joists and roof rafters to be roof truss construction. Sizing, spans, reinforcement locations, and depth to be provided by truss manufacturer.
Provide bridging as required by code.
All perimeter headers over openings to be (2) 2x12, unless otherwise noted.
Double floor joists under all parallel non-load bearing walls.
Provide double cripple studs under all LVL headers.
Provide let-in wind bracing as required.
No penetrations through any structural member (such as pipes, conduits, ductwork, etc.) shall be made.

I hereby certify this structure complies with the energy requirements of the 2006 IRC. Compliance shall be made in accordance with:


- ☐ IRC - Chapter 11
- ☐ REScheck - (signed compliance certificates required)
- ☐ IECC - International Energy Conservation Code

Signature _____


SHEET	CONTENTS
1	TITLE SHEET
2	EXTERIOR ELEVATIONS
3	EXTERIOR ELEVATIONS
4	PERSPECTIVE VIEWS
5	FOUNDATION PLAN
6	MAIN LEVEL FLOOR PLAN
7	UPPER LEVEL FLOOR PLAN
8	ROOF PLAN/ DETAILS
9	MAIN FLOOR ELECTRICAL PLAN

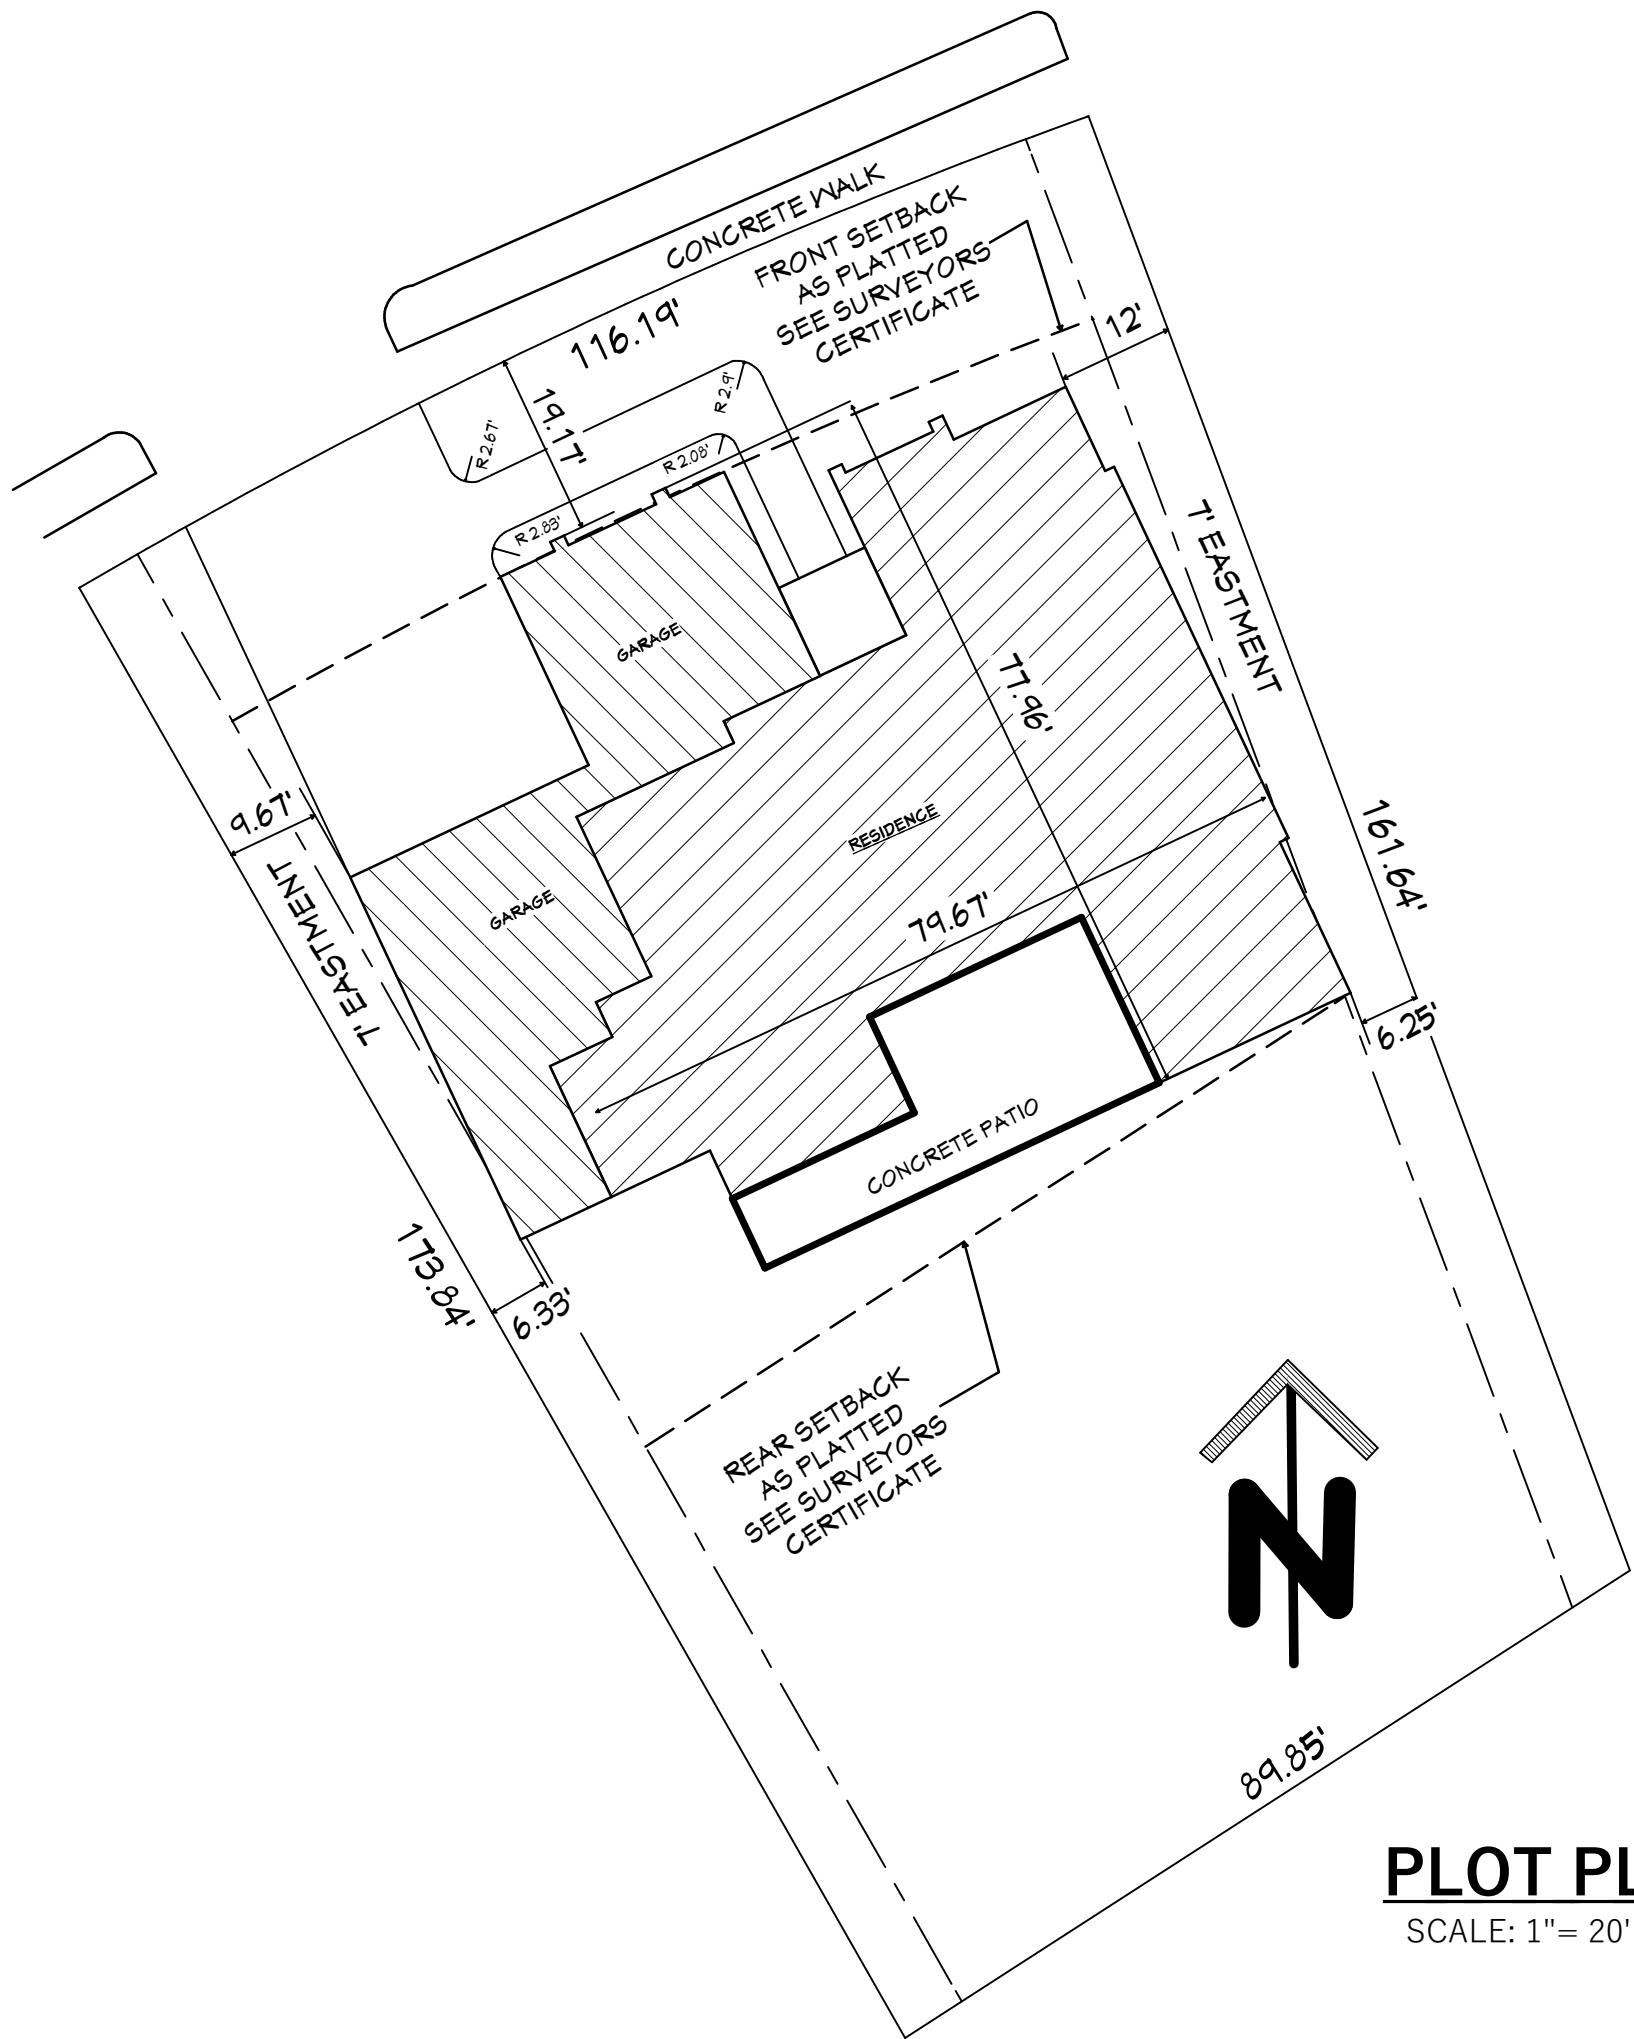

PLOT PLAN
SCALE: 1"= 20'

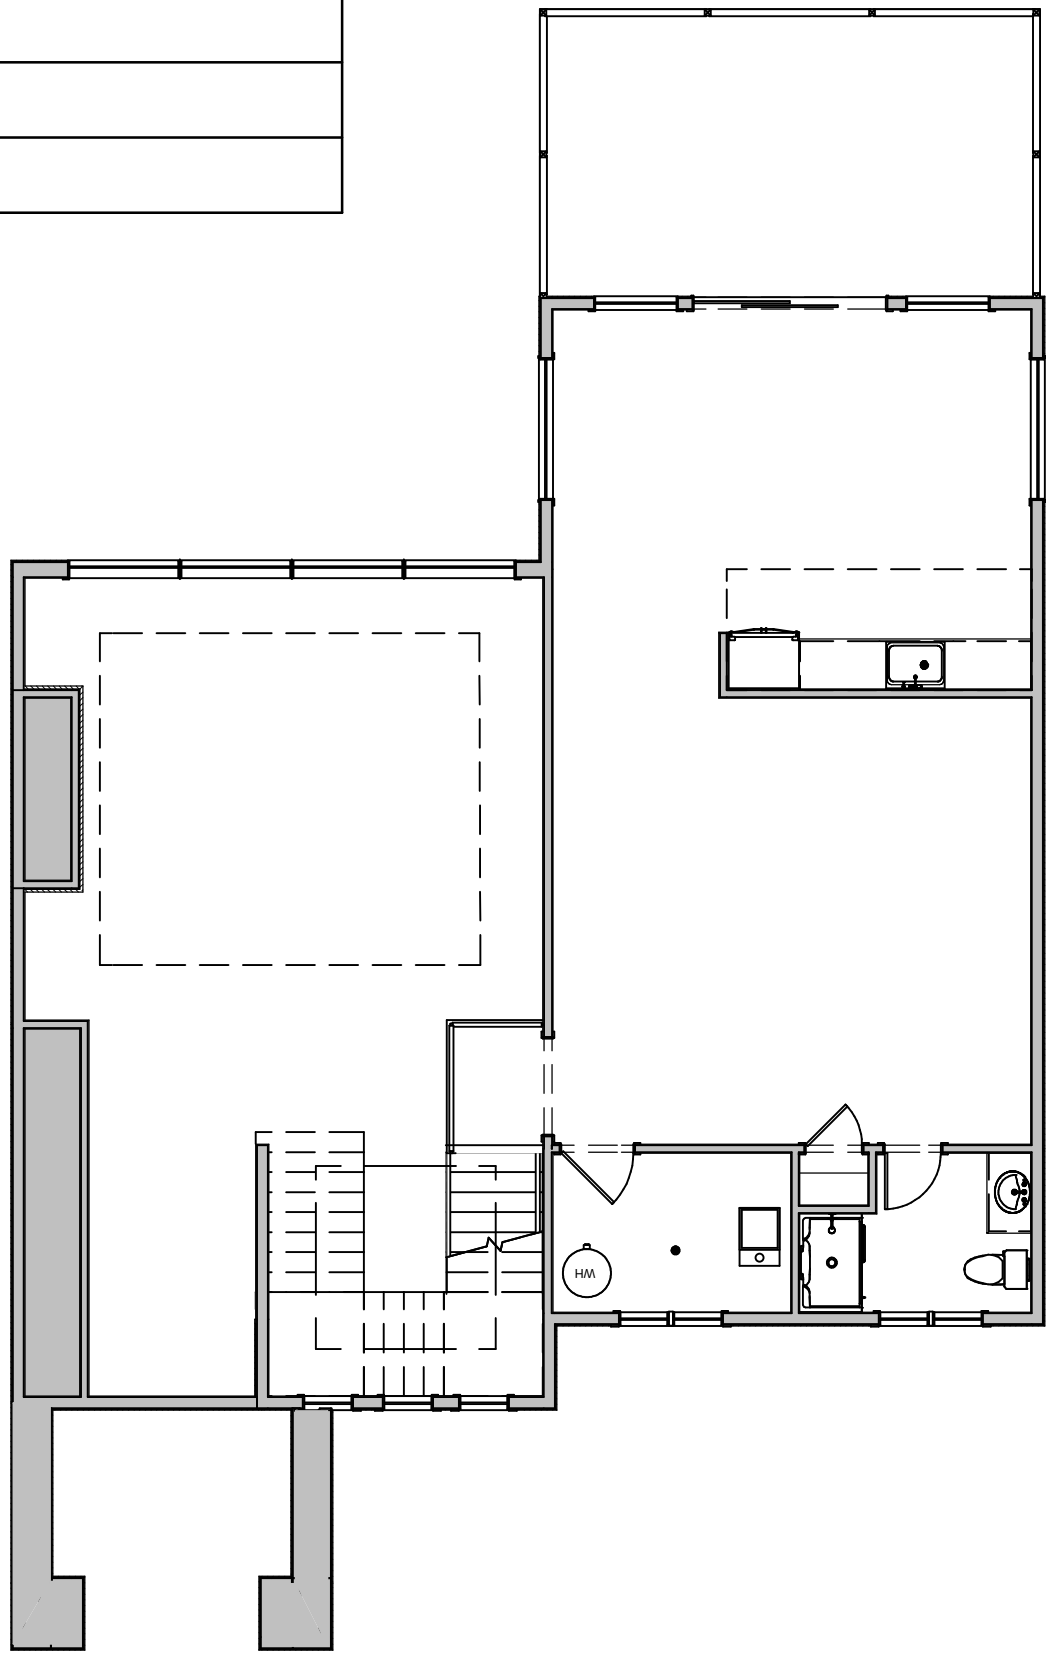

UPPER LEVEL BROCHURE
SCALE: 1/8"= 1'-0"

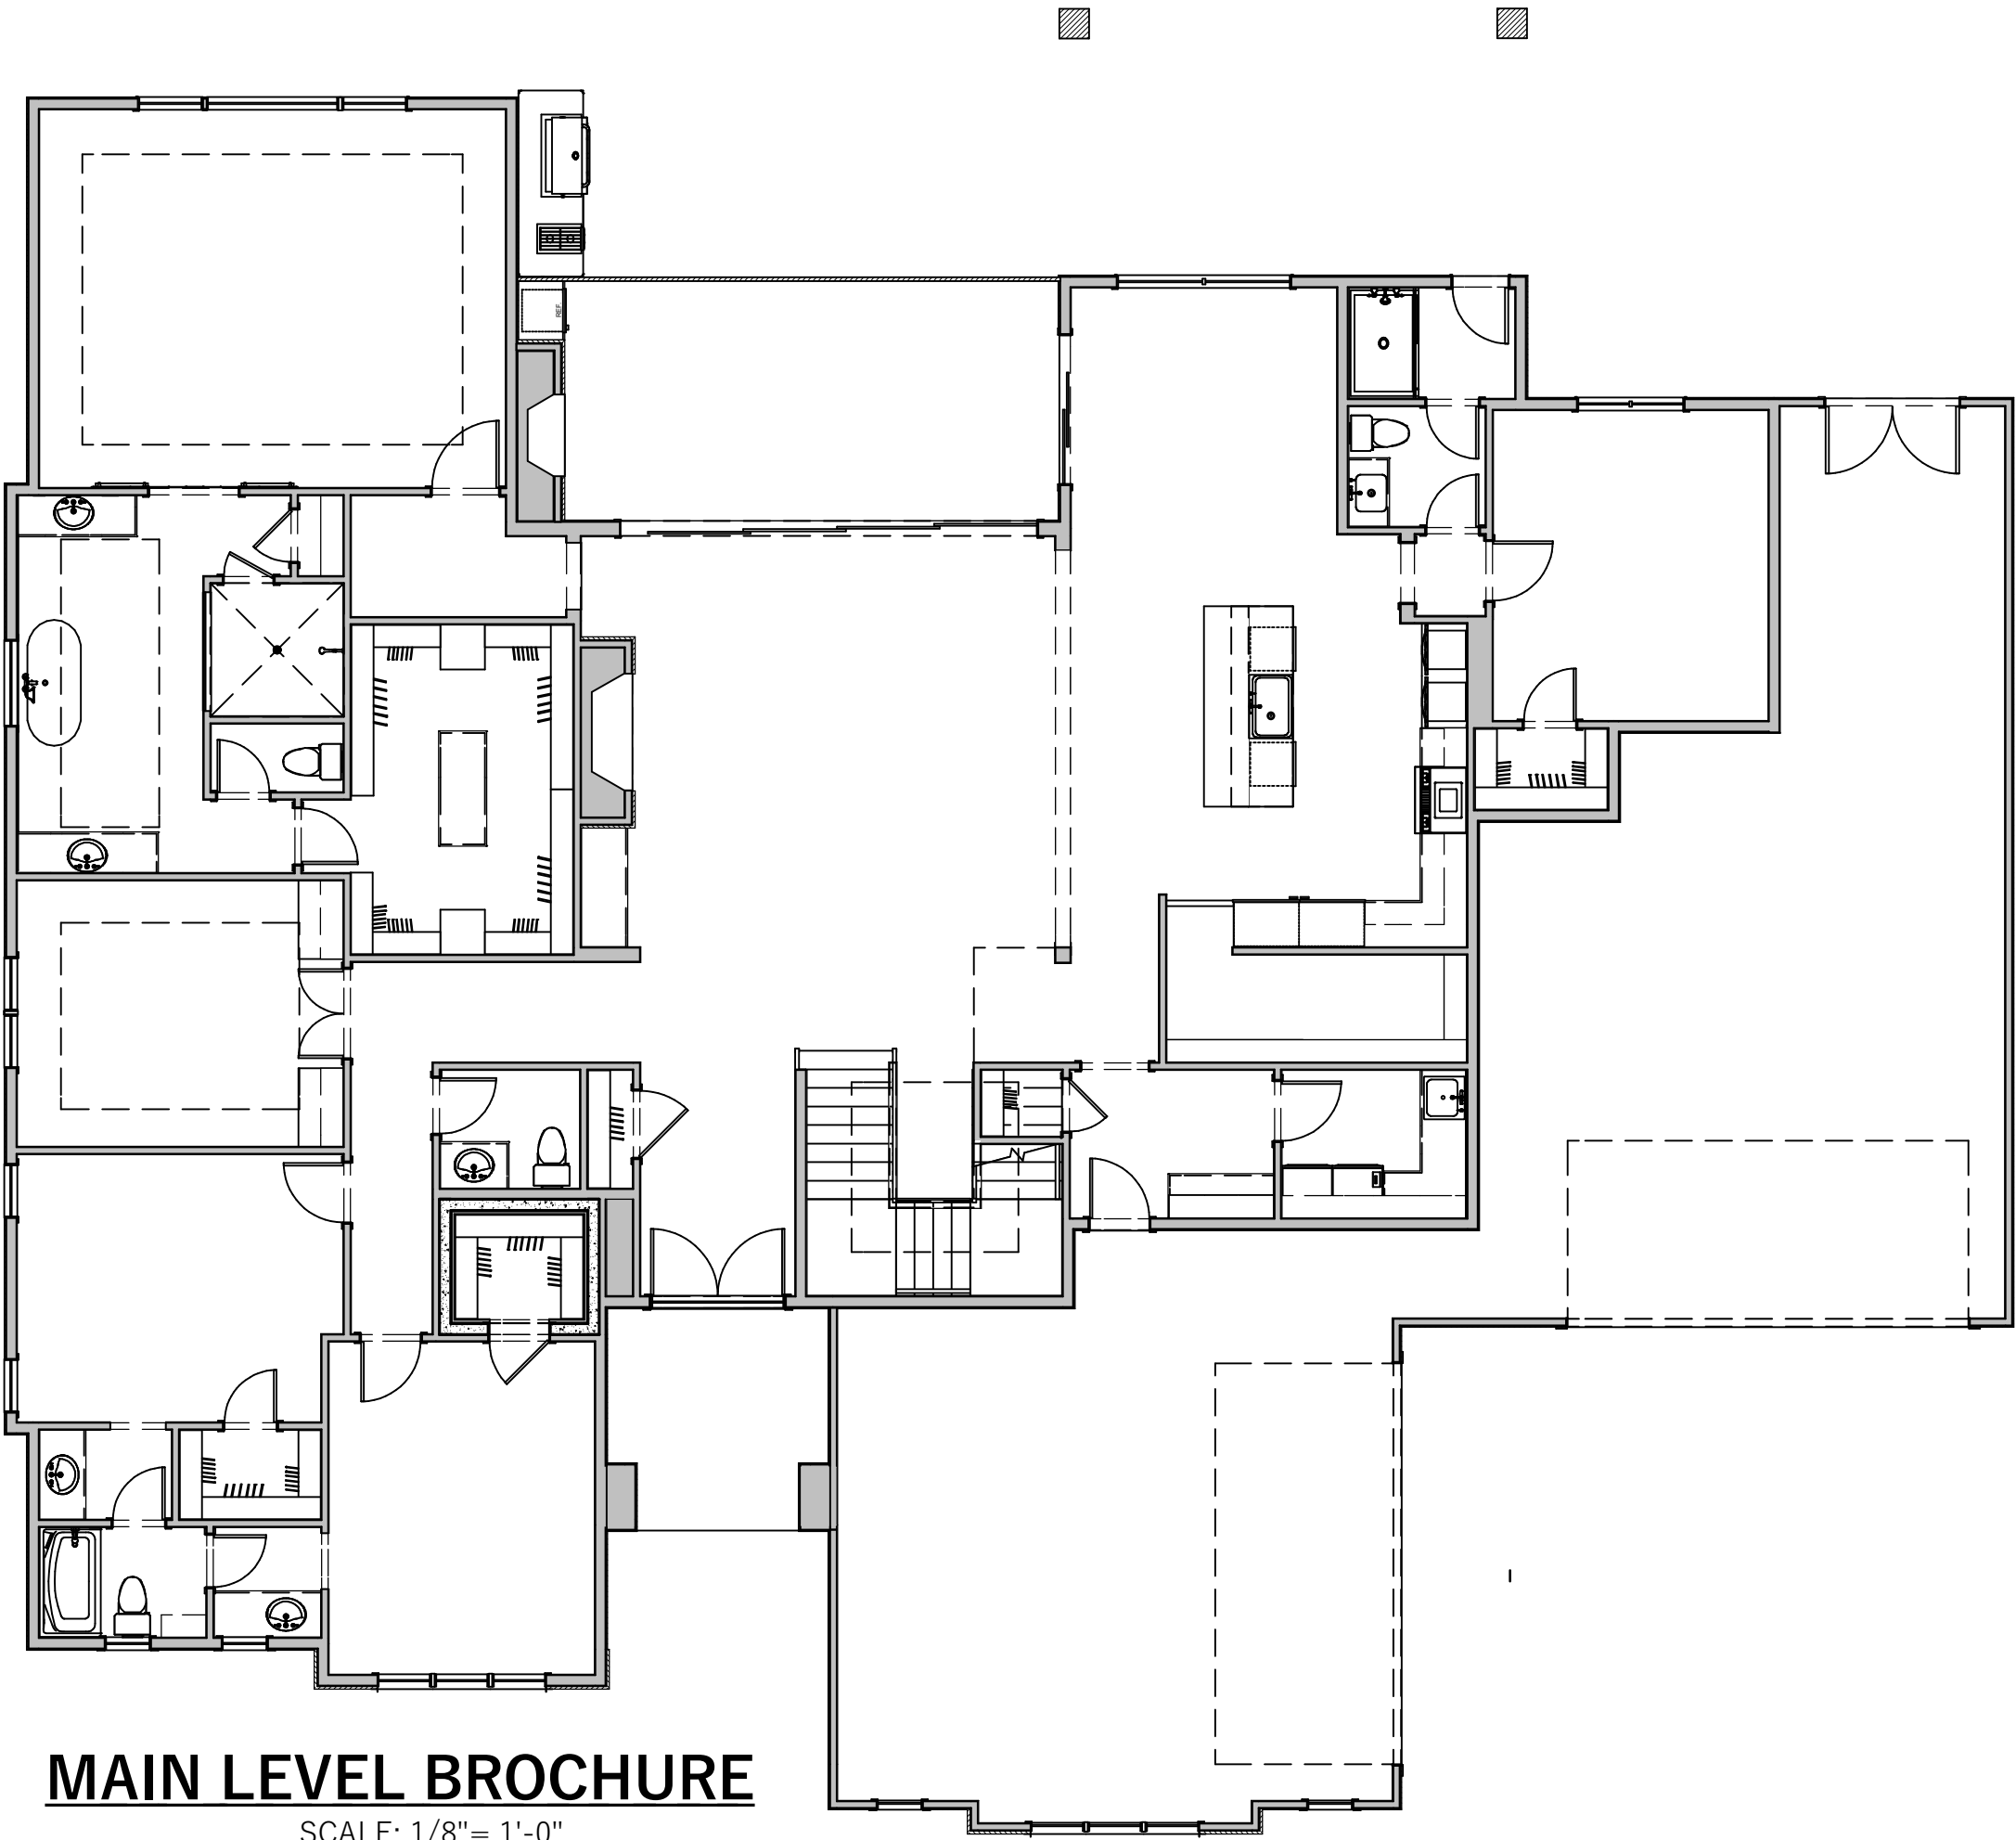

MAIN LEVEL BROCHURE
SCALE: 1/8"= 1'-0"

6217 N. 295TH ST.
LOT 119 BLUEWATER




FRONT RENDERING



REVISION TABLE	REVISION	DATE	DESCRIPTION


To the best of our knowledge these plans are drawn to comply with owner's requirements and the applicable codes and regulations. Each individual contractor, sub-contractor, and supplier is responsible for verifying the accuracy of the information and the safety of the construction. VirtuActive, LLC is not responsible for any errors or omissions in the plans or for any damage or injury resulting from the use of the plans. The user of the plans is responsible for obtaining all necessary permits and for complying with all applicable codes and regulations. The user of the plans is also responsible for obtaining all necessary information from the owner and for providing it to the contractor. The user of the plans is also responsible for obtaining all necessary information from the contractor and for providing it to the owner. The user of the plans is also responsible for obtaining all necessary information from the owner and for providing it to the contractor. The user of the plans is also responsible for obtaining all necessary information from the contractor and for providing it to the owner.

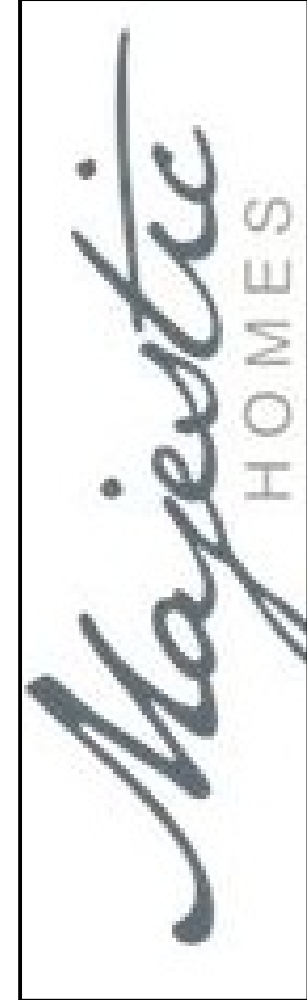


VIRTUACTIVE
VirtuActive - 3D Drafting & Design
331 Village Pointe Plaza, Suite 303, OMAHA, NE 68118
www.VirtuActive.com | 402.979.8100
Designed by: Brian Friehe | brian@virtuactive.com



DATE:
2/7/2017
SHEET:
1 OF 9

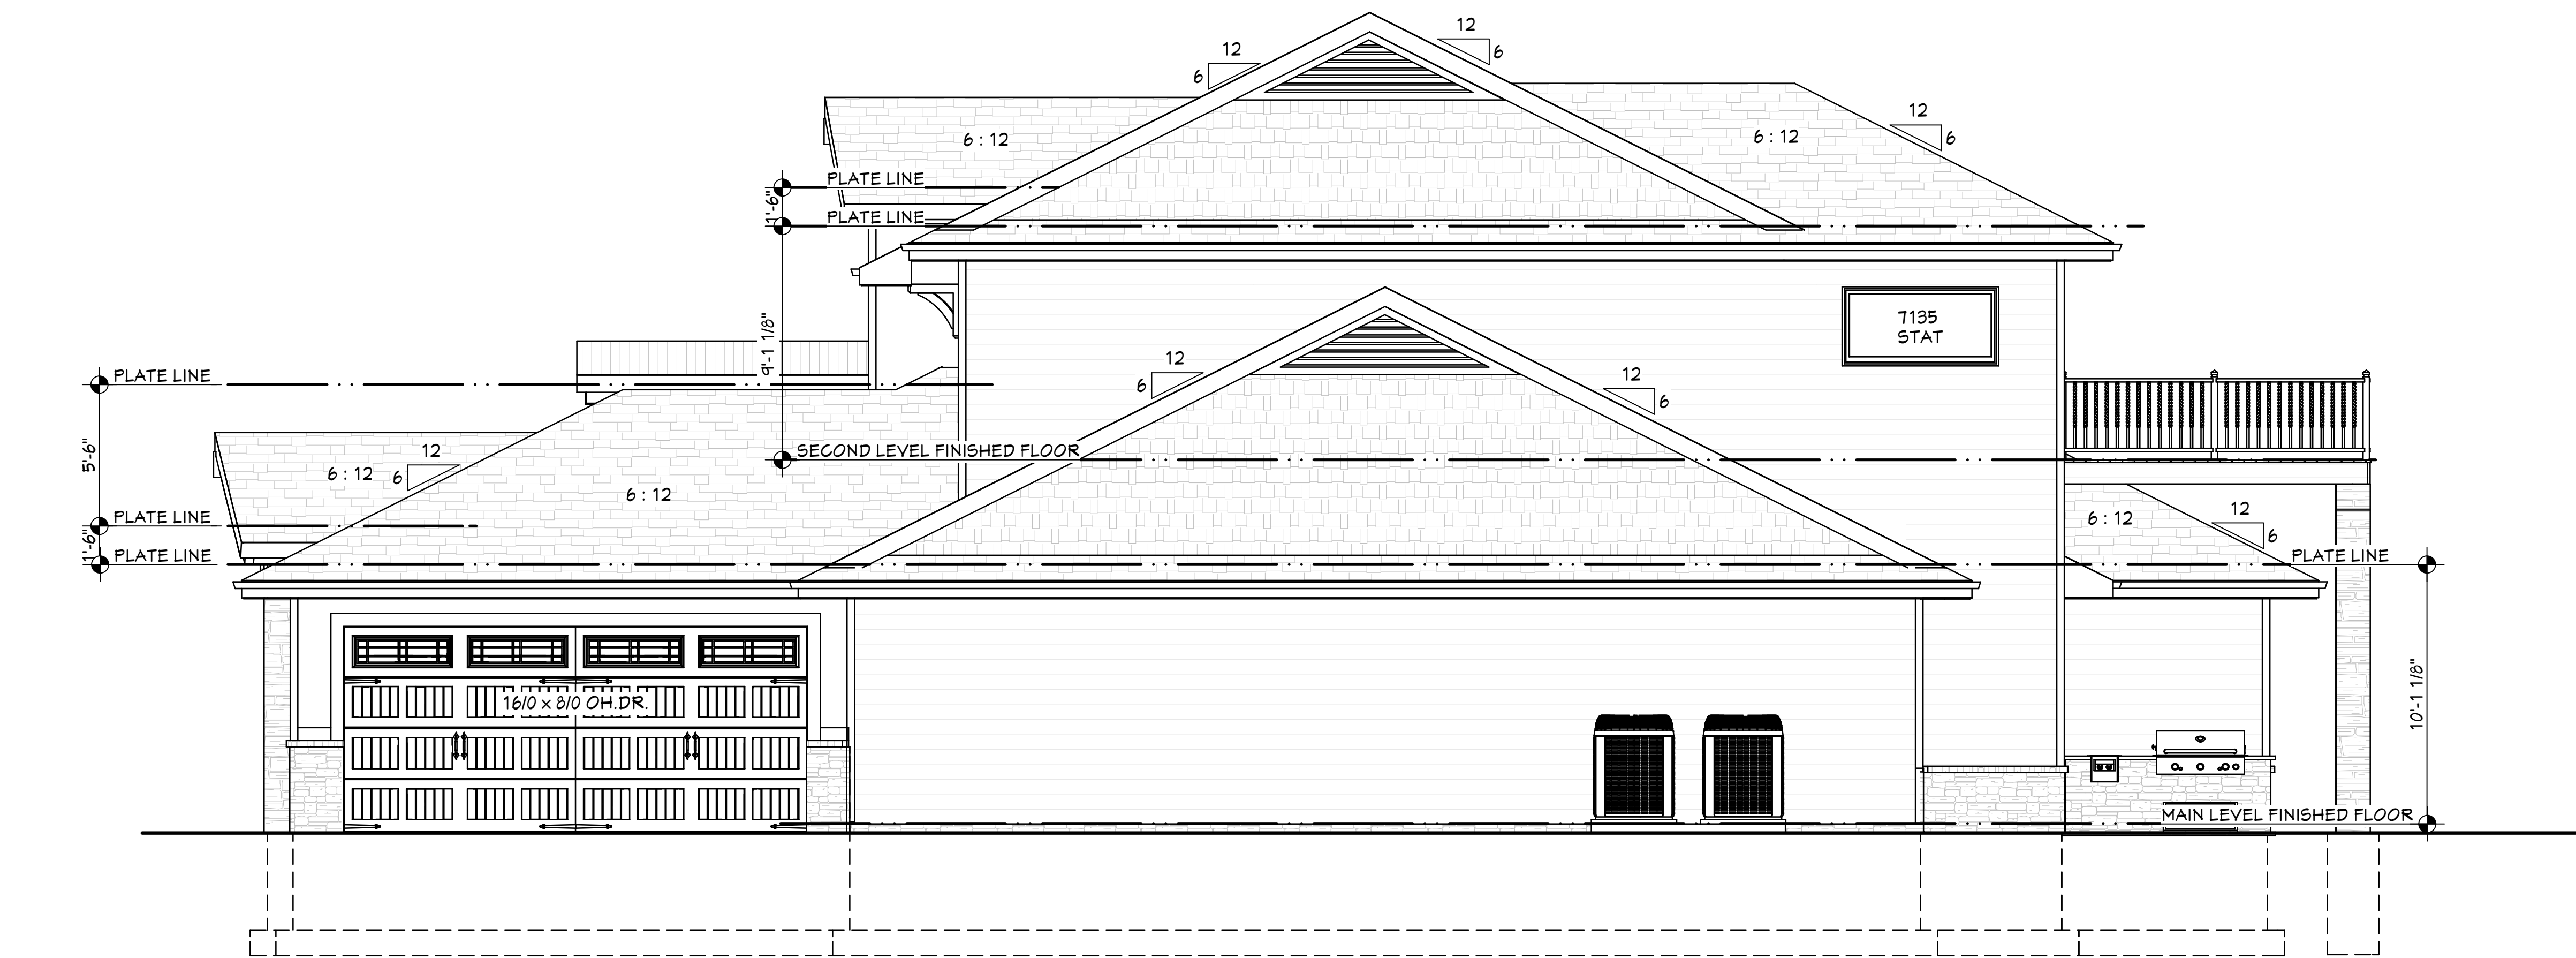

RIGHT SIDE ELEVATION
SCALE: 1/4" = 1"

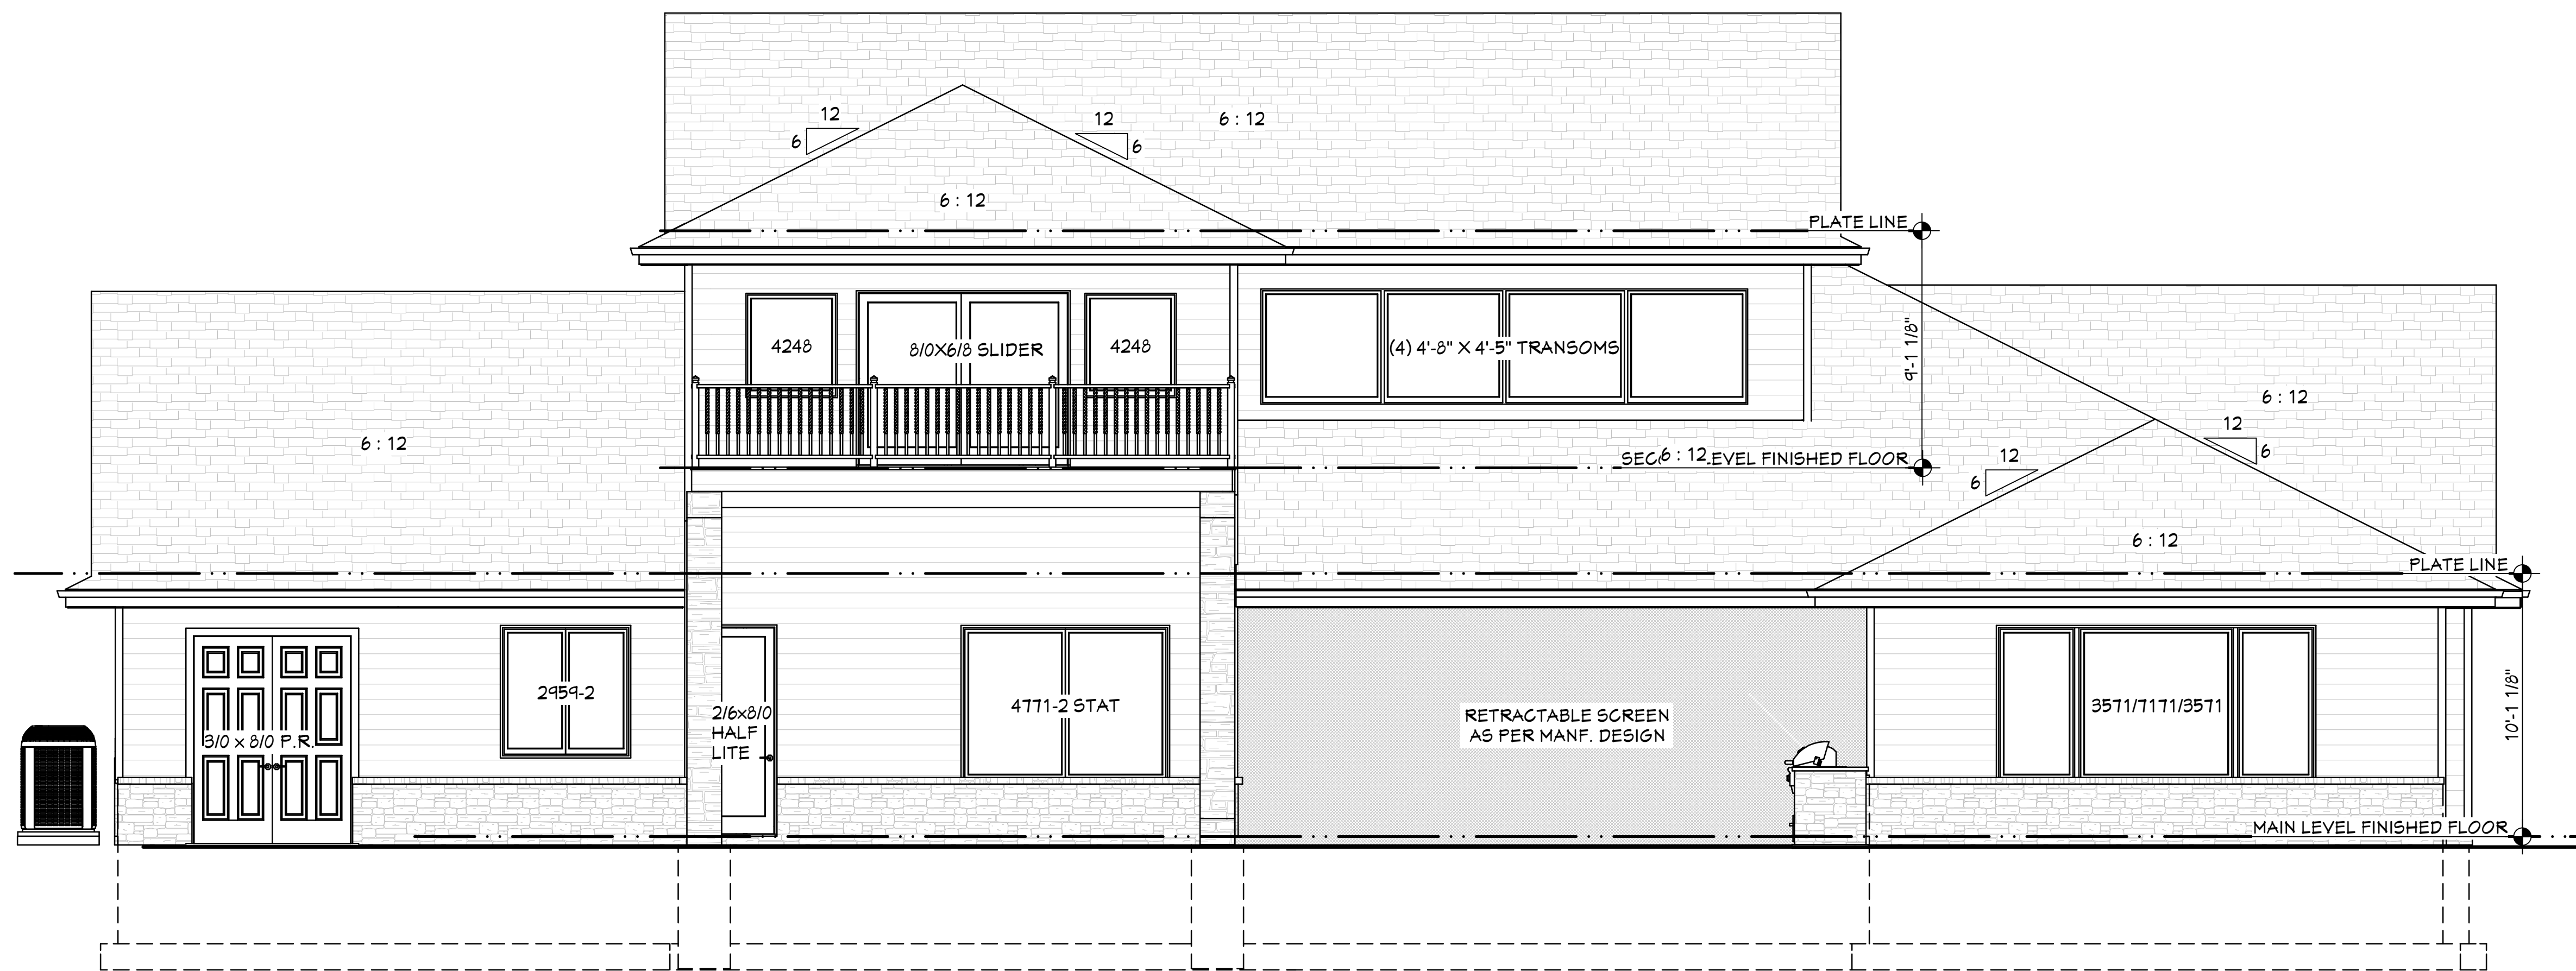


REAR ELEVATION
SCALE: 1/4" = 1"



REVISION TABLE		REVISION BY	DESCRIPTION
NUMBER	DATE		

These drawings are the property of VirtuaActive, LLC. No part of these drawings may be reproduced, stored in a retrieval system, or transmitted, in any form or by any means, electronic, mechanical, photocopying, recording, or by any information storage and retrieval system, without the prior written permission of VirtuaActive, LLC. It is prohibited to use these drawings for any other project without the prior written permission of VirtuaActive, LLC. To the best of our knowledge these plans are drawn to comply with owner's specifications and are not to be used for any other project without the prior written permission of VirtuaActive, LLC. Each individual contractor, subcontractor, and supplier is responsible for verifying all dimensions and included drawings. Each individual contractor, subcontractor, and supplier is responsible for verifying all dimensions and included drawings. Contractors, subcontractors, and suppliers are responsible for verifying all dimensions and included drawings. VirtuaActive, LLC will not be held responsible for negligence or the project due to lack of knowledge or skill. Size, spacing, and location of structural members, size, availability, and dimensions shall be verified by the contractor, subcontractor, and supplier prior to construction.

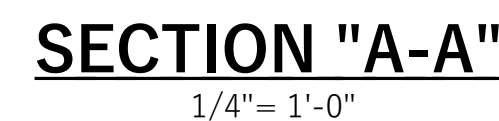

[illegible][illegible]

These drawings are the proprietary work product and property of VirtuArch, LLC and are prepared for the exclusive use of VirtuArch, LLC. Use of these drawings and concepts without written approval from the written permission of VirtuArch, LLC is prohibited.

To the best of our knowledge these plans are drawn to comply with owner's specifications. The contractor, sub-contractors, suppliers, and/or owner(s) shall verify all dimensions and enclosed drawings. Each individual contractor, sub-contractor, and supplier on the job must check all dimensions and other details prior to construction and be solely responsible thereafter. Contractors, sub-contractors, and suppliers are not to be held responsible for any errors or omissions on the drawings. VirtuArch, LLC will not be held responsible for negligence on the job site due to lack of knowledge or lack of plan detail from the sub-contractors. Designer is not an architect or engineer. No spacing, revision, and location of structural members, site suitability, and dimensions shall be



VirtuActive - 3D Drafting & Design
 331 Village Pointe Plaza, Suite 303, OMAHA, NE 68118
www.VirtuActive.com 402.979.8100

DATE:
2/7/2017
SHEET:
5 OF 9




STAIRS / GUARDRAILS

Max riser ht = 7 3/4"	Min tread depth = 10"
Min headroom = 80"	Min stair width = 36"

Handrails are req'd on one side of stairways of 4 or more risers. Handrail height shall be 34" to 38" above the nosing. Min 36" high guardrails at decks and 34" high at stairs are req'd at vertical drops over 30".


Guardrail openings shall not allow the passage of a 4" max dia sphere.

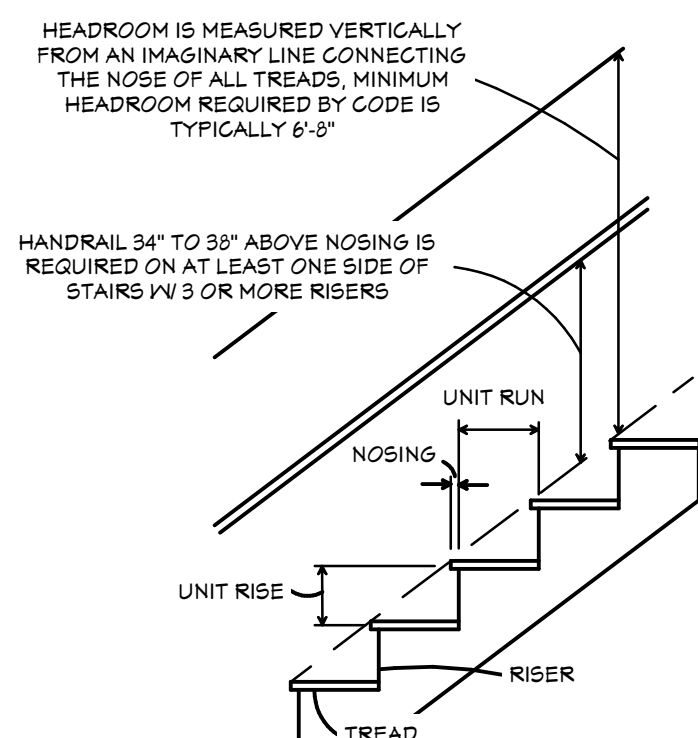


TYPICAL STAIR DIMENSIONS


FINISHED SQ. FT.	
MAIN FLOOR	3,574
2ND FLOOR	920
TOTAL	4,494

UNFINISHED SQ. FT.	
GARAGE	1430

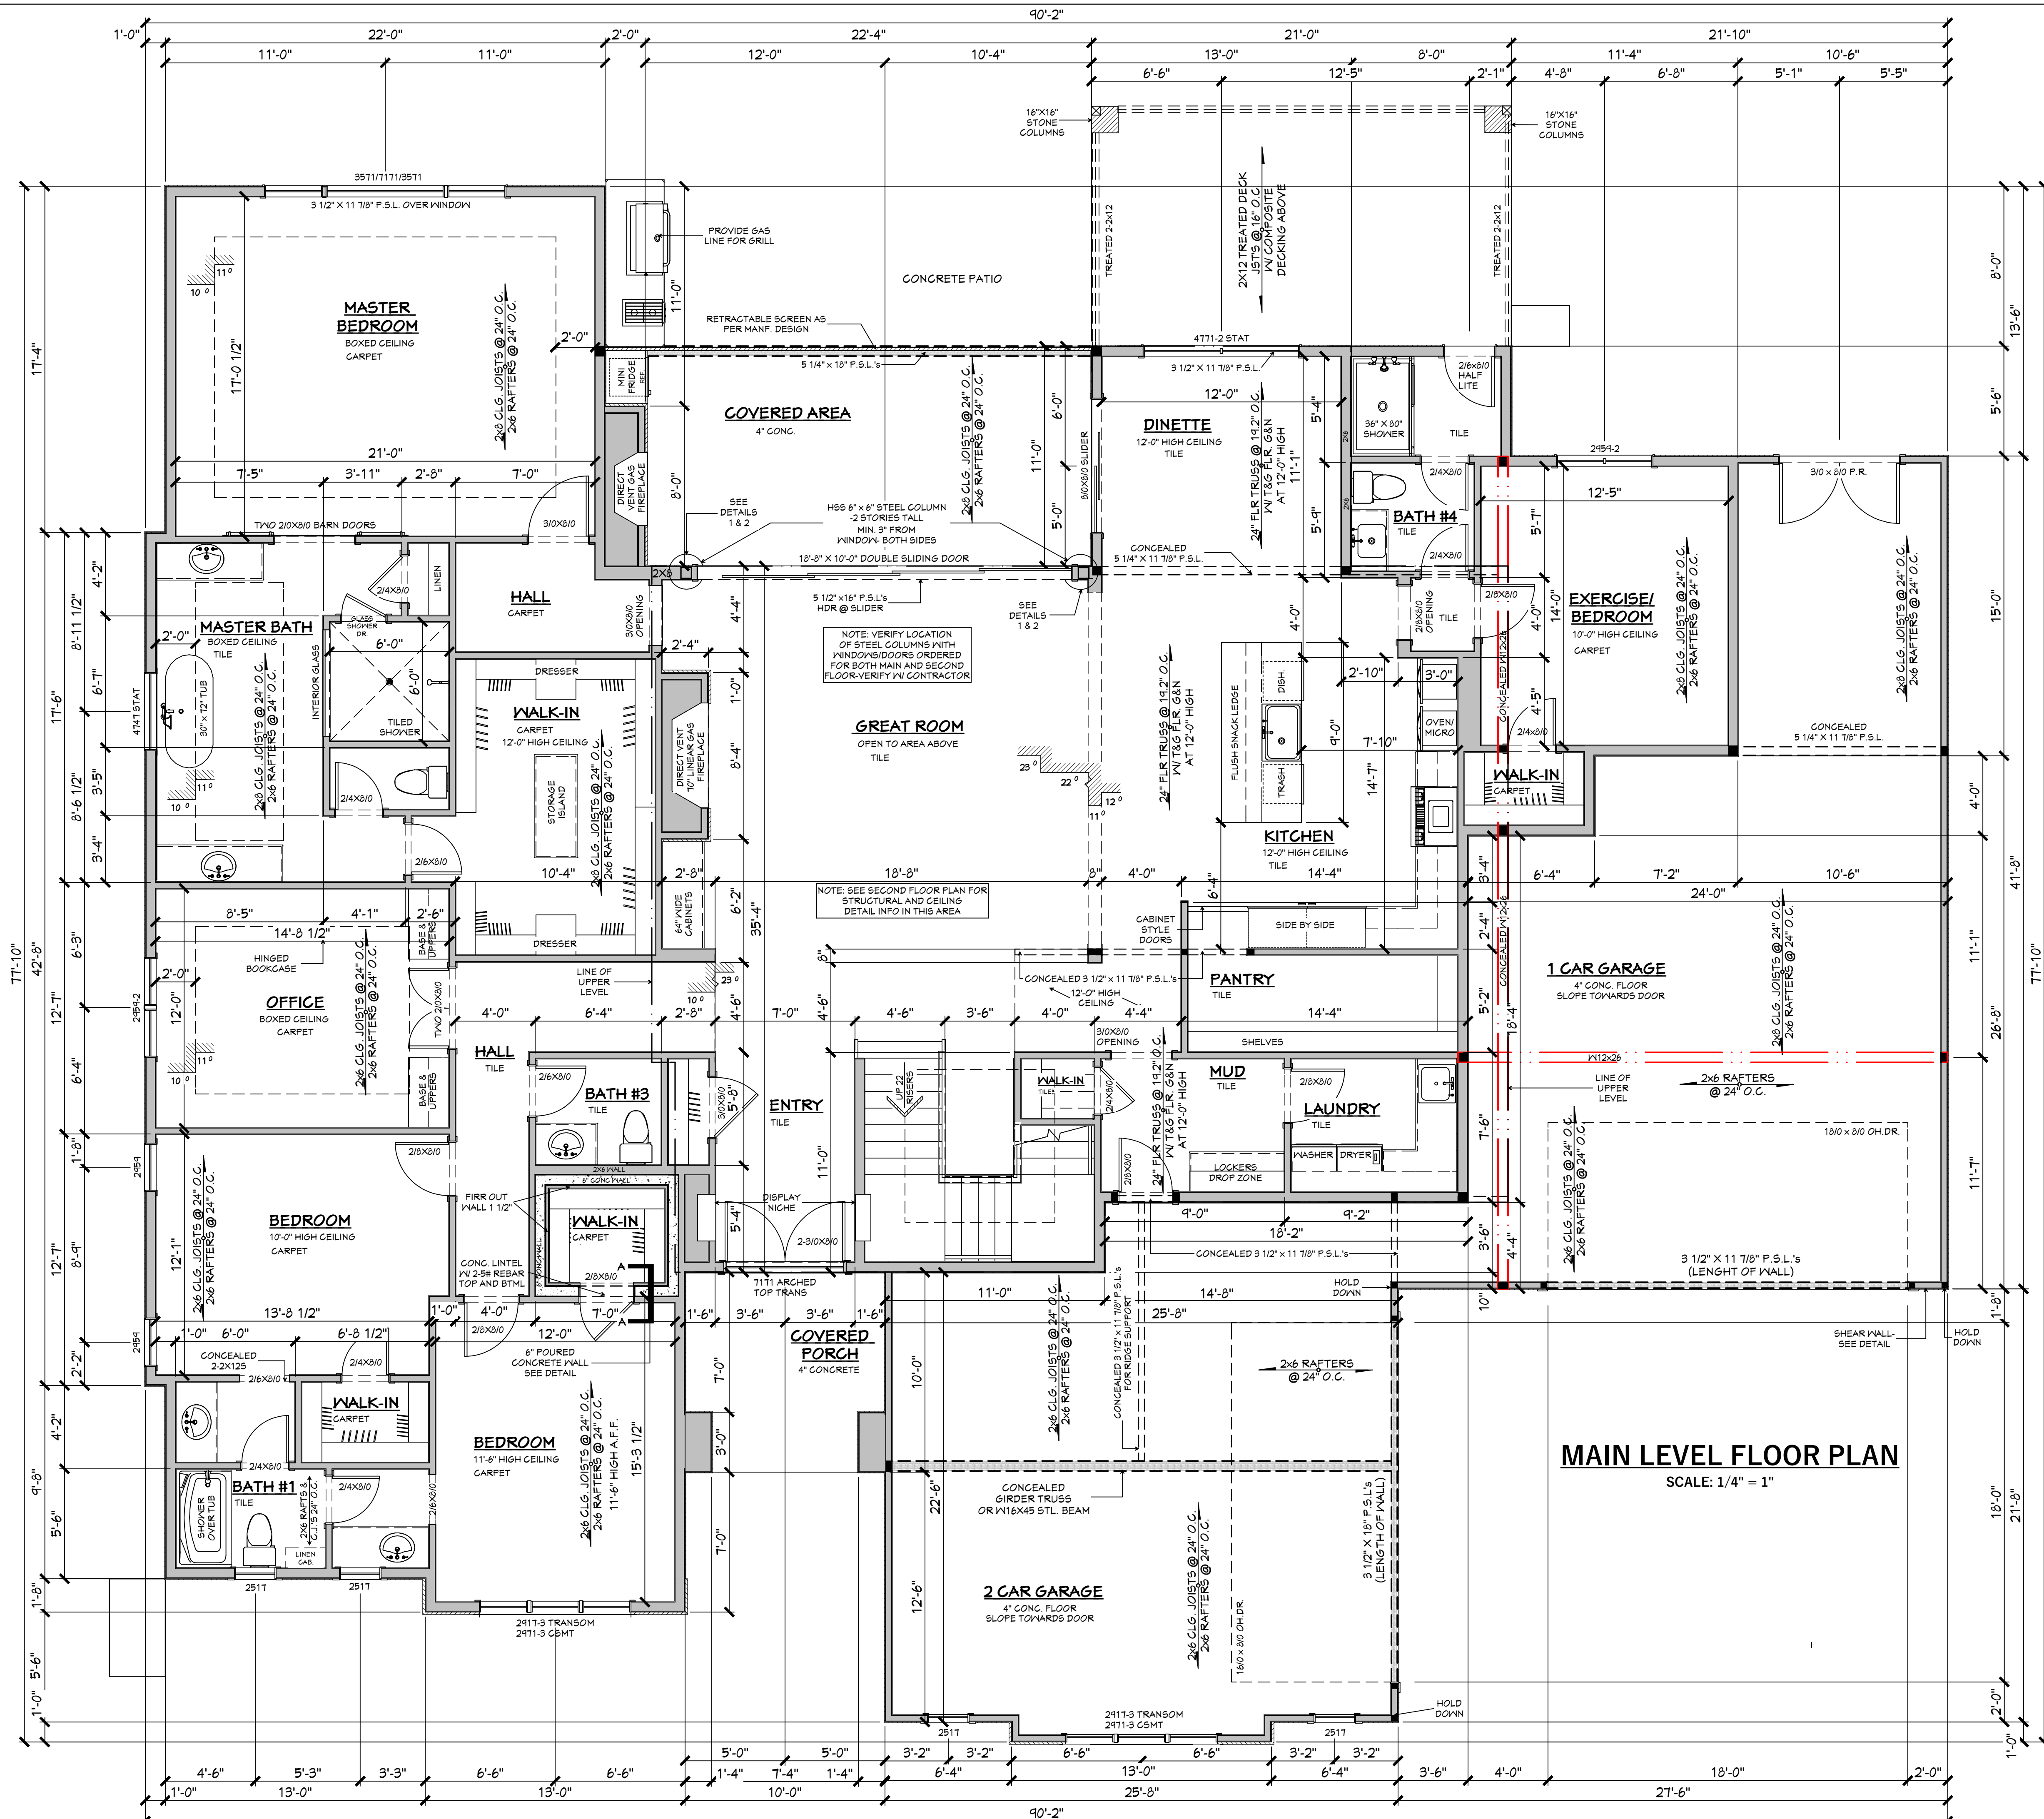


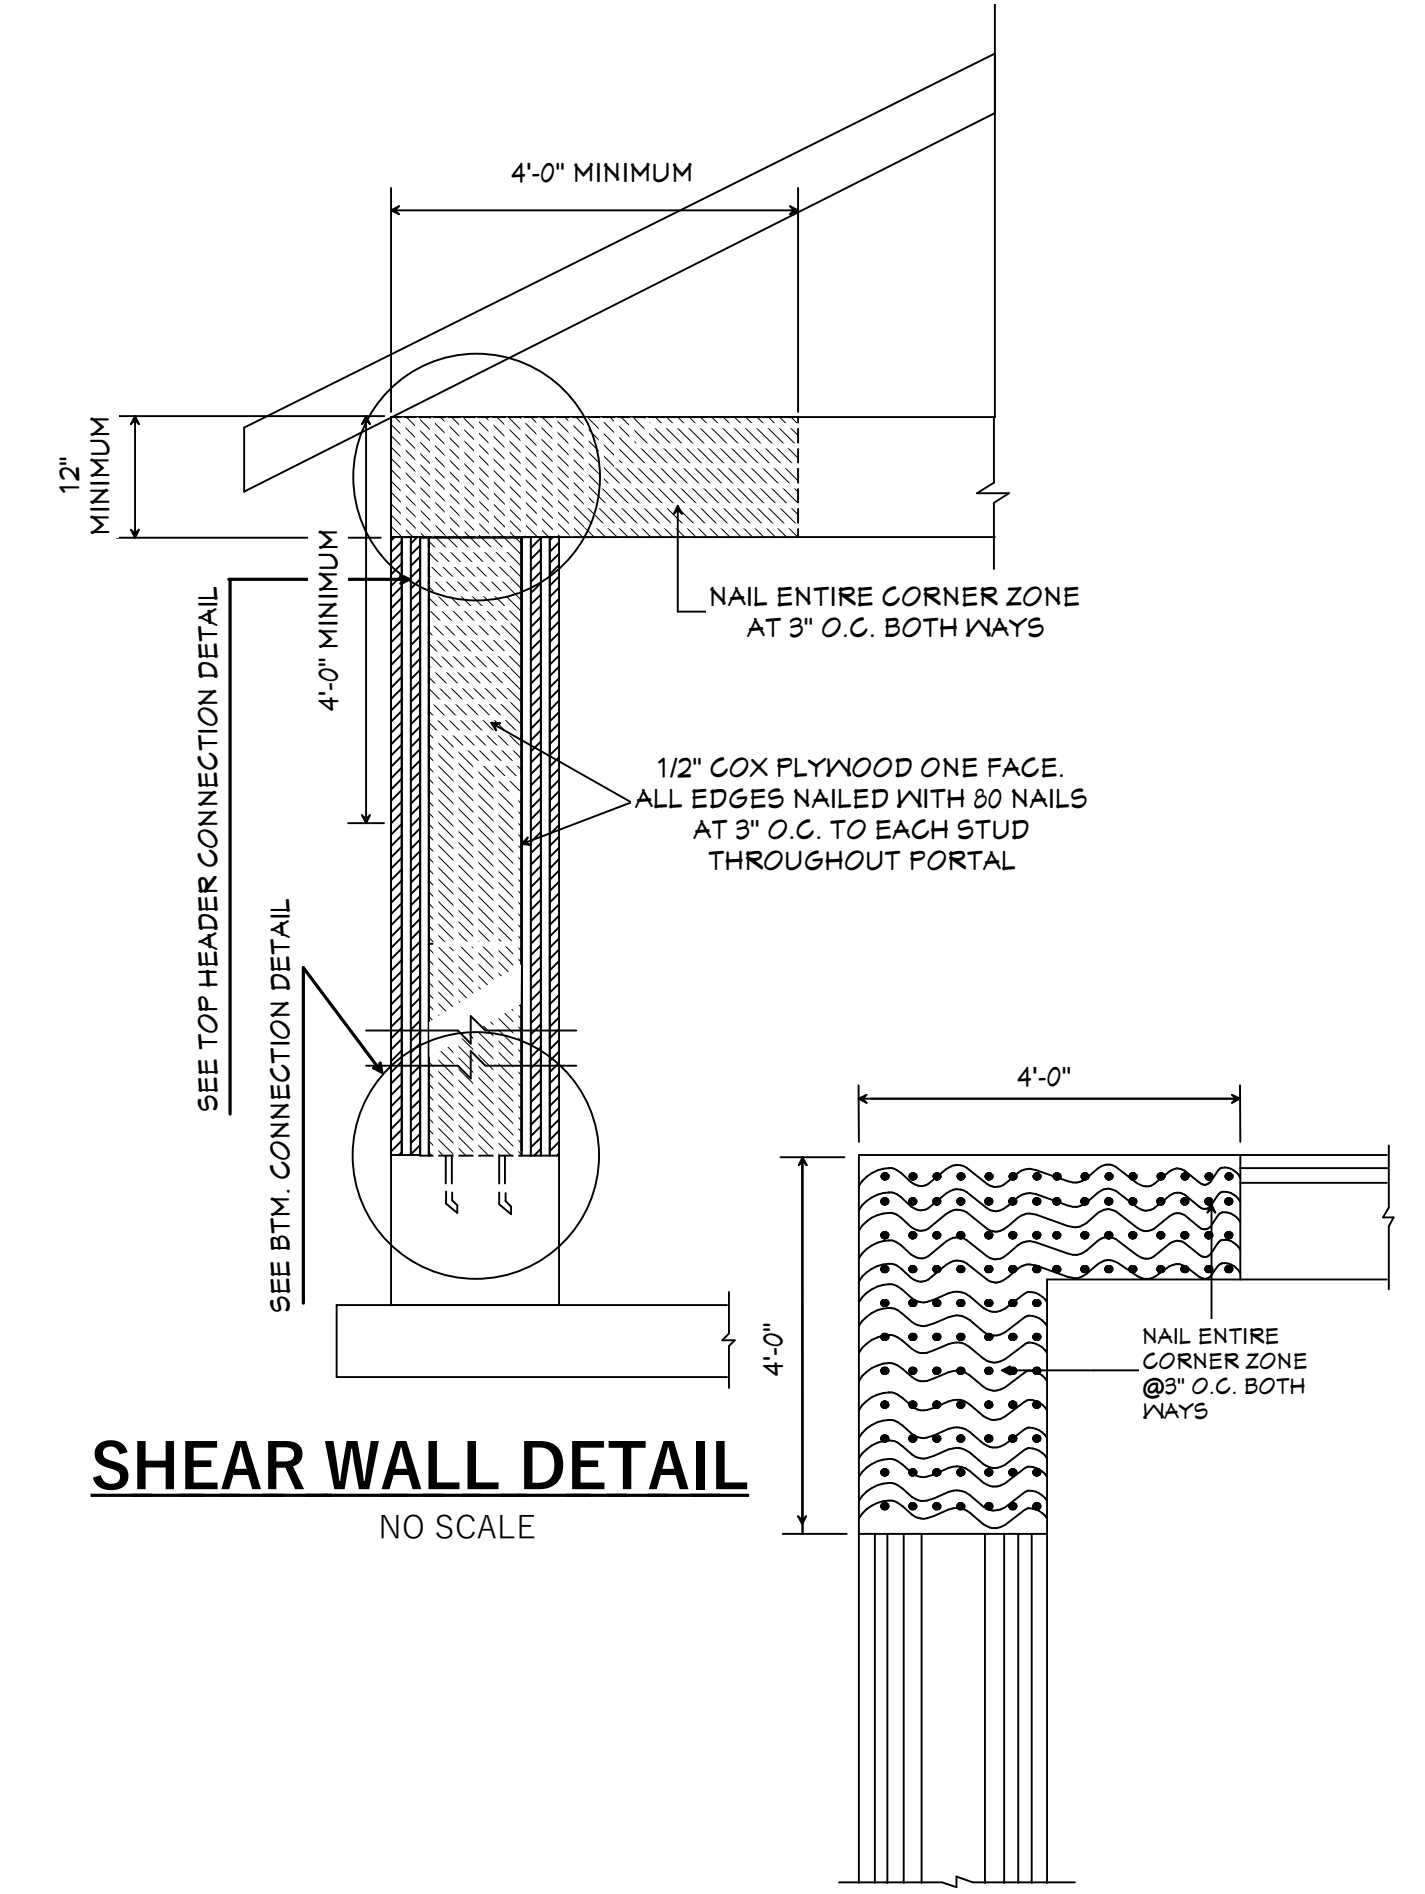


SHEAR WALL DETAIL
NO SCALE

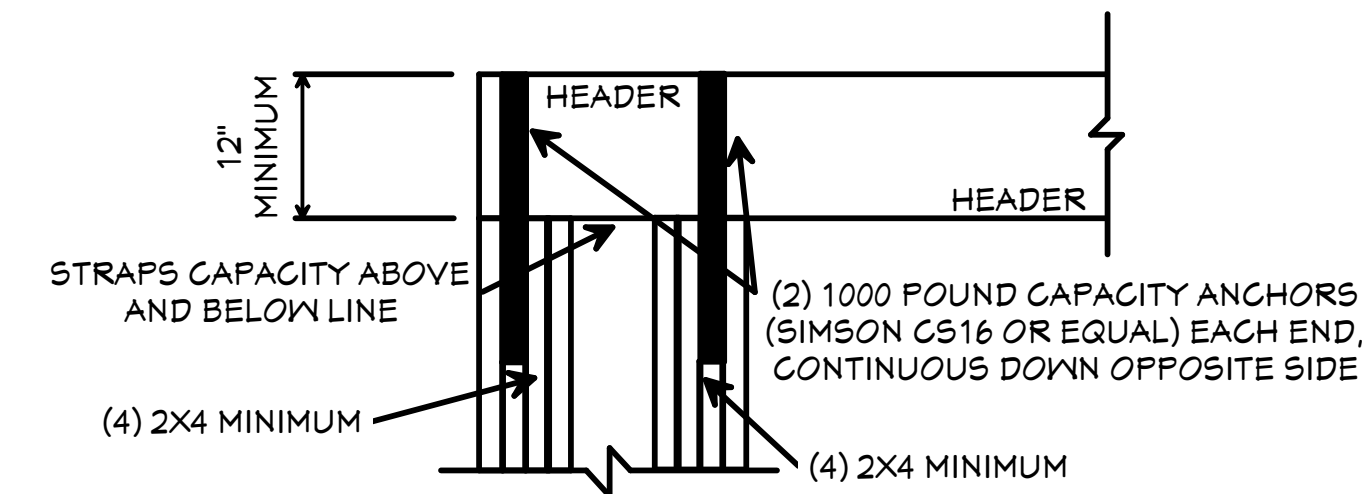


TOP HDR. CONNECTION
SCALE: 3/4" = 1'-0"

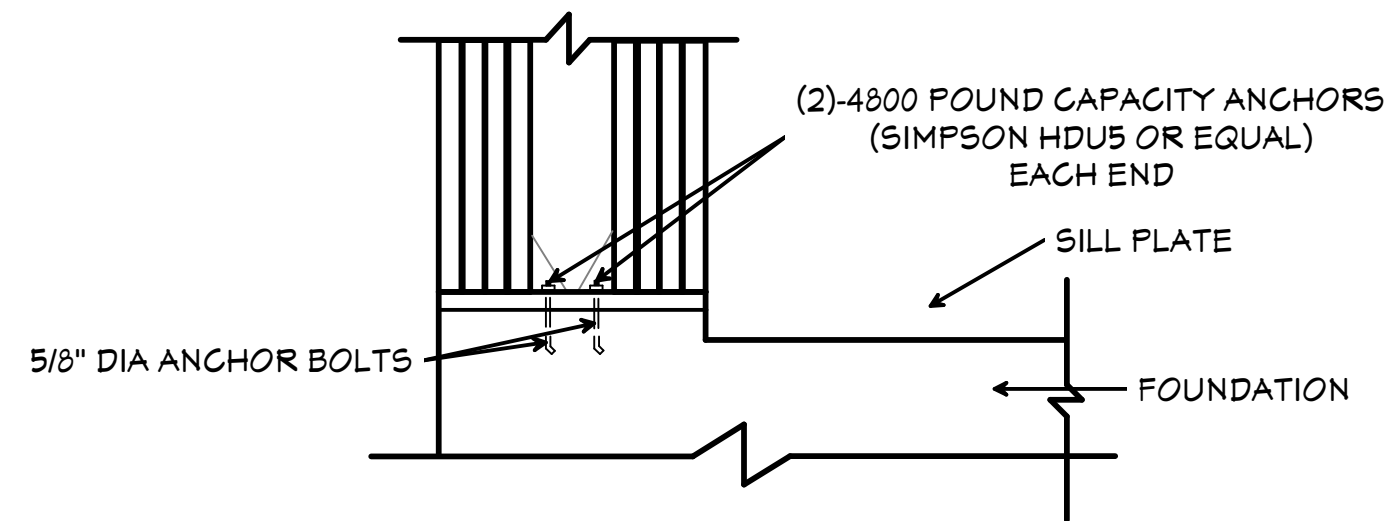

BTM. CONNECTION AT FLR.
SCALE: 3/4" = 1'-0"

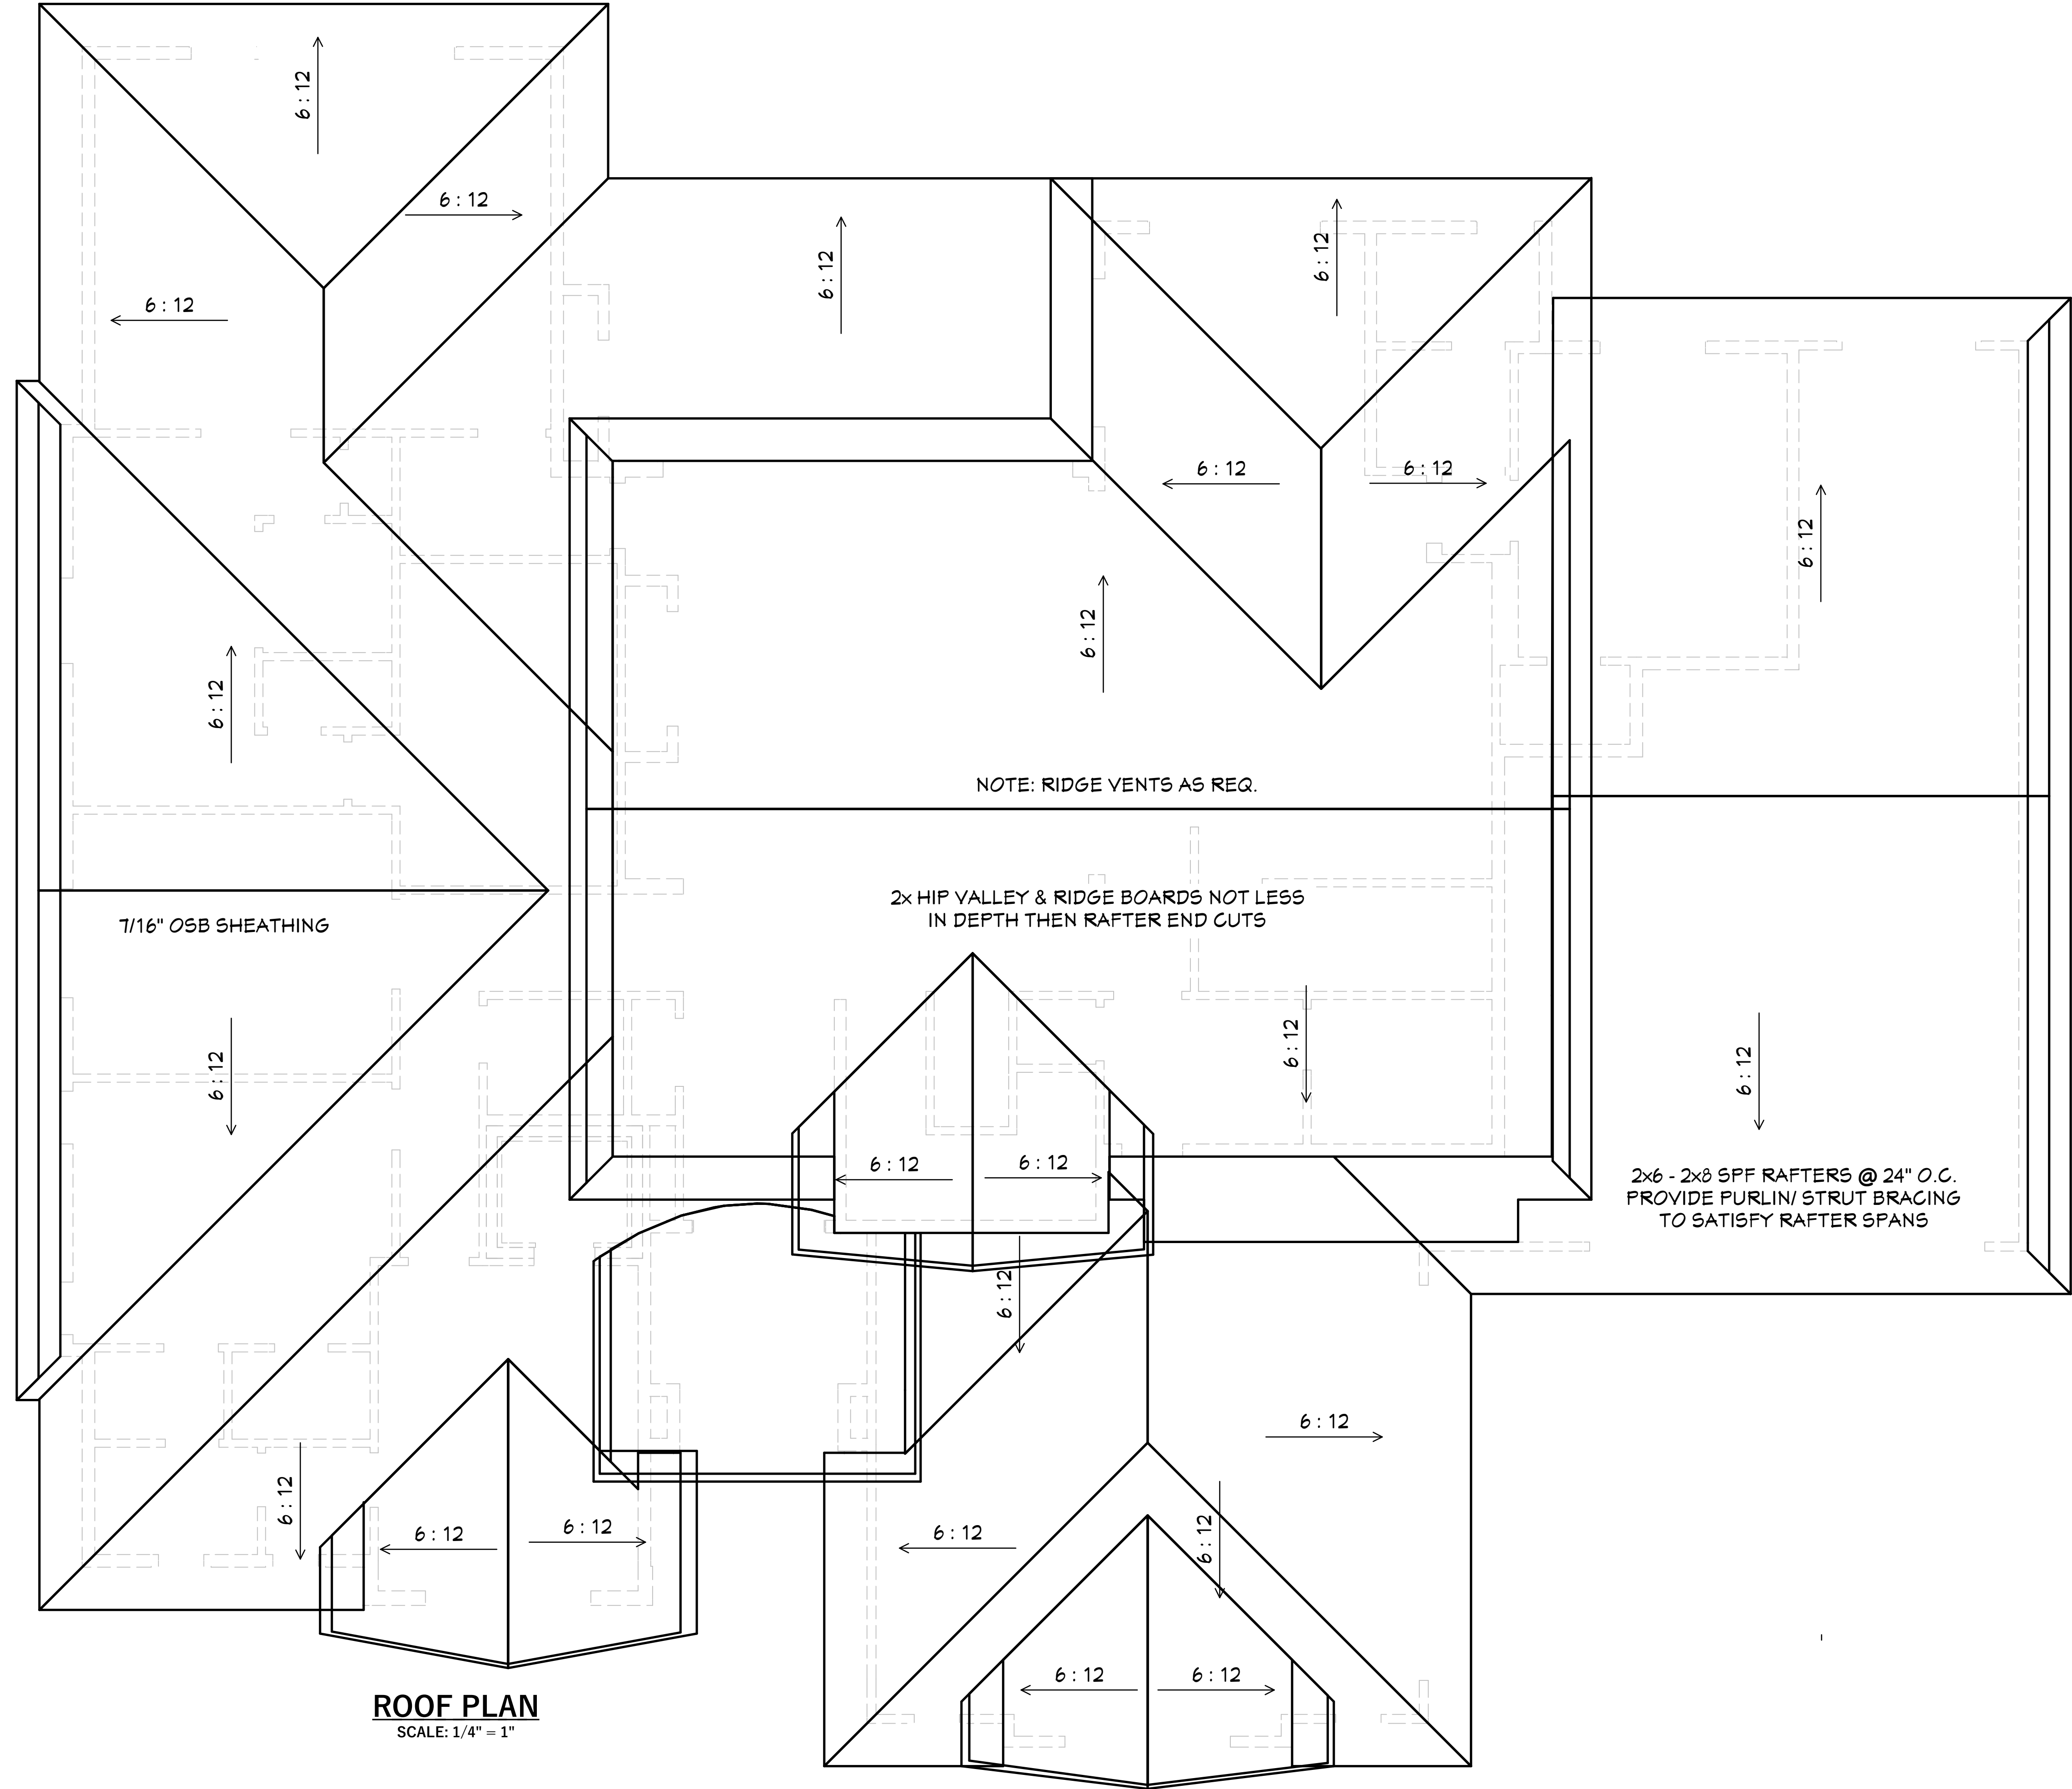

ROOF PLAN
SCALE: 1/4" = 1"

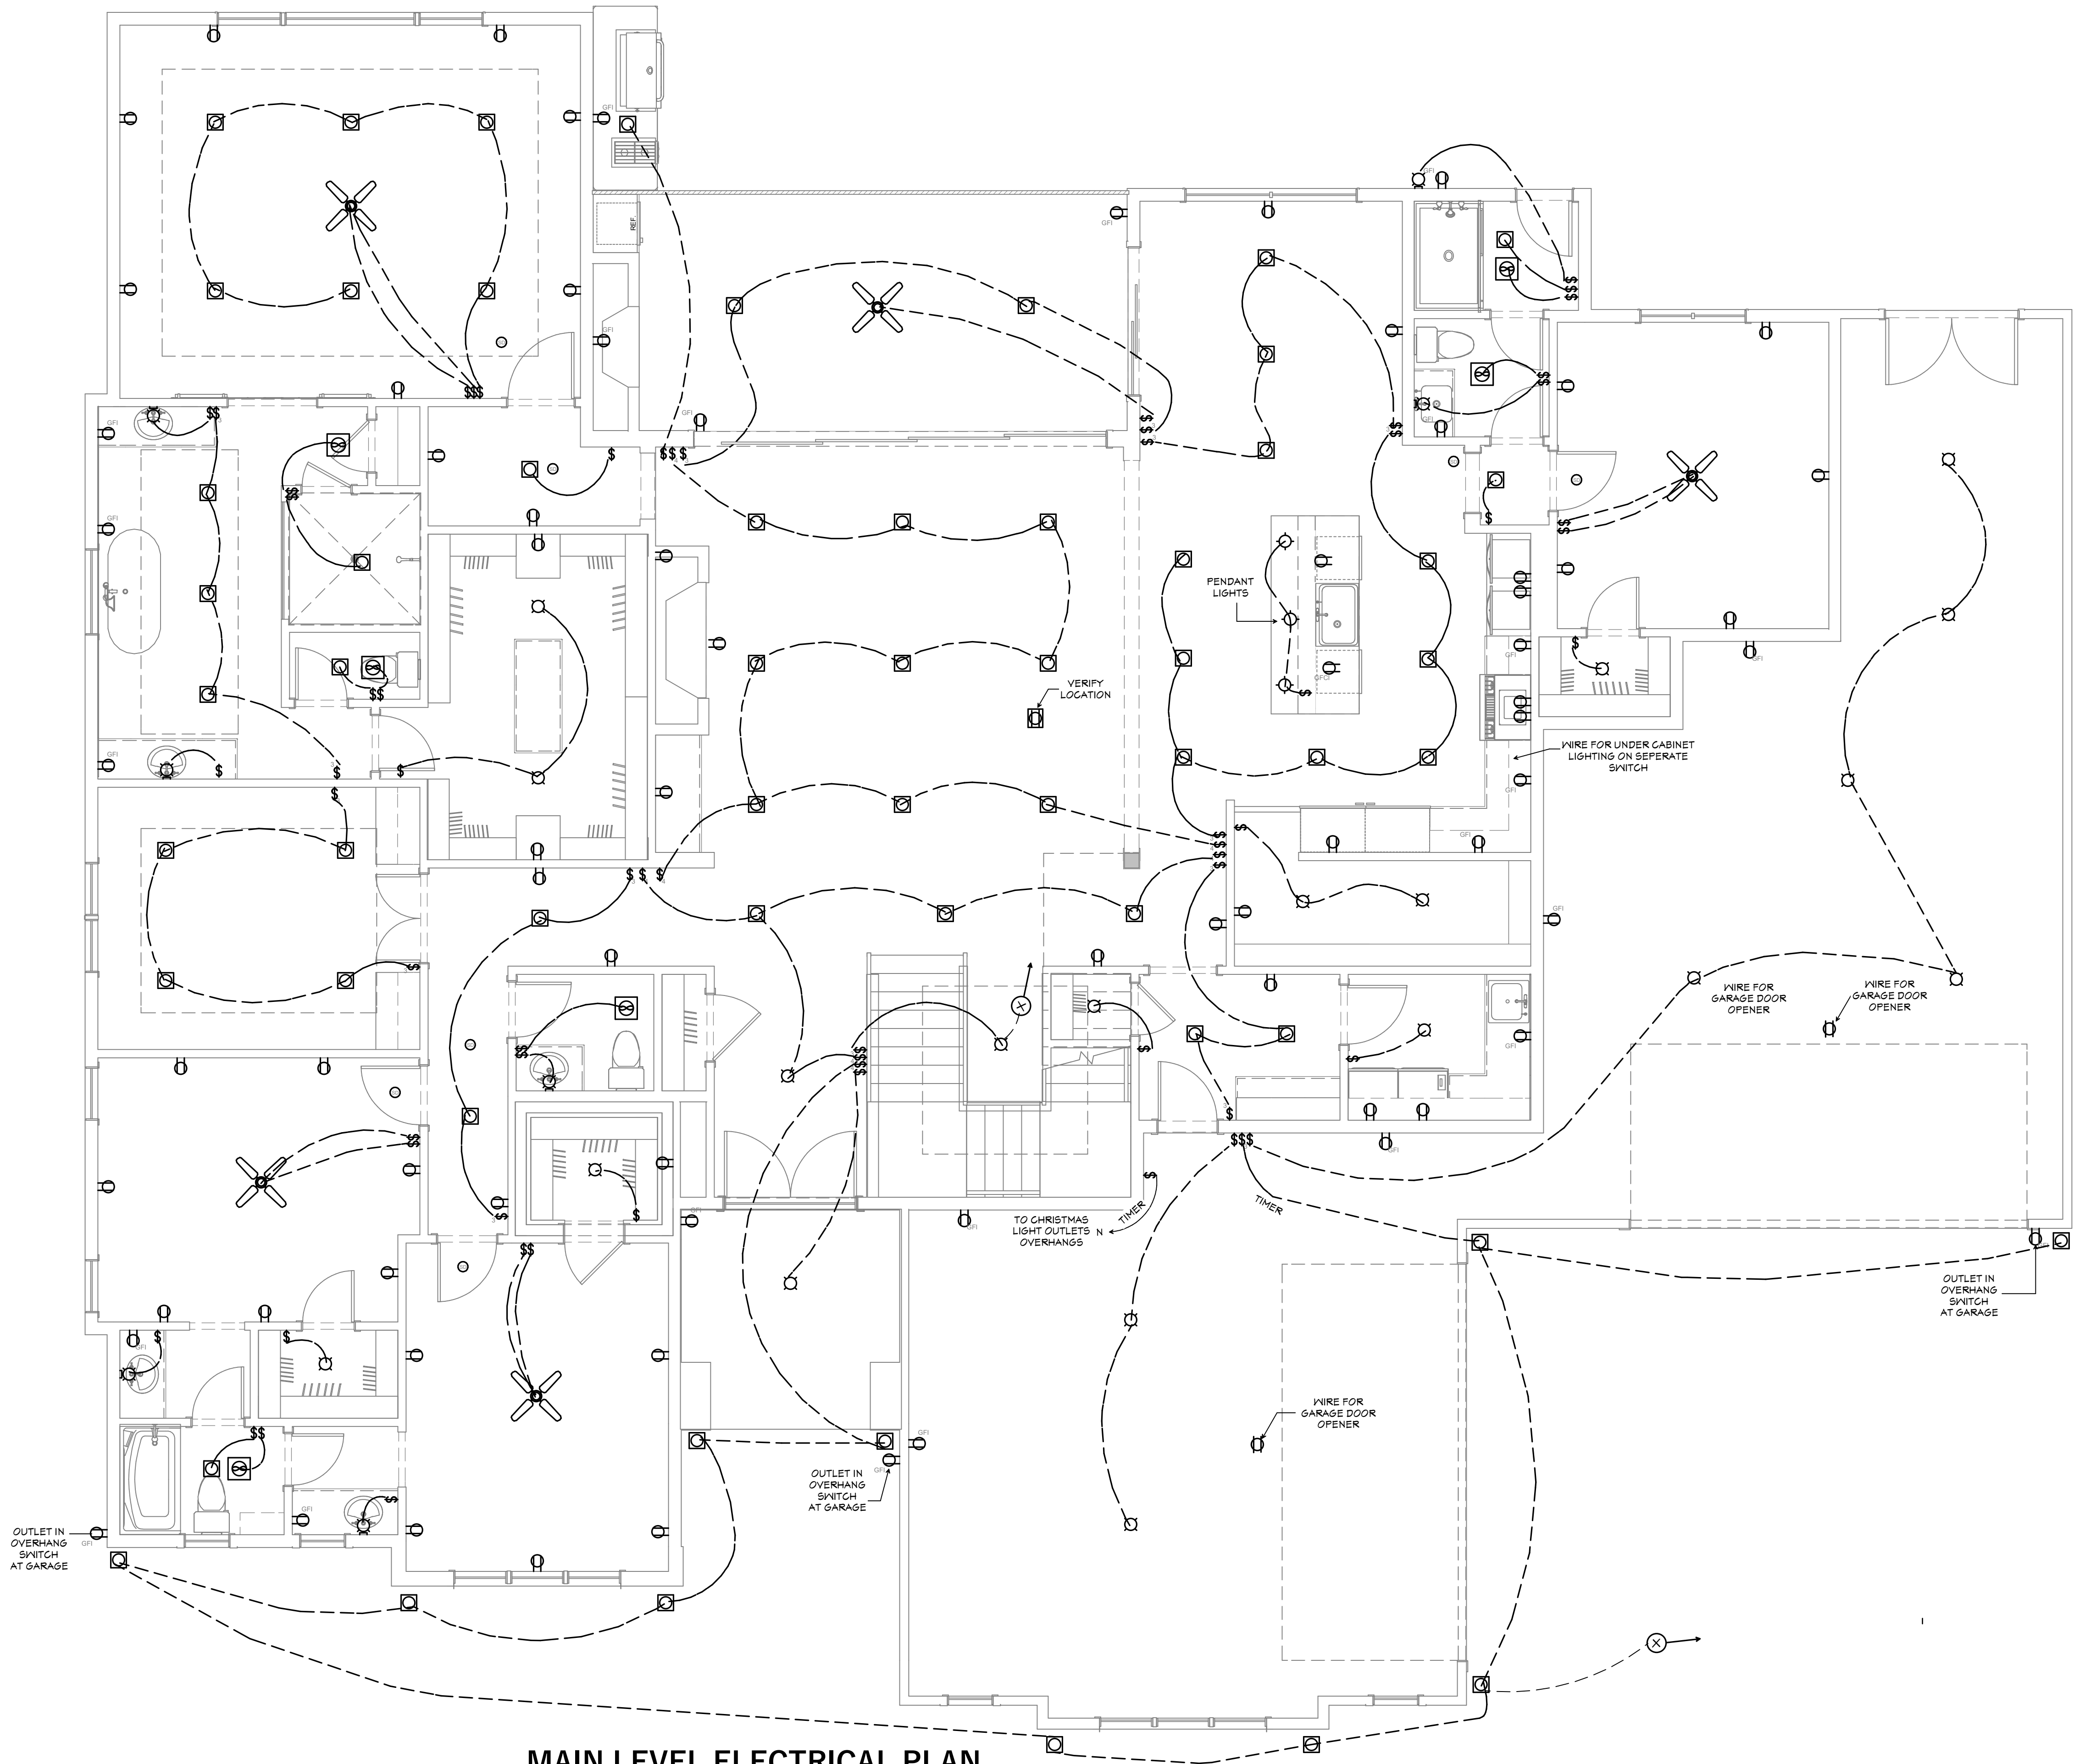

MAIN LEVEL ELECTRICAL PLAN
SCALE: 1/4" = 1"



These drawings are the property of VirtuActive, LLC. No part of these drawings may be reproduced, stored in a retrieval system, or transmitted in any form or by any means, electronic, mechanical, photocopying, recording, or by any information storage and retrieval system, without the prior written permission of VirtuActive, LLC. It is prohibited to use these drawings for any purpose other than the specific project identified herein. To the best of our knowledge these plans are drawn to comply with owner's requirements and specifications. Each individual contractor, subcontractor, and supplier is responsible for verifying all dimensions and included drawings. Each individual contractor, subcontractor, and supplier is responsible for verifying all dimensions and included drawings. VirtuActive, LLC will not be held responsible for negligence or the project due to lack of knowledge or skill. Size, spacing, and location of structural members, site availability, and dimensions shall be verified by the contractor, site conditions, supplier and/or representative.

REVISION TABLE		REVISION BY		DESCRIPTION	
NUMBER	DATE				

