



VICINITY MAP
NTS

FINLEY BUTTE RANCH
RESIDENTIAL SUBDIVISION
SEPTEMBER 2024
TAXLOT: 221014CD00100
CITY PROJECT NUMBER: 02SUB-24
CITY OF LA PINE, DESCHUTES COUNTY, OREGON

SCHEDULE OF PUBLIC IMPROVEMENTS:		
STREET ASPHALT:	118,974 SF	
SIDEWALK ASPHALT:	4,902 SF	
SIDEWALK CONCRETE:	39,556 SF	
ADA RAMPS:	25	
8" PVC 3034 SEWER MAIN:	3,234'	
SEWER CLEANOUTS:	31	
4" SEWER SERVICES:	89	
1000 GAL SEPTIC TANKS:	89	
10" C900 WATER MAIN:	622'	
10" GATE VALVES:	5	
10" BLOW OFFS:	1	
10" X 6" TEES:	2	
8" C900 WATER MAIN:	2,669'	
8" GATE VALVES:	12	
8" BLOW OFFS:	1	
8" X 6" TEE:	1	
6" GATE VALVES:	6	
FIRE HYDRANTS:	8	
1" WATER SERVICES:	89	
STREETLIGHTS:	6	

APPROVALS:

CITY OF LA PINE PUBLIC WORKS DIRECTOR:

OWNER:

EVANS PROPERTY HOLDINGS
17140 SHAWNEE CIRCLE
SUNRIVER, OR 97707

ENGINEER & SURVEYOR:

BECON CIVIL ENGINEERING & LAND SURVEYING
549 SW MILL VIEW WAY, SUITE 100
BEND, OREGON 97702

UTILITY PROVIDERS:

CITY OF LA PINE WATER
CITY OF LA PINE SEWER
MIDSTATE ELECTRIC COOPERATIVE
CASCADE NATURAL GAS
TDS
LUMEN


SHEET INDEX:

- C1.0 COVER SHEET
C1.1 CONSTRUCTION NOTES
C2.0 EXISTING CONDITIONS
C3.0 TENTATIVE SUBDIVISION PLAT
C4.0 - C4.8 ROAD IMPROVEMENTS
C5.0 DETAILS
C5.1 DETAILS

REVISIONS:	
1.	
2.	
3.	



FINLEY BUTTE RANCH
RESIDENTIAL SUBDIVISION
COVER SHEET
CITY OF LA PINE, DESCHUTES COUNTY, OREGON

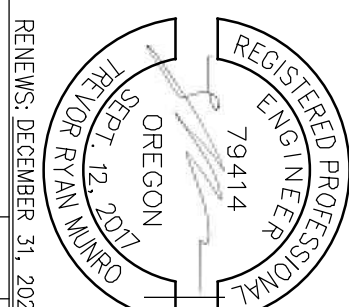

549 SW MILL VIEW WAY
SUITE 100
BEND, OREGON 97702
(541) 633-3140
www.beconeng.com

DESIGNED BY: TRM
DRAWN BY: SMA
SCALE: 1" = 100'
FILE: 24004
DATE: 09/10/2024

VERIFY SCALES
0 1"
BAR EQUALS ONE INCH
ON ORIGINAL DRAWING

SHEET:
C1.0

01 OF 15

PERMIT# 02SUB-24

	1	2	3	4	5	6	
CITY OF LA PINE NOTES							
GENERAL NOTES:		GENERAL NOTES (CONTINUED):		WATER NOTES:		SEWER NOTES:	
A	1. CONTRACTOR SHALL VERIFY THE LOCATION AND DEPTH OF ALL EXISTING UTILITIES WHICH MAY BE IN THE WORK AREA BEFORE CONSTRUCTION IS UNDERTAKEN. THE NEW UTILITIES SHALL BE INSTALLED TO AVOID CONFLICT WITH THE EXISTING UTILITIES.		12. ALL CONSTRUCTION WORK SHALL BE PERFORMED BY APPROVED CONTRACTORS.		1. EXISTING WATER LINE & SERVICES TO BE MAINTAINED UNTIL NEW SERVICES ARE COMPLETED. COORDINATE WITH THE LA PINE WATER DIST. ON THE NUMBER AND LOCATION OF EXISTING SERVICES. ABANDONED WATER SERVICES SHALL BE CUT AT THE WATER MAIN.		1. ALL WORK AND MATERIALS SHALL CONFORM WITH THE CORRESPONDING STANDARDS AND SPECIFICATIONS OF THE JURISDICTION, LATEST EDITION. CONTRACTOR SHALL MAINTAIN A CURRENT COPY OF STANDARDS AND SPECS ON SITE.
	2. CONTRACTOR TO OBTAIN ALL PERMITS.		13. HOT TAPS TO EXISTING SEWER OR WATER FACILITIES MUST BE COMPLETED BY A CONTRACTOR APPROVED BY THE LA PINE PUBLIC WORKS.		2. ALL WORK AND MATERIALS SHALL CONFORM WITH THE CORRESPONDING STANDARDS AND SPECIFICATIONS OF THE JURISDICTION, LATEST EDITION. CONTRACTOR SHALL MAINTAIN A CURRENT COPY OF STANDARDS AND SPECS ON SITE.		2. CLEAN OUTS SHALL BE 45° "WYE" WITH A 24" SPOOL, FOLLOWED BY A 45° BEND, ALL ENCASED IN 2000 PSI CONCRETE. A "BROOKS" VALVE BOX MARKED "SEWER" SHALL BE SET IN CONCRETE (OR A/C IN ROADWAY) OVER THE LID, AT GRADE. CLEANOUTS SHALL BE PROVIDED IN ALL DIRECTIONS FROM EVERY TEE AND CROSS TO THE MAIN LINE, AND WITHIN 5 FEET OF THE INTERSECTION.
B	3. ALL WORK AND MATERIALS SHALL CONFORM WITH THE ODOT/AMERICAN PUBLIC WORKS SPECIFICATIONS FOR CONSTRUCTION (2018).		14. ALL DRIVEWAY APPROACHES SHALL BE CONSTRUCTED IN ACCORDANCE WITH CITY STANDARD DRAWINGS AND SPECIFICATIONS.		3. A 10' MINIMUM SEPARATION FROM ANY OTHER UTILITY LINE SHALL BE MAINTAINED EXCEPTING CROSSINGS.		3. CONTRACTOR SHALL REFERENCE THE STANDARD DRAWINGS IN THE CITY OF LA PINE CONSTRUCTION STANDARDS, LATEST EDITION.
	4. ALL WORK AND MATERIALS SHALL CONFORM WITH THE CORRESPONDING STANDARDS AND SPECIFICATIONS OF THE JURISDICTION, LATEST EDITION. CONTRACTOR SHALL MAINTAIN A CURRENT COPY OF STANDARDS AND SPECS ON SITE.		15. TEN FOOT SEPARATION IS REQUIRED BETWEEN SEWER AND WATER SERVICES. NO UTILITIES SHALL BE PLACED WITHIN TEN FEET OF WATER MAINS OR SERVICES.		4. THRUST BLOCKS TO BE PROVIDED AT ALL TEES, PLUGS, CAPS, BENDS, AND AT ALL OTHER LOCATIONS WHERE UNBALANCED FORCES EXIST. CONCRETE TO BE POURED AGAINST UNDISTURBED EARTH.		4. ALL TESTING SHALL BE PERFORMED IN THE PRESENCE OF A REPRESENTATIVE OF THE LAPINE PUBLIC WORKS. PROCEDURES SHALL BE IN CONFORMANCE WITH CITY POLICIES.
C	5. CONTRACTOR TO PROVIDE TRAFFIC CONTROL PER THE MANUAL FOR UNIFORM TRAFFIC CONTROL DEVICES.		16. SEWER AND WATER SERVICES EXTENDED BEYOND PUBLIC RIGHT-OF-WAYS AND EASEMENTS SHALL BE INSPECTED BY THE COUNTY BUILDING DEPARTMENT.		5. DISINFECTION PROCEDURE FOR NEW WATER LINE TO BE PERFORMED IN COMPLIANCE WITH ADMINISTRATIVE RULES CHAPTER 333, LATEST EDITION AND LA PINE WATER DIST. STANDARDS AND SPECIFICATIONS.		5. ALL WORK SHALL BE PERFORMED BY DISTRICT APPROVED CONTRACTORS.
	6. ALL WORK SHALL BE DONE IN CONFORMANCE TO ALL APPLICABLE STATE & LOCAL PLUMBING CODES.		17. UTILITIES SHALL HAVE THE RIGHT TO INSTALL, MAINTAIN AND OPERATE THEIR EQUIPMENT ABOVE AND BELOW GROUND AND ALL OTHER RELATED FACILITIES WITHIN THE PUBLIC UTILITY EASEMENTS (PUE) IDENTIFIED ON THIS PLAN AS MAY BE NECESSARY OR DESIRABLE IN SERVING THE LOTS IDENTIFIED HEREIN, INCLUDING THE RIGHT OF ACCESS TO SUCH FACILITIES AND THE RIGHT TO REQUIRE THE REMOVAL OF ANY OBSTRUCTIONS INCLUDING TREES AND VEGETATION THAT MAY BE PLACED WITHIN THE PUE AT THE LOT OWNER'S EXPENSE. AT NO TIME MAY PERMANENT STRUCTURES BE PLACED WITHIN THE PUE OR ANY OTHER OBSTRUCTION WHICH INTERFERES WITH THE USE OF THE PUE WITHOUT THE PRIOR WRITTEN APPROVAL OF THE UTILITIES AND FACILITIES IN THE PUE.		6. INSPECTION REQUIRED: NO THRUST BLOCKS SHALL BE POURED AND NO PIPE SHALL BE BACKFILLED UNTIL PUBLIC WORKS HAS GIVEN APPROVAL.		6. TRENCH BACKFILL SHALL BE IN ACCORDANCE TO THE DESCHUTES COUNTY ROAD DEPARTMENT STANDARDS.
D	7. THE ENGINEER HAS NOT BEEN RETAINED OR COMPENSATED TO PROVIDE DESIGN AND CONSTRUCTION REVIEW SERVICES RELATING TO THE CONTRACTOR'S SAFETY PRECAUTIONS.		18. THE CONTRACTOR SHALL EXPOSE, VERIFY, AND/OR MATCH EXISTING UTILITIES AND IMPROVEMENTS, IN CONFORMANCE WITH THE INTENT OF THESE PLANS AND SPECIFICATIONS, TO PROVIDE COMPLETE AND OPERATIONAL SYSTEMS. ANY DISCREPANCIES AT PROPOSED CONNECTION POINTS SHALL BE REPORTED TO THE ENGINEER AND AFFECTED UTILITY PRIOR TO PROCEEDING WITH CONSTRUCTION.		7. CONTRACTOR SHALL REFERENCE THE STANDARD DRAWINGS IN THE LA PINE CONSTRUCTION STANDARDS, LATEST EDITION.		7. TWO INCH WARNING TAPE AND TONING WIRE SHALL BE PLACED WITHIN ONE FOOT OF ALL SEWER LINES.
	8. ONLY APPROVED CONTRACTORS TO PERFORM CONSTRUCTION IN THE PUBLIC RIGHT OF WAY.		19. DRY UTILITY TRENCHING SHALL BE COMPLETED IN CONFORMANCE WITH THE PLANS AND SPECIFICATIONS OF THE APPLICABLE UTILITY COMPANY. CONTRACTOR SHALL COORDINATE TRENCH EXCAVATION, BEDDING, BACKFILL, AND LOCATION OF TRENCH AND LOCATION OF RISERS, VAULTS, AND OTHER APPURTENANCES WITH THE APPROPRIATE UTILITY REPRESENTATIVE.		8. THE LA PINE PUBLIC WORKS REQUIRES THAT ALL WORK BE INSPECTED AND TESTED BY THE LA PINE PUBLIC WORKS OR REPRESENTATIVE THEREOF.		8. THE CONTRACTOR SHALL PROVIDE THE ENGINEER WITH ACCURATE AS-BUILT DRAWINGS SHOWING DISTANCES BETWEEN SERVICES, ALONG WITH ANY OTHER CHANGES TO THE APPROVED PLANS. THE DEVELOPER'S ENGINEER SHALL PROVIDE THE SEWER DISTRICT WITH MYLARS OR TRACINGS, AND TWO (2) SETS OF AS-BUILT PRINTS OF THE COMPLETED PROJECT. THE DEVELOPER'S ENGINEER SHALL PROVIDE AS-BUILTS IN DIGITAL FORM TO ALLOW THE WORK TO BE ADDED TO THE DISTRICT'S RECORDS.
BECON NOTES		CONSTRUCTION NOTES:		CONSTRUCTION NOTES (CONT):		REVISIONS:	
CITY OF LA PINE NOTES ON THIS SHEET TAKE PRECEDENCE		1. NO CONSTRUCTION SHALL BE STARTED WITHOUT A NOTICE TO PROCEED BY THE CITY ENGINEERING DEPARTMENT. THE CITY ENGINEERING DEPARTMENT AND THE DESIGN ENGINEER SHALL BE NOTIFIED AT LEAST 24 HOURS PRIOR TO THE START OF CONSTRUCTION. ANY CONSTRUCTION WORK DONE PRIOR TO NOTICE TO PROCEED BEING ISSUED OR WITHOUT INSPECTION WILL BE REJECTED.		9. ALL UNSUITABLE SOILS MATERIALS, RUBBISH AND DEBRIS RESULTING FROM GRADING OPERATIONS SHALL BE REMOVED FROM THE JOB SITE AND DISPOSED OF PROPERLY.		1. _____	
2. CONTRACTOR SHALL VERIFY ALL CONDITIONS ON THE JOB SITE INCLUDING BUT NOT LIMITED TO, ALL DIMENSIONS, GRADES, ELEVATIONS, EXTENT AND COMPATIBILITY TO THE EXISTING SITE CONDITIONS, AND WITH THE WORK DESCRIBED ON THE ENGINEER'S DRAWINGS. ANY DISCREPANCIES OR UNEXPECTED CONDITIONS THAT AFFECT OR CHANGE THE WORK DESCRIBED IN THE CONTRACT DOCUMENTS SHALL BE BROUGHT TO THE ENGINEER'S ATTENTION IMMEDIATELY. CONTRACTOR SHALL NOT PROCEED WITH ANY OF THE WORK IN THE AREA OF DISCREPANCIES UNTIL ALL SUCH DISCREPANCIES ARE RESOLVED. IF THE CONTRACTOR CHOOSES TO DO SO, THEN IT IS UNDERSTOOD THAT THE CONTRACTOR IS CHOOSING TO PROCEED AT THE CONTRACTOR'S OWN RISK AND SHALL INCUR ALL COSTS, IF ANY TO RESOLVE THE ISSUES TO THE SATISFACTION OF THE ENGINEER.		3. A CITY INSPECTOR ACTING ON BEHALF OF THE CITY MAY REQUIRE REVISIONS IN PLANS TO SOLVE UNFORESEEN PROBLEMS THAT MAY ARISE IN THE FIELD.		10. THE CONTRACTOR SHALL EMPLOY ALL LABOR, EQUIPMENT, AND METHODS REQUIRED TO PREVENT DUST IN AMOUNTS DAMAGING TO PROPERTY, CULTIVATED VEGETATION AND DOMESTIC ANIMALS OR CAUSING A NUISANCE TO PERSONS OCCUPYING BUILDINGS IN THE VICINITY OF THE JOB SITE. THE CONTRACTOR SHALL BE RESPONSIBLE FOR ANY DAMAGE CAUSED BY DUST RESULTING FROM CONSTRUCTION.		2. _____	
4. ALL CONSTRUCTION WORK AND INSTALLATIONS SHALL CONFORM TO THE CURRENT CITY PUBLIC WORKS STANDARDS & SPECIFICATIONS REQUIREMENTS, AND ALL WORK SHALL BE SUBJECT TO THE APPROVAL OF THE CITY.		5. IT SHALL BE THE RESPONSIBILITY OF THE CONTRACTOR TO CONTACT "UNDERGROUND LOCATE SERVICE" AT 1-800-332-2344 AT LEAST 48 BUSINESS-DAY HOURS PRIOR TO THE START OF CONSTRUCTION FOR THE LOCATION OF POWER, GAS, CABLE TV AND TELEPHONE UNDERGROUND FACILITIES. THE CONTRACTOR WILL ALSO BE RESPONSIBLE FOR CONTACTING THE APPROPRIATE PUBLIC AGENCY FOR THE LOCATION OF UNDERGROUND FACILITIES.		11. THE CONTRACTOR SHALL FOLLOW ALL APPLICABLE INDUSTRIAL SAFETY REGULATIONS. THE CITY AND DESCHUTES COUNTY AND THEIR OFFICIALS, THE ENGINEER, AND THE OWNER SHALL NOT BE RESPONSIBLE FOR ENFORCING SAFETY REGULATIONS.		3. _____	
6. ALL UTILITIES SHOWN ARE ACCURATE TO THE EXTENT OF AVAILABLE RECORDS AND KNOWLEDGE. NO POTHOLING TO VERIFY LOCATIONS AND ELEVATIONS WAS AUTHORIZED BY THE OWNER. THE CONTRACTOR HAS THE TOTAL RESPONSIBILITY TO VERIFY THE LOCATION OF EXISTING UNDERGROUND UTILITIES AND TO NOTIFY THE UTILITY COMPANIES WHEN WORKING IN THEIR PROXIMITY. CONTRACTOR TO VERIFY LOCATION OF EXISTING UTILITIES PRIOR TO CONSTRUCTION. OREGON LAW REQUIRES YOU TO FOLLOW RULES ADOPTED BY THE OREGON UTILITY NOTIFICATION CENTER. THOSE RULES ARE SET FORTH IN OAR 952-001-0010 THROUGH 952-001-0090. YOU MAY OBTAIN COPIES OF THE RULES BY CALLING THE CENTER. THE TELEPHONE NUMBER FOR THE OREGON UTILITY NOTIFICATION CENTER IS (503)232-2987.		7. ALL GRADING SHALL BE IN CONFORMANCE WITH THE CURRENT CITY STANDARDS AND SPECIFICATIONS AND CURRENT GRADING ORDINANCE. ALL SUBGRADE MATERIAL SHALL BE CONSIDERED CLASS A AND COMPACTED TO 95% OF OPTIMUM DENSITY. AS SPECIFIED IN THESE PLANS. ALL FILL MATERIAL SHALL BE COMPACTED TO 95% RELATIVE COMPACTION PER THE CITY TESTING REQUIREMENTS.		12. MATERIAL QUANTITIES USED, NOTED, OR PROVIDED IN A SEPARATE ITEMIZED QUANTITY TAKE-OFF ARE AN ENGINEER'S OPINION OF PROBABLE MATERIAL REQUIREMENTS, AND IS AN ESTIMATE ONLY. CONTRACTOR'S HAVE THE SOLE RESPONSIBILITY OF MAKING THEIR OWN QUANTITY TAKE-OFF AND COST ESTIMATE.		_____	
8. ALL FINAL CUT SLOPES SHALL NOT EXCEED A GRADE OF 2 TO 1 VERTICAL UNLESS OTHERWISE APPROVED. FILL SLOPES SHALL NOT EXCEED A GRADE OF 2 HORIZONTAL TO 1 VERTICAL UNLESS OTHERWISE APPROVED BY THE ENGINEER.		ALL CONSTRUCTION WORK AND INSTALLATIONS SHALL CONFORM TO THE CURRENT CITY PUBLIC WORKS STANDARDS & SPECIFICATIONS REQUIREMENTS, AND ALL WORK SHALL BE SUBJECT TO THE APPROVAL OF THE CITY.		13. ALL WORK SHALL BE PERFORMED BY A CITY APPROVED CONTRACTOR.		_____	
				14. UTILITIES SHALL HAVE THE RIGHT TO INSTALL, MAINTAIN, AND OPERATE THEIR EQUIPMENT ABOVE AND BELOW GROUND AND ALL OTHER RELATED FACILITIES WITHIN THE PUBLIC UTILITY EASEMENTS (PUE) IDENTIFIED ON THIS PLAT MAP AS MAY BE NECESSARY OR DESIRABLE IN SERVING THE LOTS IDENTIFIED HEREIN, INCLUDING THE RIGHT OF ACCESS TO SUCH FACILITIES AND THE RIGHT TO REQUIRE THE REMOVAL OF ANY OBSTRUCTIONS INCLUDING TREES AND VEGETATION THAT MAY BE PLACED WITH IN THE PUE AT THE LOT OWNERS EXPENSE. AT NO TIME MAY ANY PERMANENT STRUCTURES BE PLACED WITHIN THE PUE OR ANY OTHER OBSTRUCTION WHICH INTERFERES WITH THE USE OF THE PUE WITHOUT PRIOR WRITTEN APPROVAL OF THE UTILITIES AND FACILITIES IN THE PUE.		DESIGNED BY: TRM DRAWN BY: SMA SCALE: NTS FILE: 24004 DATE: 09/10/2024	
				15. CITY ENGINEER'S SIGNATURE DOES NOT CONSTITUTE APPROVAL OF FACILITIES PROPOSED ON PRIVATE PROPERTY. SEPARATE PERMITS ISSUED BY THE BUILDING DEPARTMENT ARE REQUIRED AND SHALL BE OBTAINED BY THE DEVELOPER FOR FACILITIES LOCATED OUTSIDE OF THE PUBLIC RIGHT-OF-WAY.		VERIFICATION SCALES 0 1" BAR EQUALS ONE INCH ON ORIGINAL DRAWING	
				16. ANY WORK WITHIN EXISTING PUBLIC RIGHT-OF-WAY OR DEDICATED CITY EASEMENTS REQUIRES A SEPARATE RIGHT-OF-WAY EXCAVATION PERMIT OBTAINED FROM THE CITY ENGINEERING DIVISION.		SHEET: C1.1	
				17. ACCESS TO EXISTING PROPERTIES/RESIDENTS AFFECTED BY CONSTRUCTION ACTIVITIES WILL BE MAINTAINED AT ALL TIMES BY THE CONTRACTOR. EMERGENCY ACCESS AND COORDINATION OF EMERGENCY SERVICES WILL BE REQUIRED.		02 OF 15	
				18. SURVEY MONUMENTS, CONTROLS, OR PROPERTY CORNERS WHICH ARE DISTURBED OR DESTROYED BY CONSTRUCTION ACTIVITIES WILL BE RE-ESTABLISHED, RESTORED, AND/OR REPLACED AT THE CONTRACTOR'S EXPENSE.		PERMIT# 02SUB-24	
				19. ALL NECESSARY CHANGES TO DESIGN PLANS, REVEALED DURING CONSTRUCTION, MUST BE APPROVED BY THE DESIGN ENGINEER AND THE CITY.		ENGINEERING SET	
1		2		3		4	



RENEWS: DECEMBER 31, 2024

FINLEY BUTTE RANCH
RESIDENTIAL SUBDIVISION
CONSTRUCTION NOTES
CITY OF LA PINE, DESCHUTES COUNTY, OREGON



REVISIONS:	1.	2.	3.




DESIGNED BY: TRM	VERIFIED BY: SMA
DRAWN BY: NTS	SCALE: 24004
FILE: 24004	DATE: 09/10/2024

0 1" BAR EQUALS ONE INCH ON ORIGINAL DRAWING

SHEET: C1.1
02 OF 15
PERMIT# 02SUB-24



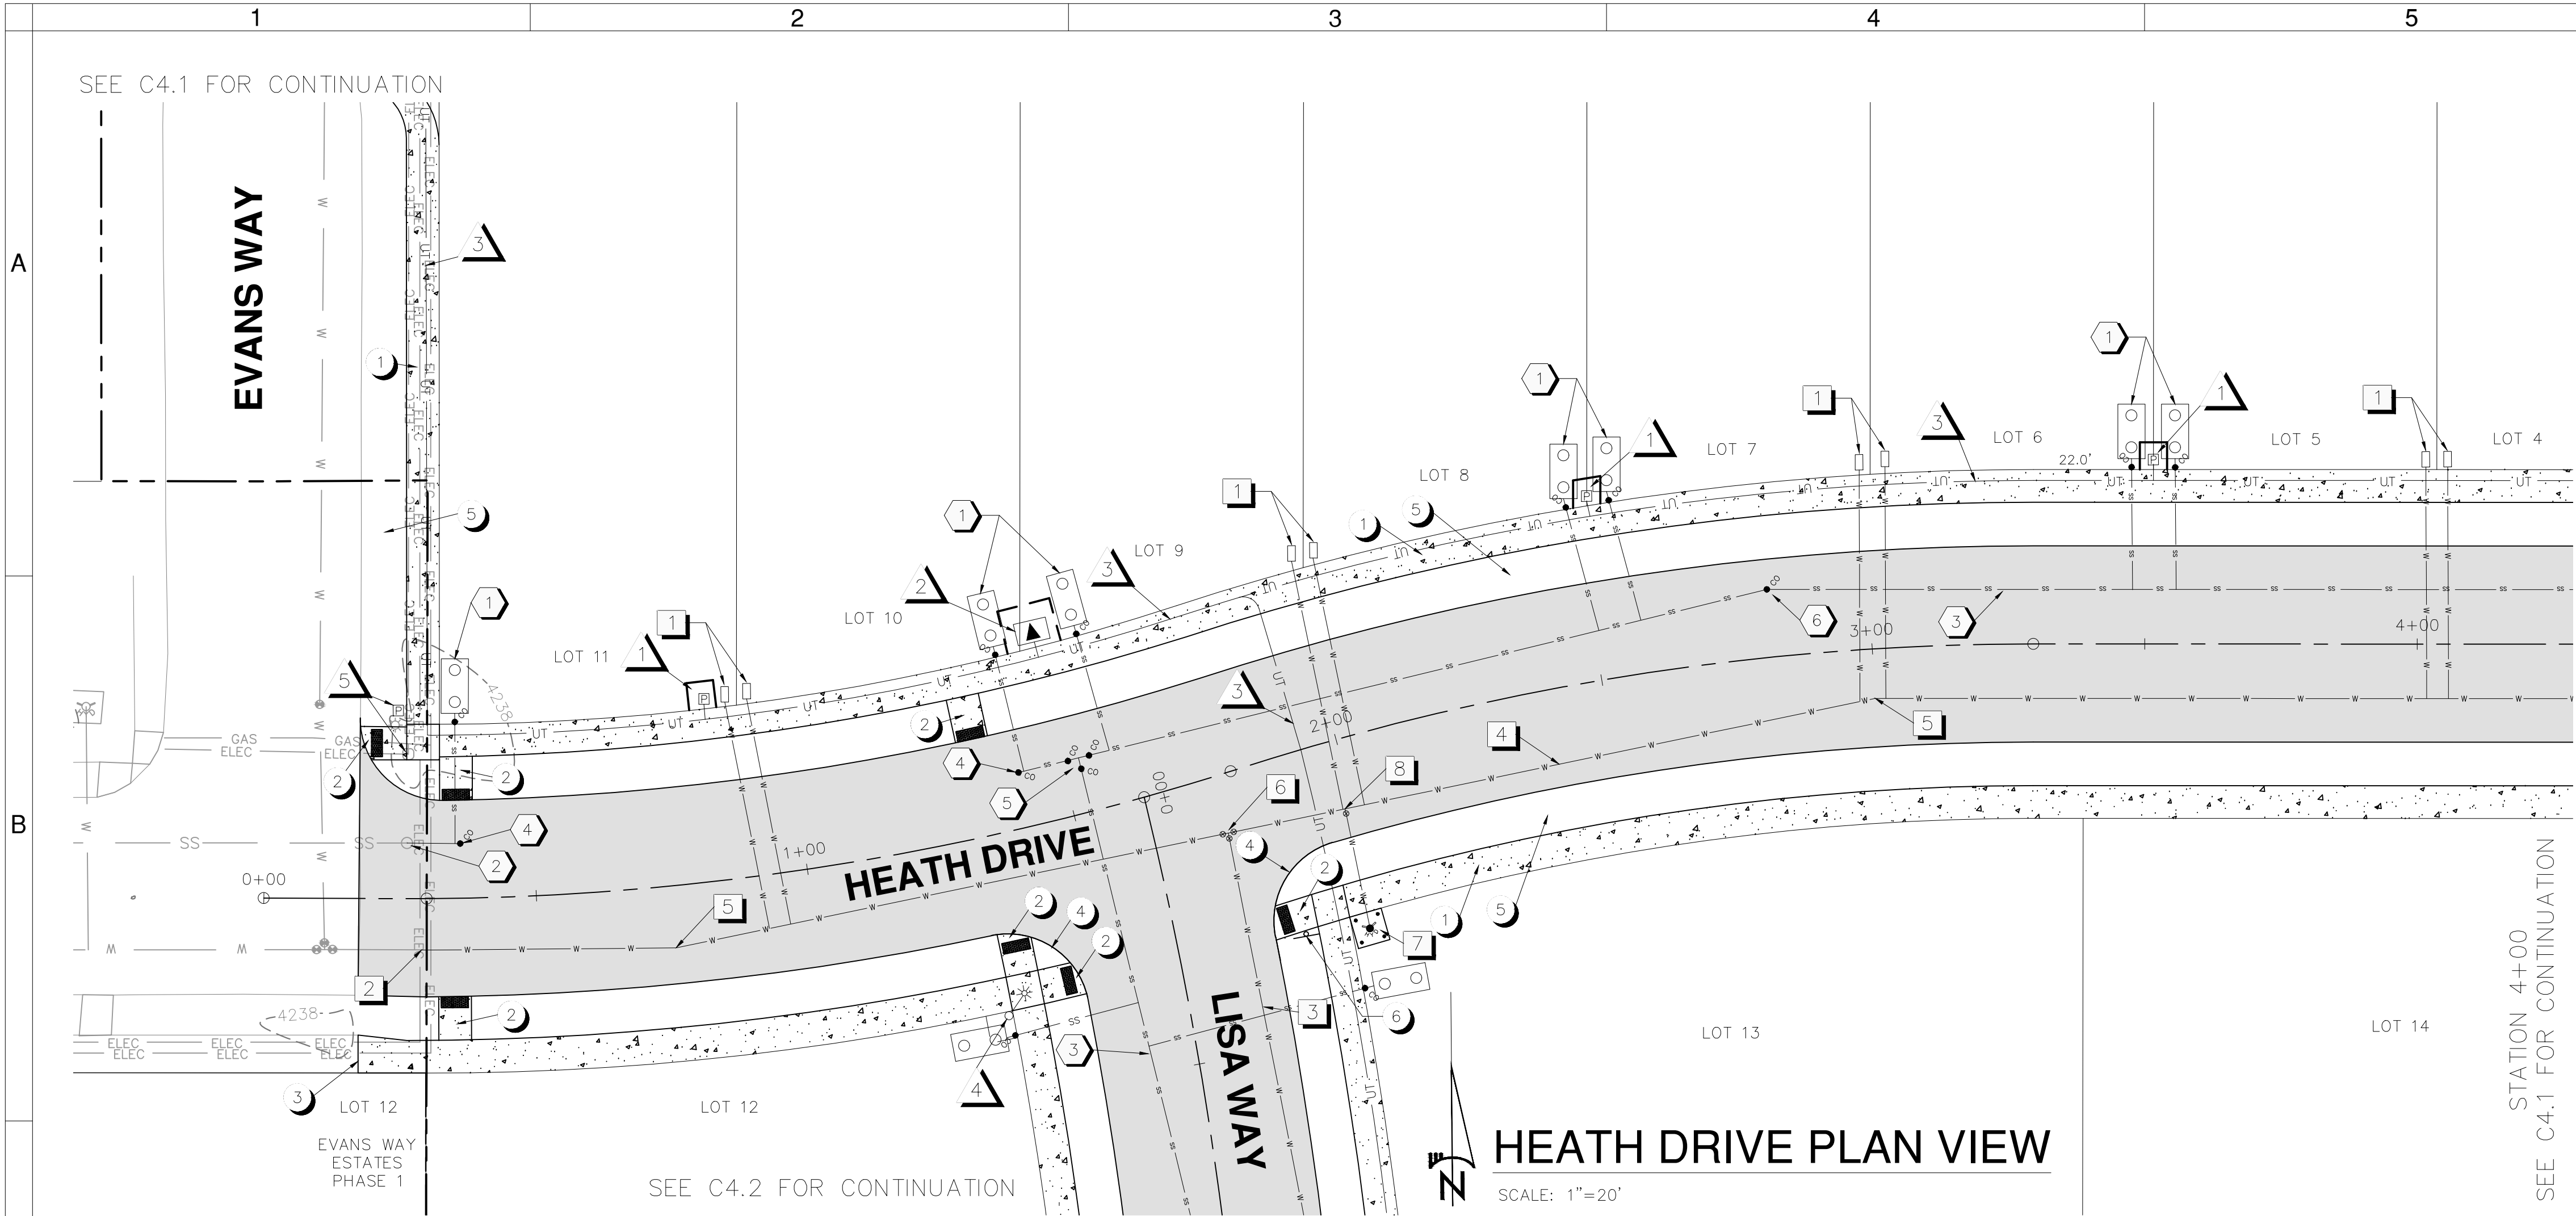

SITE NOTES

- 1 CONCRETE SIDEWALK PER DETAILS SHEETS
- 2 ADA RAMP TO BE CONSTRUCTED
- 3 MATCH GRADE - BEGIN SIDEWALK
- 4 15' RADIUS
- 5 DRAINAGE SWALE
- 6 STOP SIGN WITH ROAD NAMES PER CITY STANDARDS

WATER NOTES


- 1 1" WATER SERVICE PER CITY STANDARDS
- 2 REMOVE BLOW OFF AND CONNECT TO EXISTING 10" WATER MAIN
- 3 8" C900 WATER MAIN PER CITY STANDARDS
- 4 10" C900 WATER MAIN PER CITY STANDARDS
- 5 10" 11.25' BEND
- 6 10" X 8" TEE WITH GATE VALVES
- 7 FIRE HYDRANT WITH PAD AND BOLLARDS PER CITY STANDARDS
- 8 10" X 6" TEE WITH GATE VALVE

SEWER NOTES


- 1 4" SEWER SERVICE PER CITY STANDARDS, 1000 GAL SEPTIC TANK TO BE INSTALLED.
- 2 REMOVE CLEANOUT AND CONNECT TO EXISTING SEWER MAIN
- 3 8" PVC SEWER MAIN PER CITY STANDARDS
- 4 SEWER CLEANOUT
- 5 TEE WITH CLEANOUTS
- 6 11.25' BEND WITH CLEANOUT

FRANCHISE UTILITY NOTES

- 1 POWER SERVICE PEDESTAL PER MIDSTATE
- 2 644 TRANSFORMER VAULT PER MIDSTATE
- 3 JOINT UTILITY TRENCH, REFER TO MIDSTATE POWER PLAN AND GAS AND TELCO UTILITY PLANS.
- 4 LIGHT POLE PER MIDSTATE.
- 5 RELOCATE EXISTING POWER SERVICE PEDESTAL

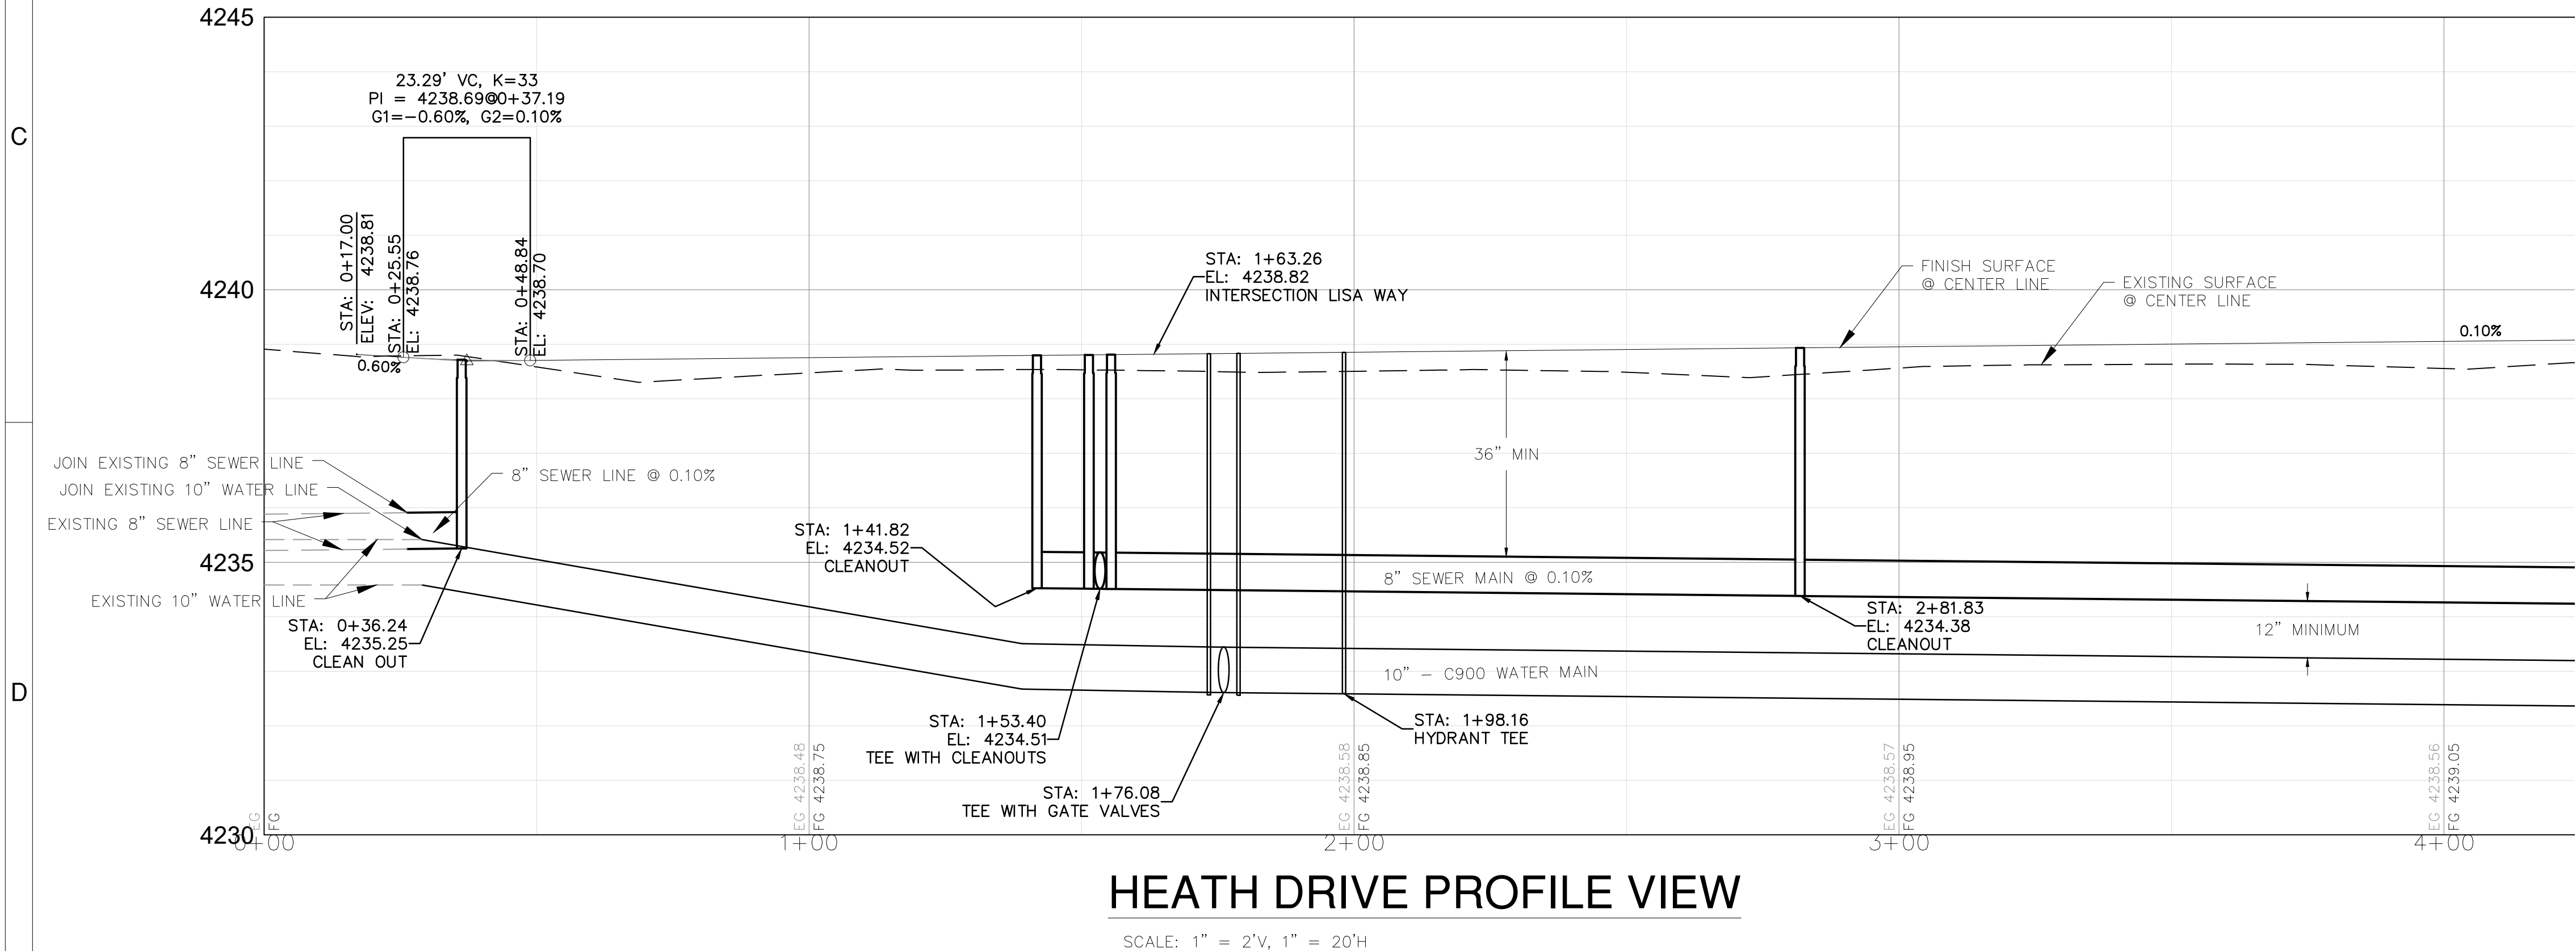

KEY MAP

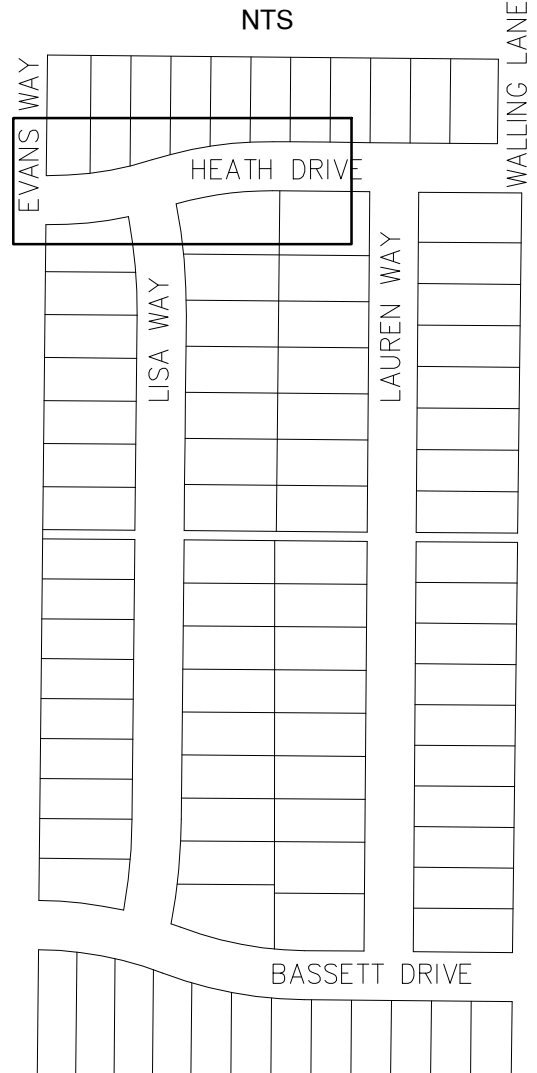

ENGINEERING SET



FINLEY BUTTE RANCH
RESIDENTIAL SUBDIVISION
ROAD IMPROVEMENTS - HEATH DRIVE
CITY OF LA PINE, DESCHUTES COUNTY, OREGON



REVISIONS:

1. 2. 3.

549 SW MILL VIEW WAY
SUITE 100
BEND, OREGON 97702
(541) 633-3140
www.beconeng.com


DESIGNED BY: TRM
DRAWN BY: SMA
SCALE: 1"=20'
FILE: 24004
DATE: 09/10/2024

VERIFY SCALES
0 1"
BAR EQUALS ONE INCH
ON ORIGINAL DRAWING


SHEET: C4.0

05 OF 15


PERMIT# 02SUB-24

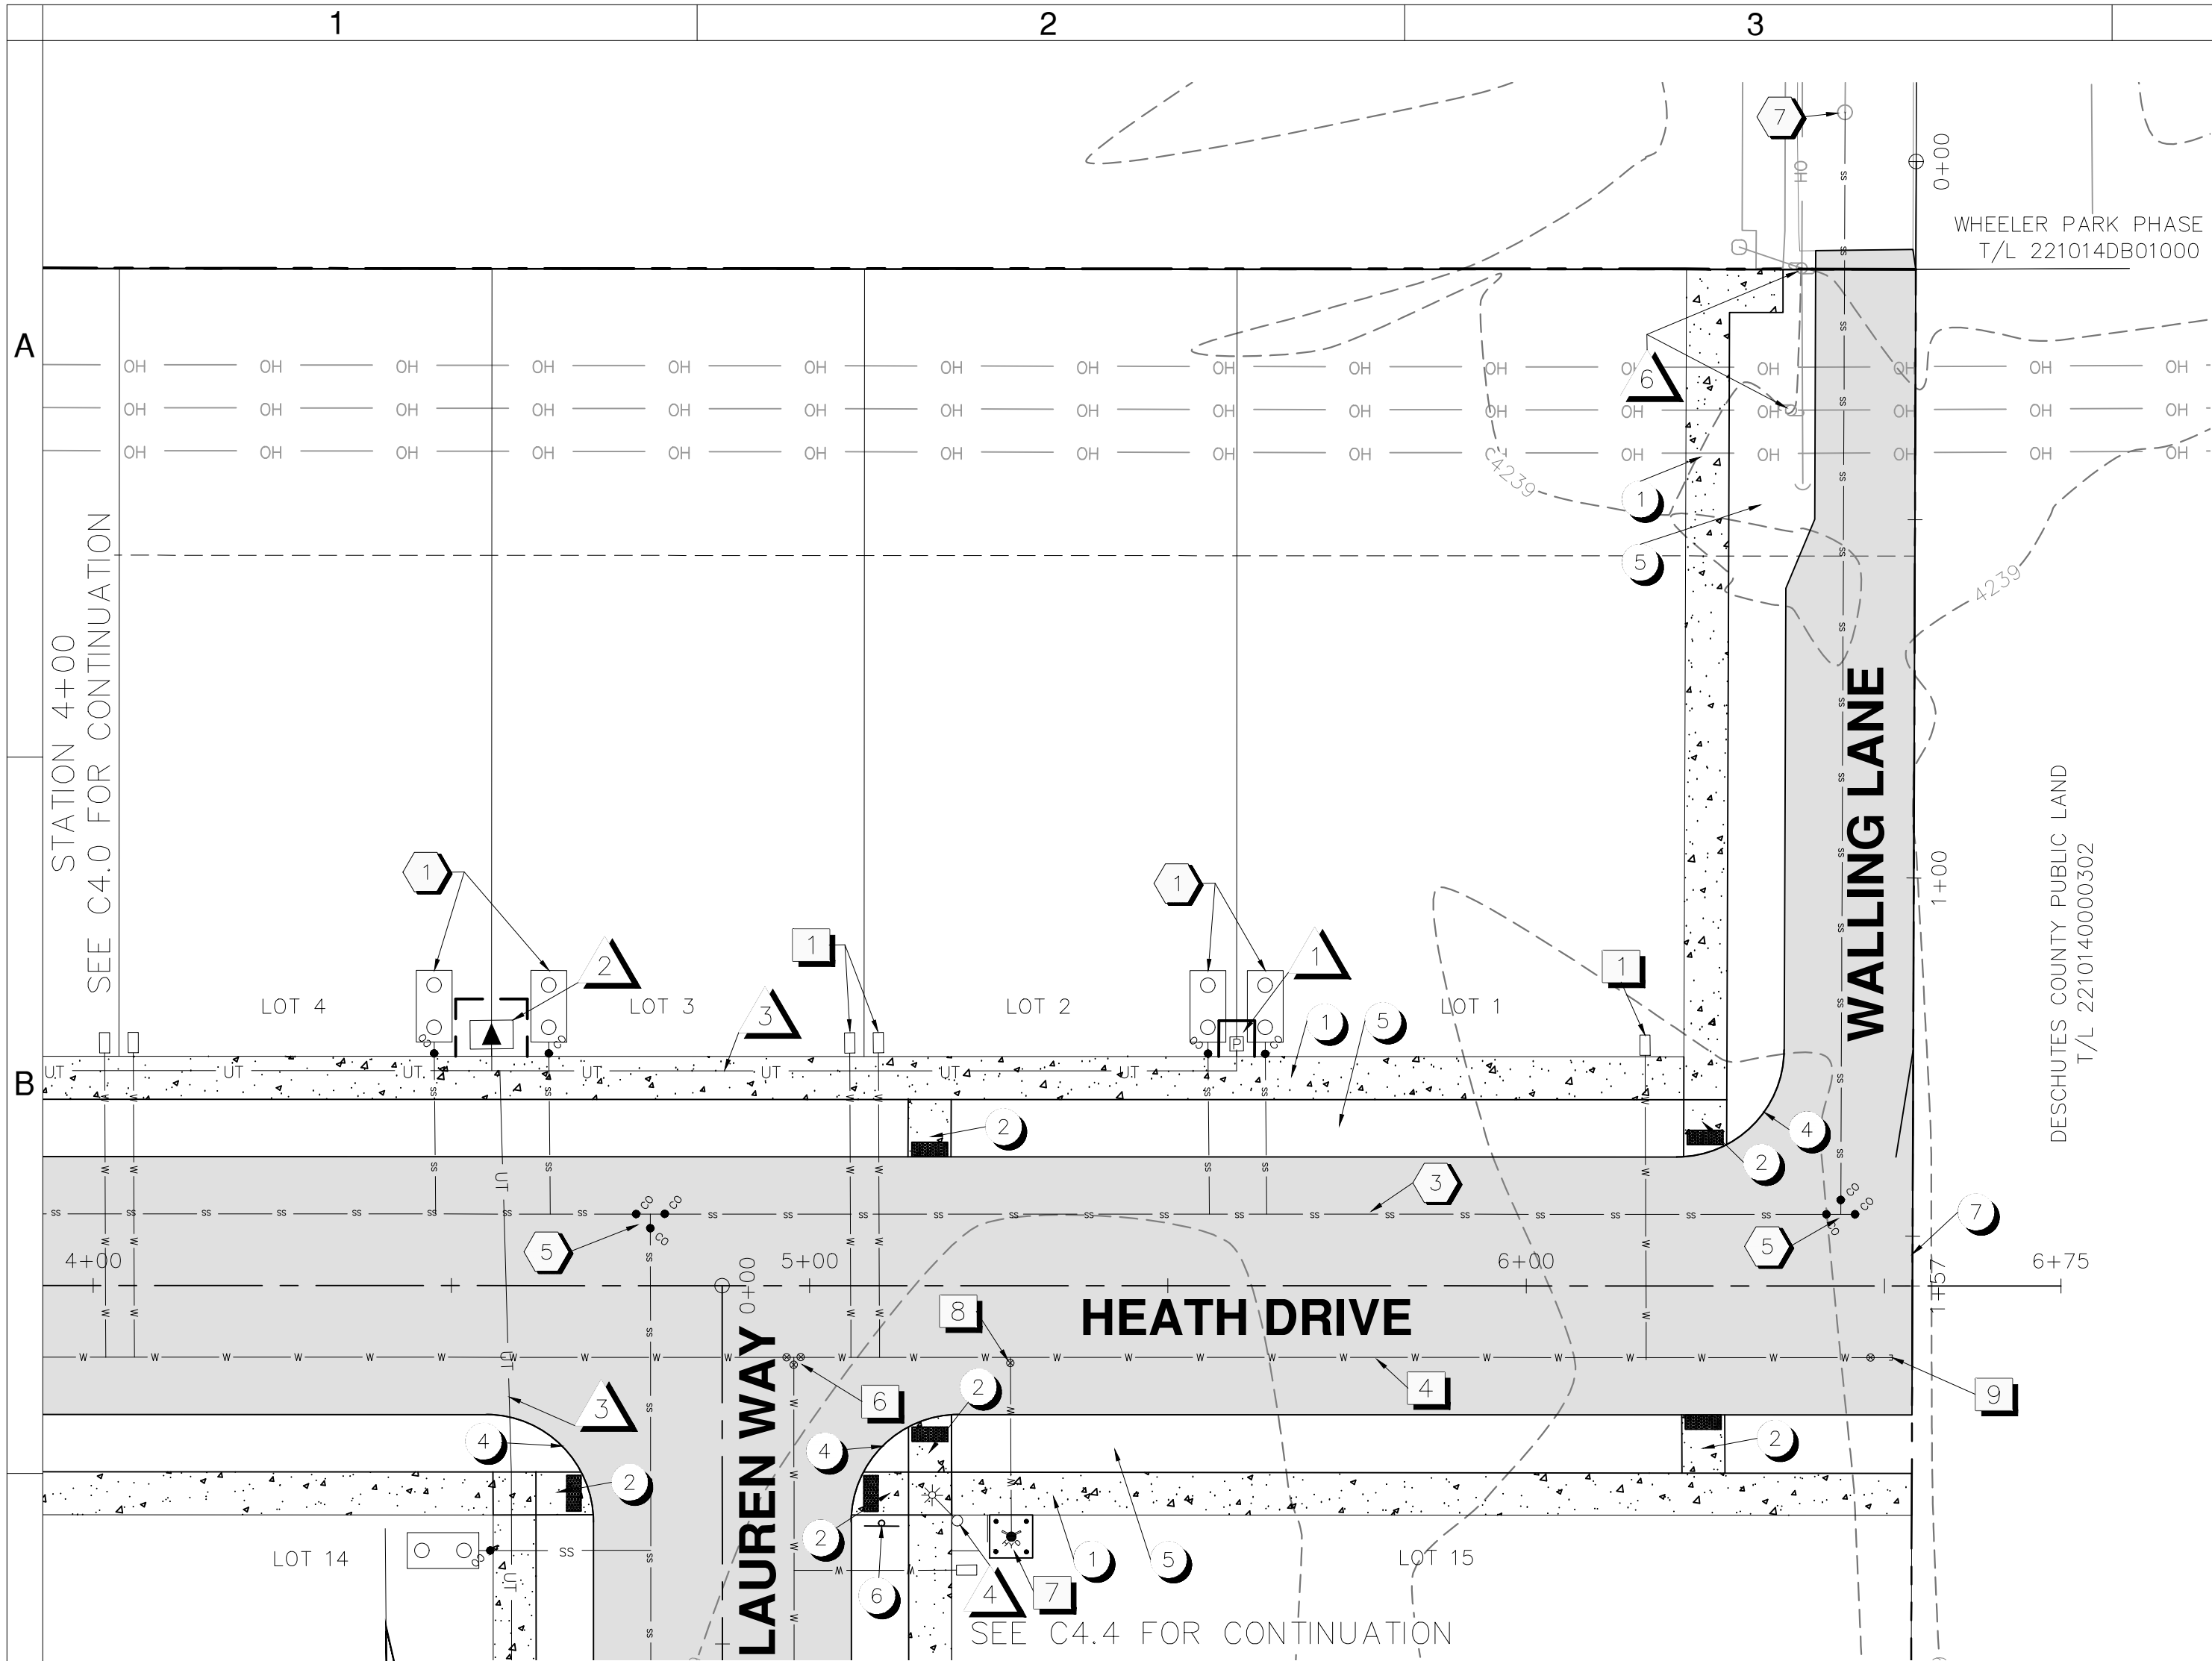

HEATH DRIVE & WALLING LANE PLAN VIEW
SCALE: 1"=20'

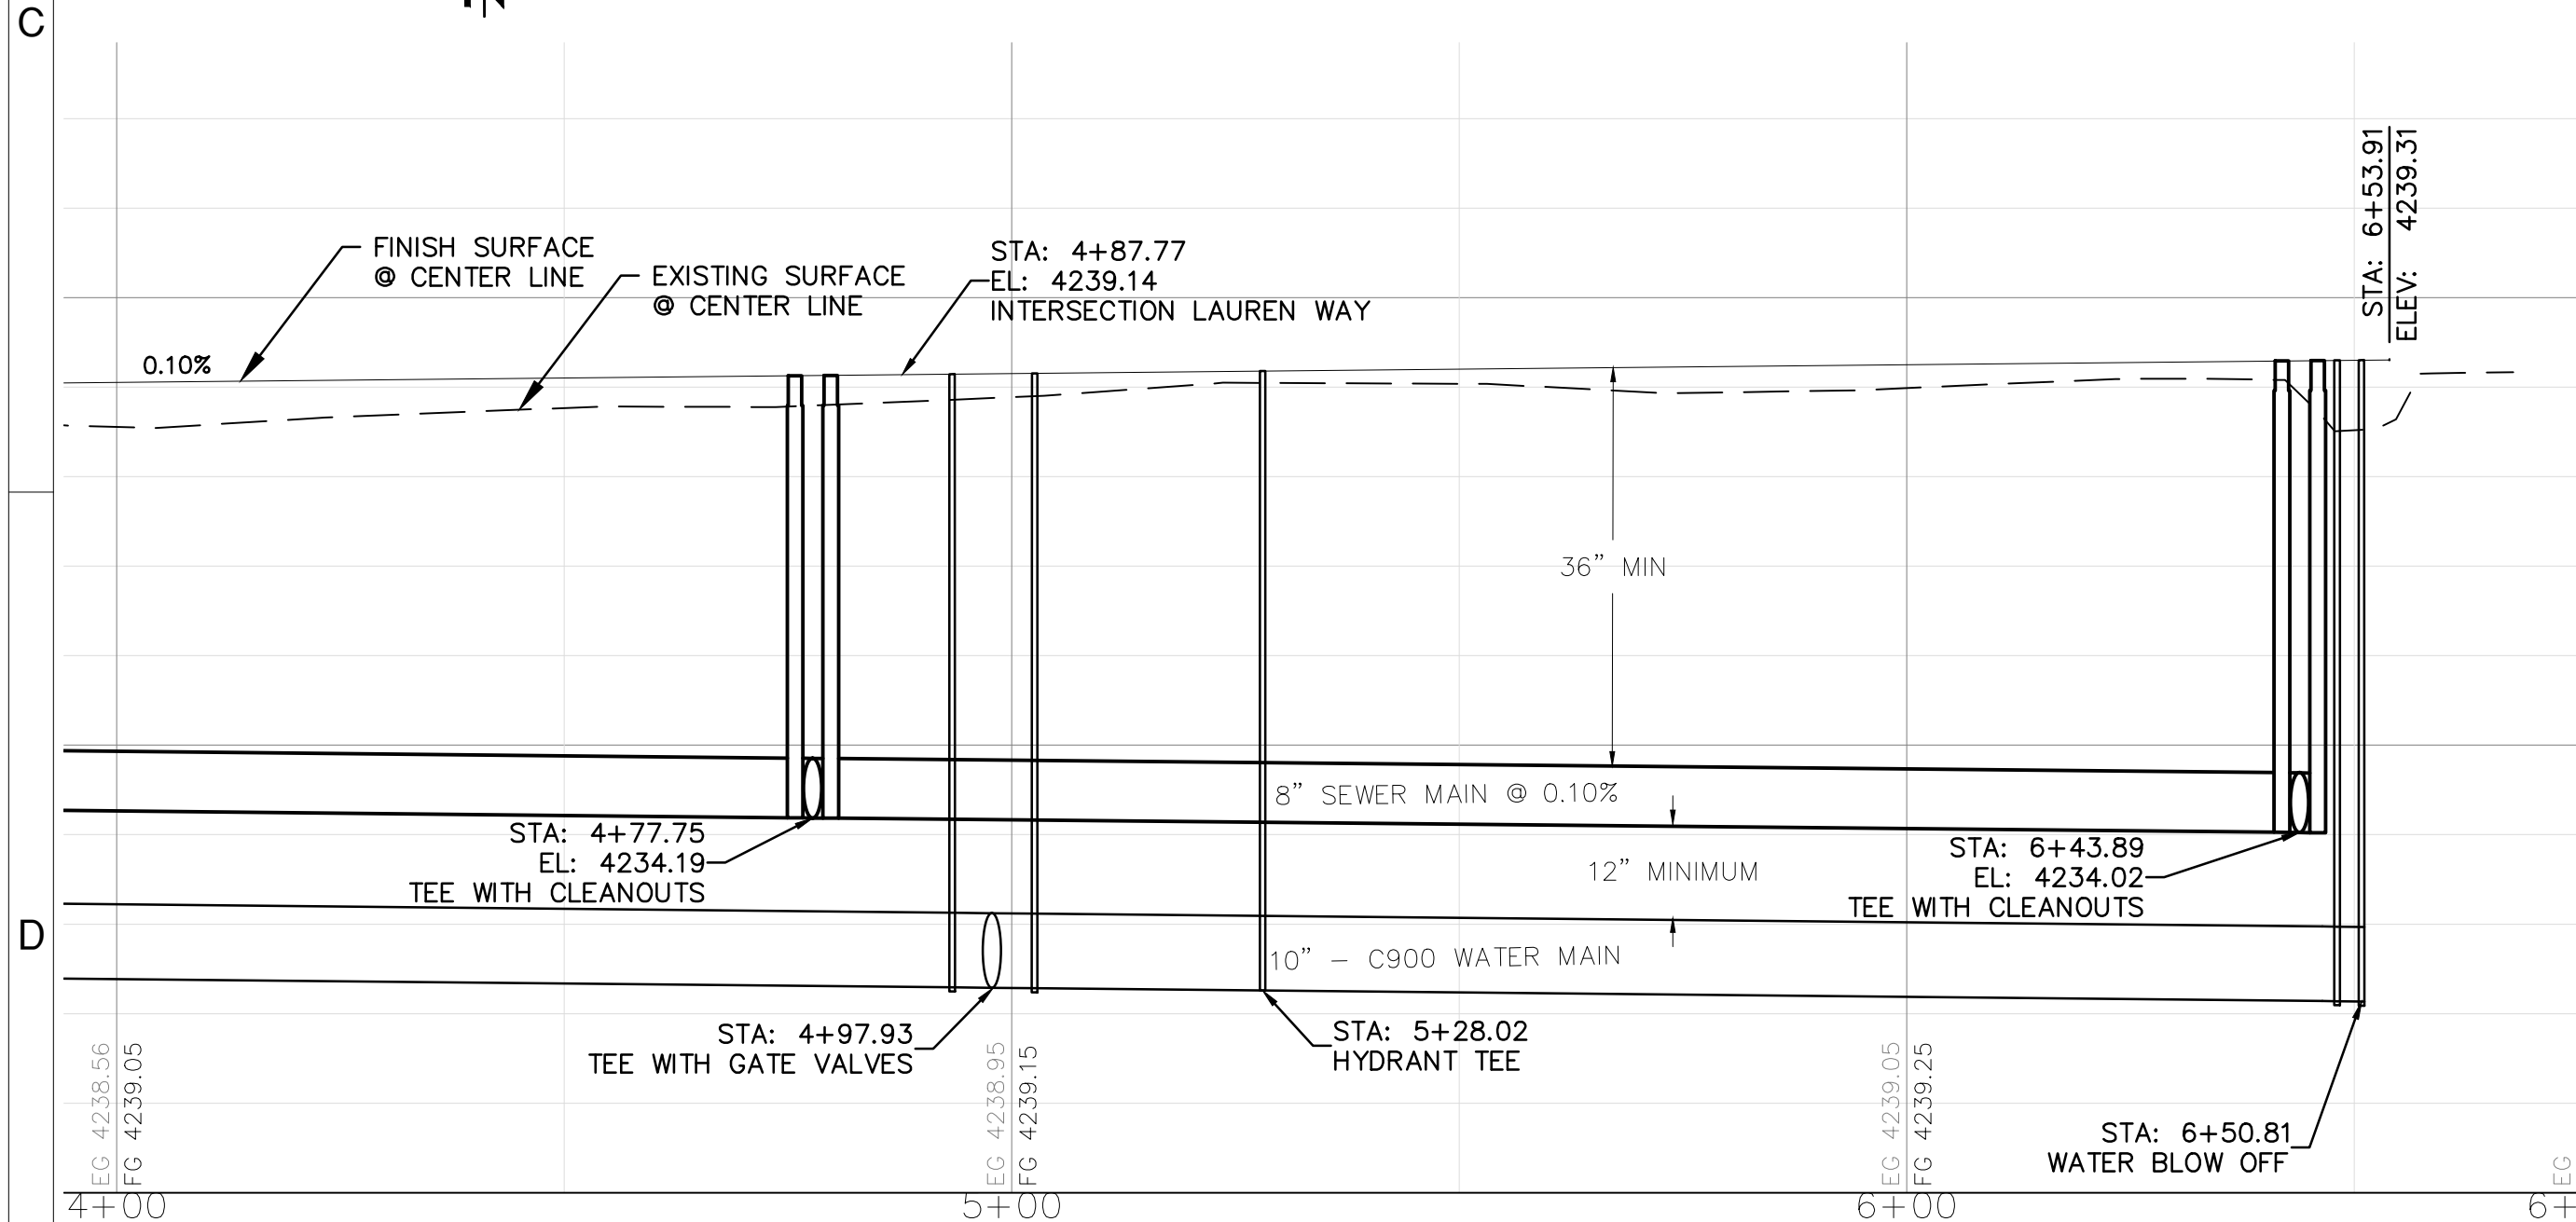

HEATH DRIVE PROFILE VIEW
SCALE: 1" = 2'V, 1" = 20'H

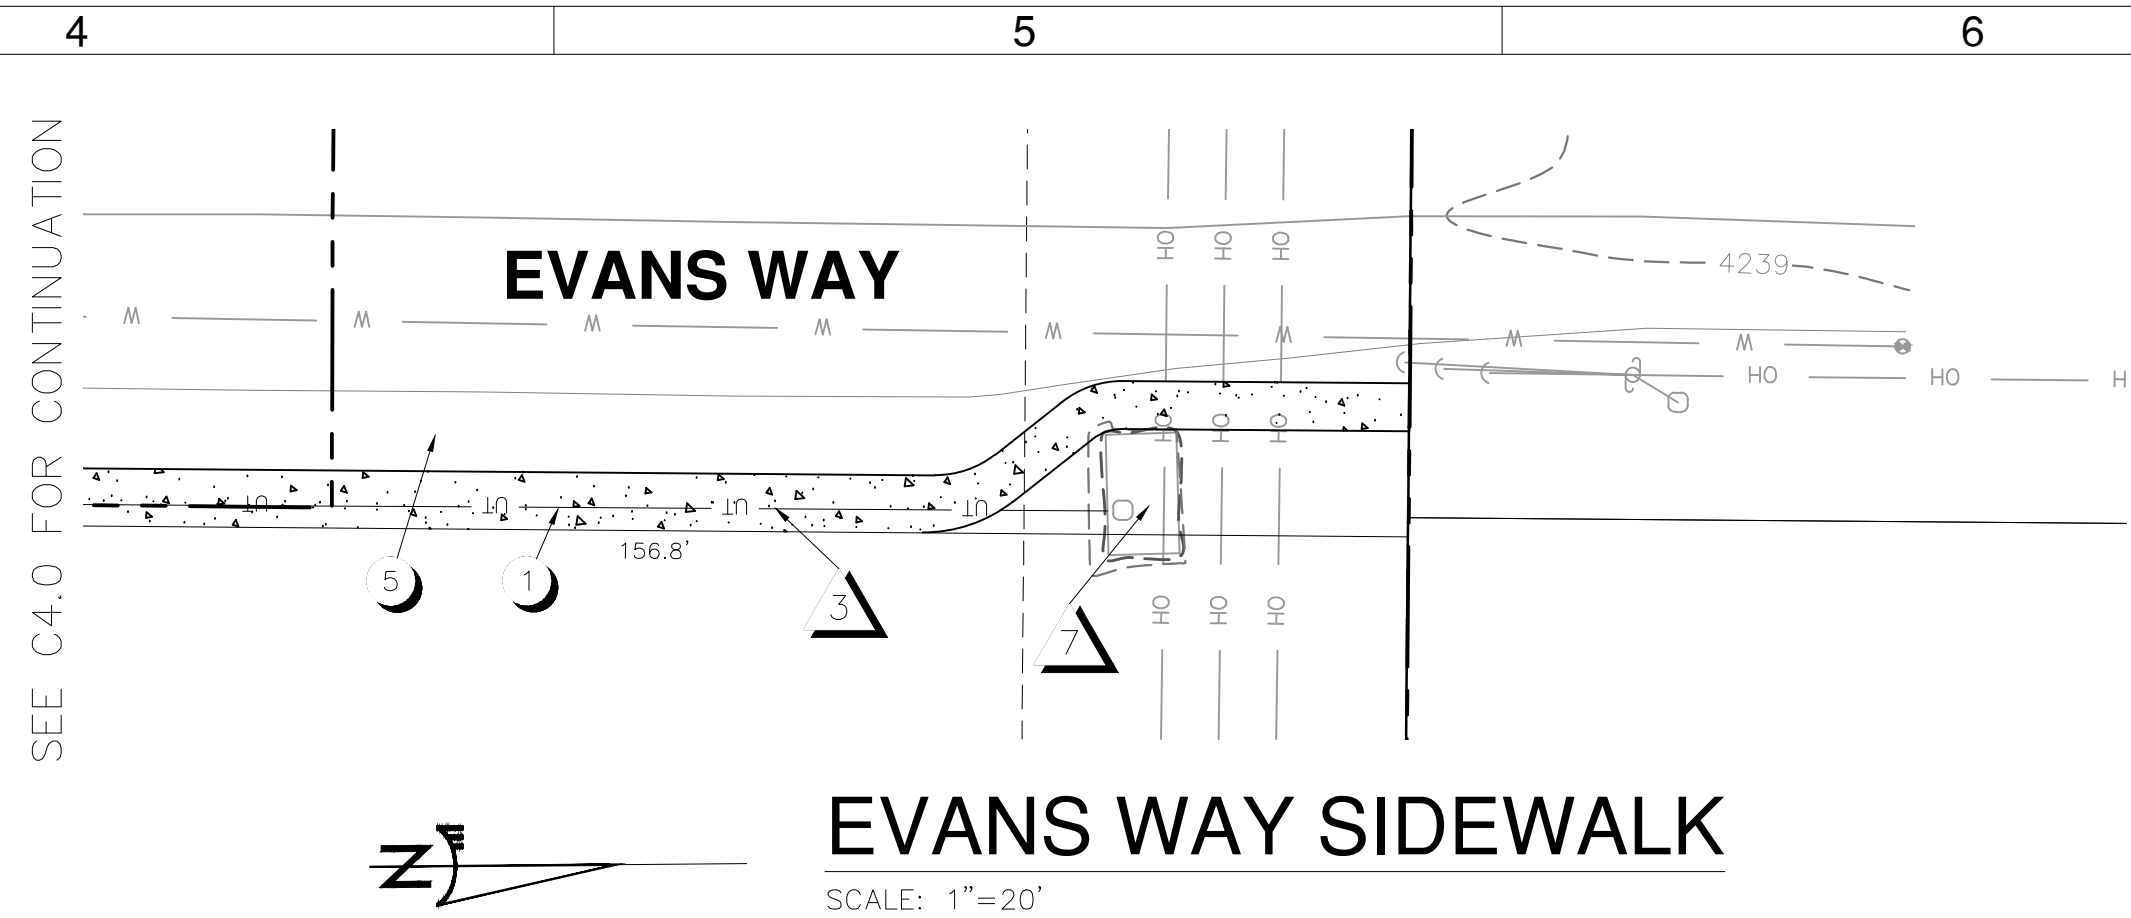

EVANS WAY SIDEWALK
SCALE: 1"=20'

SITE NOTES

- 1 CONCRETE SIDEWALK PER DETAILS SHEETS
- 2 ADA RAMP TO BE CONSTRUCTED
- 4 15' RADIUS
- 5 DRAINAGE SWALE
- 6 STOP SIGN WITH ROAD NAMES PER CITY STANDARDS
- 7 INSTALL TYPE III BARRICADE

WATER NOTES


- 1 1" WATER SERVICE PER CITY STANDARDS
- 4 10" C900 WATER MAIN PER CITY STANDARDS
- 6 10" X 8" TEE WITH GATE VALVES
- 7 FIRE HYDRANT WITH PAD AND BOLLARDS PER CITY STANDARDS
- 8 10" X 6" TEE WITH GATE VALVE
- 9 BLOW OFF ASSEMBLY

SEWER NOTES


- 1 4" SEWER SERVICE PER CITY STANDARDS. 1000 GAL SEPTIC TANK TO BE INSTALLED.
- 3 8" PVC SEWER MAIN PER CITY STANDARDS
- 5 TEE WITH CLEANOUTS
- 7 REMOVE CLEANOUT AND CONNECT TO EXISTING 4" SEWER MAIN WITH REDUCER. INSTALL 8" CLEANOUT.

FRANCHISE UTILITY NOTES

- 1 POWER SERVICE PEDESTAL PER MIDSTATE
- 2 644 TRANSFORMER VAULT PER MIDSTATE
- 3 JOINT UTILITY TRENCH. REFER TO MIDSTATE POWER PLAN AND GAS AND TELCO UTILITY PLANS.
- 4 LIGHT POLE PER MIDSTATE.
- 6 EXISTING POWER POLES TO BE COORDINATED WITH MIDSTATE
- 7 EXISTING SWITCH GEAR VAULT. REFER TO MIDSTATE POWER PLAN.

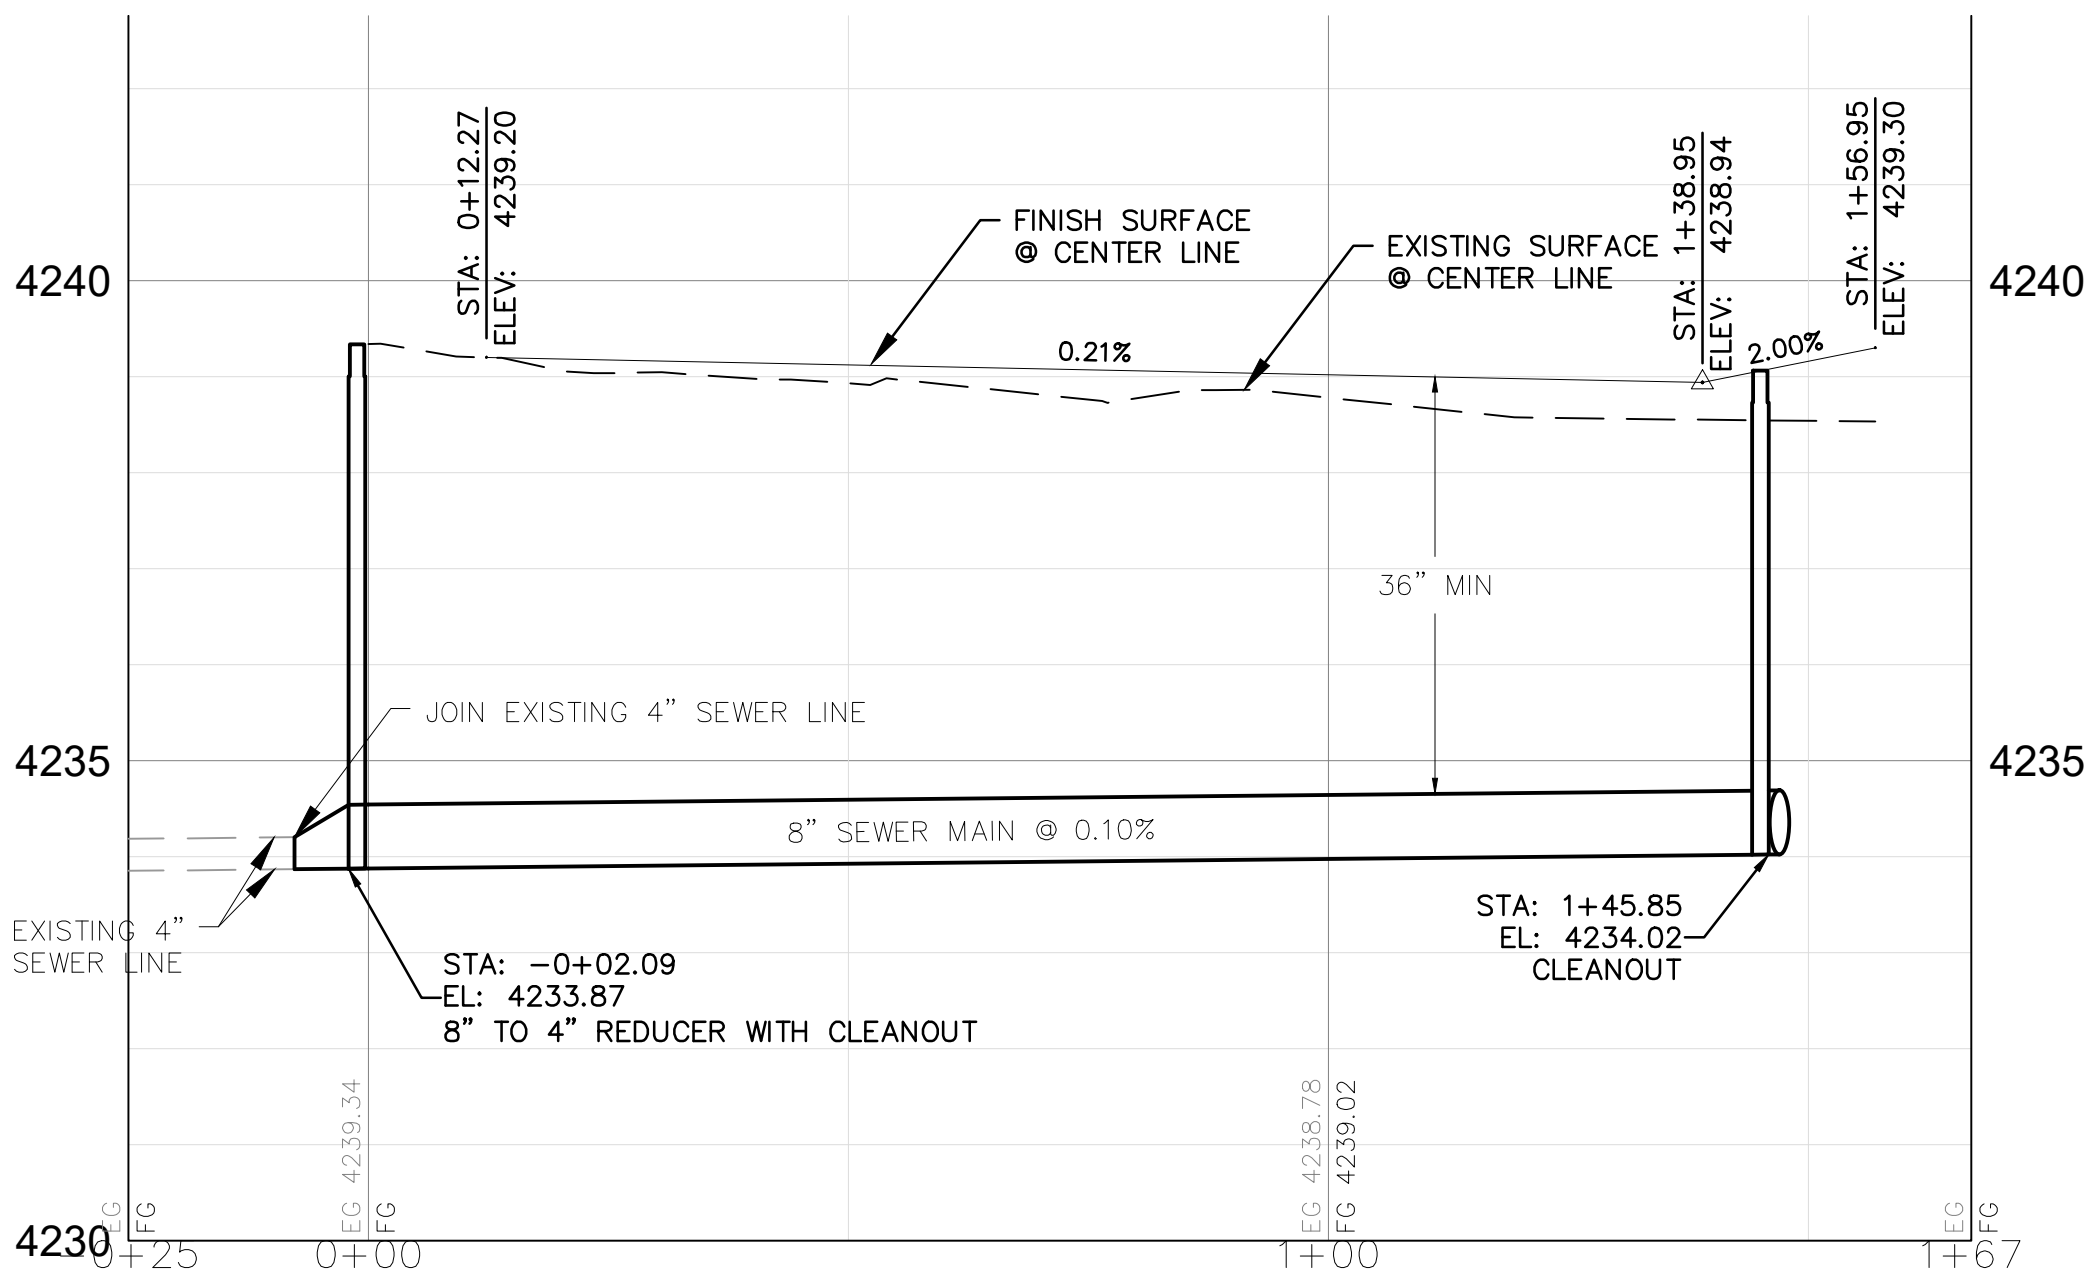

WALLING LANE PROFILE VIEW
SCALE: 1" = 2'V, 1" = 20'H

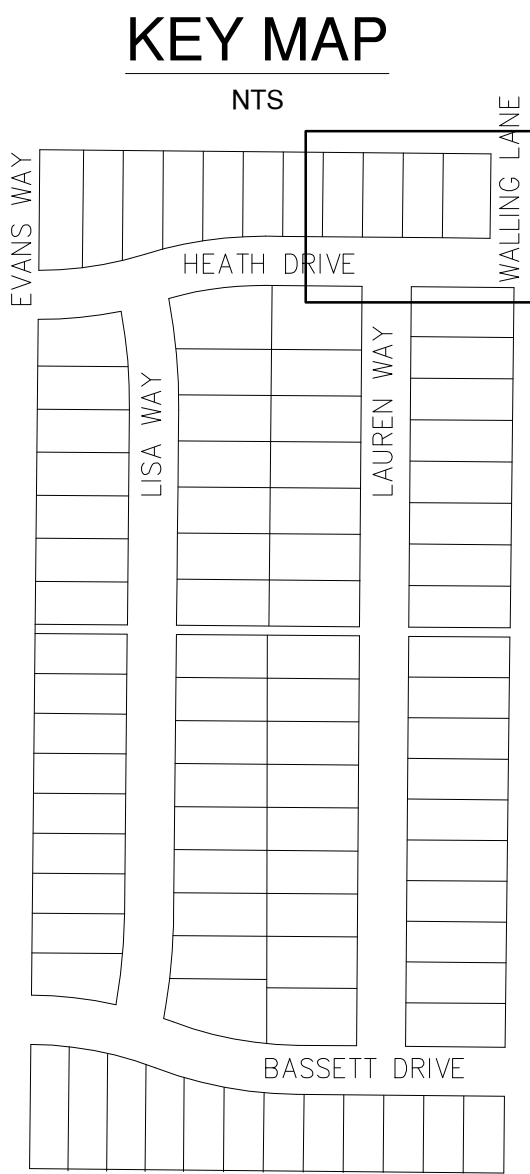

ENGINEERING SET



FINLEY BUTTE RANCH
RESIDENTIAL SUBDIVISION
ROAD IMPROVEMENTS - HEATH DRIVE
CITY OF LA PINE, DESCHUTES COUNTY, OREGON



REVISIONS:	1.	2.	3.





DESIGNED BY: TRM
DRAWN BY: SMA
SCALE: 1"=20'
FILE: 24004
DATE: 09/10/2024

VERIFY SCALES
0 1"
BAR EQUALS ONE INCH
ON ORIGINAL DRAWING

SHEET: C4.1

06 OF 15

PERMIT# 02SUB-24

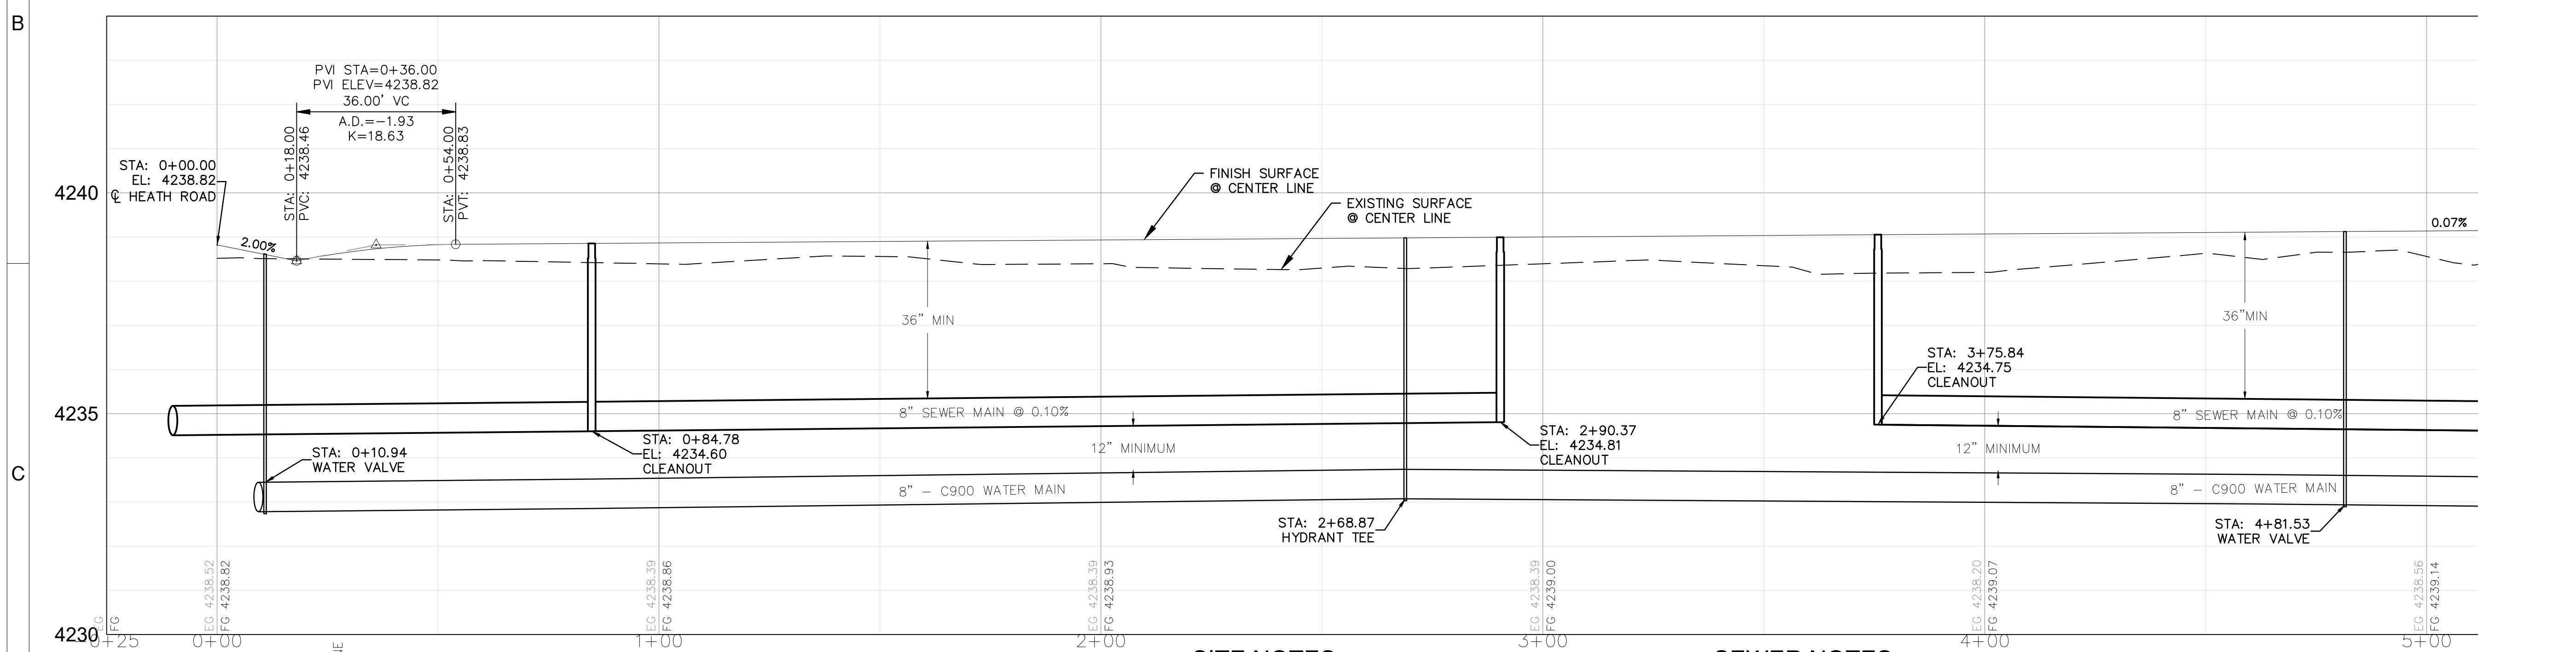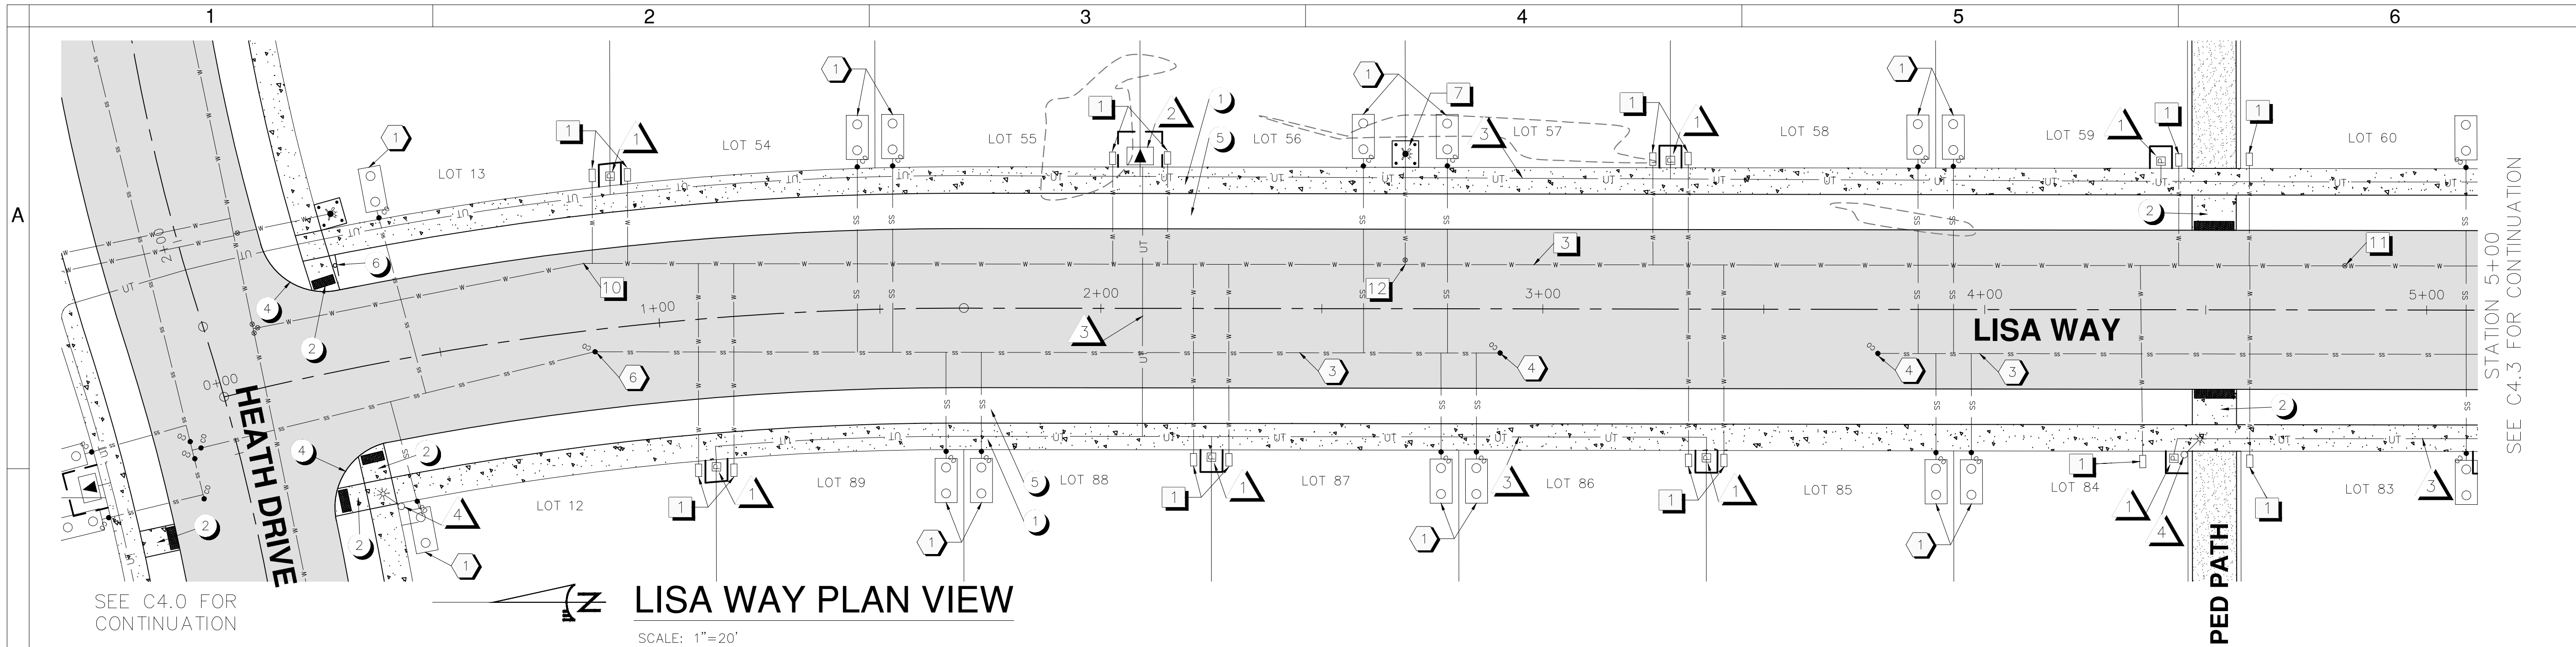

LISA WAY PROFILE VIEW

SCALE: 1" = 2'V, 1" = 20'H

SITE NOTES

- 1 CONCRETE SIDEWALK PER DETAILS SHEETS
- 2 ADA RAMP TO BE CONSTRUCTED
- 4 15' RADIUS
- 5 DRAINAGE SWALE
- 6 STOP SIGN WITH ROAD NAMES PER CITY STANDARDS

WATER NOTES

- 1 WATER SERVICE PER CITY STANDARDS
- 3 8" C900 WATER MAIN PER CITY STANDARDS
- 7 FIRE HYDRANT WITH PAD AND BOLLARDS PER CITY STANDARDS
- 10 8" 11.25' BEND
- 11 8" GATE VALVE
- 12 8" X 6" TEE WITH GATE VALVE


SEWER NOTES

- 1 4" SEWER SERVICE PER CITY STANDARDS. 1000 GAL SEPTIC TANK TO BE INSTALLED.
- 3 8" PVC SEWER MAIN PER CITY STANDARDS
- 4 SEWER CLEANOUT
- 6 11.25' BEND WITH CLEANOUT

FRANCHISE UTILITY NOTES

- 1 POWER SERVICE PEDESTAL PER MIDSTATE
- 2 644 TRANSFORMER VAULT PER MIDSTATE
- 3 JOINT UTILITY TRENCH. REFER TO MIDSTATE POWER PLAN AND GAS AND TELCO UTILITY PLANS.
- 4 LIGHT POLE PER MIDSTATE.

KEY MAP

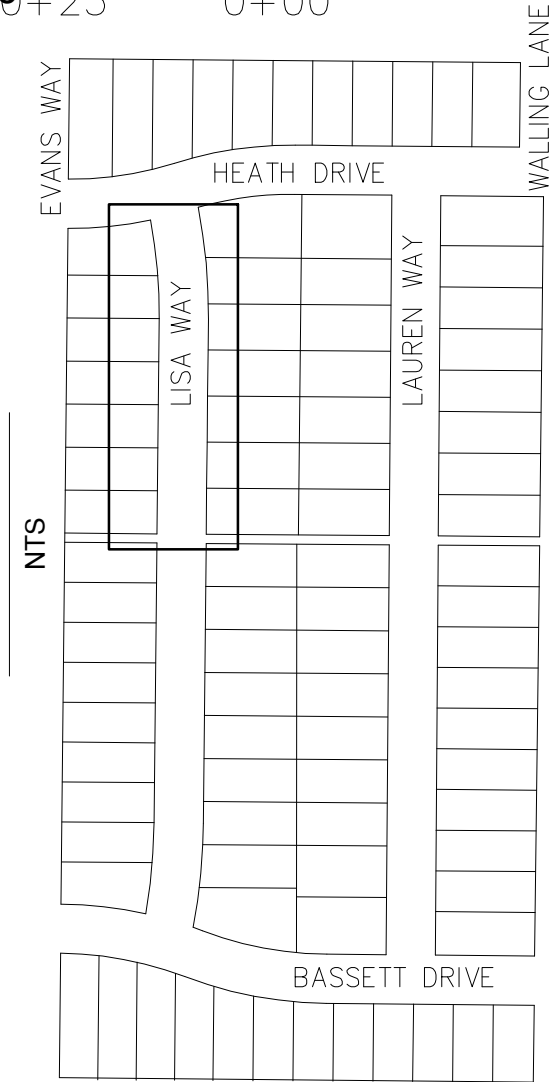

FINLEY BUTTE RANCH RESIDENTIAL SUBDIVISION ROAD IMPROVEMENTS - LISA WAY CITY OF LA PINE, DESCHUTES COUNTY, OREGON



REVISIONS:

- 1.
- 2.
- 3.



DESIGNED BY: TRM
DRAWN BY: SMA
SCALE: 1"=20'
FILE: 24004
DATE: 09/10/2024

VERIFY SCALES
0 1"
BAR EQUALS ONE INCH
ON ORIGINAL DRAWING


SHEET:

C4.2


07 OF 15

PERMIT# 02SUB-24

ENGINEERING SET

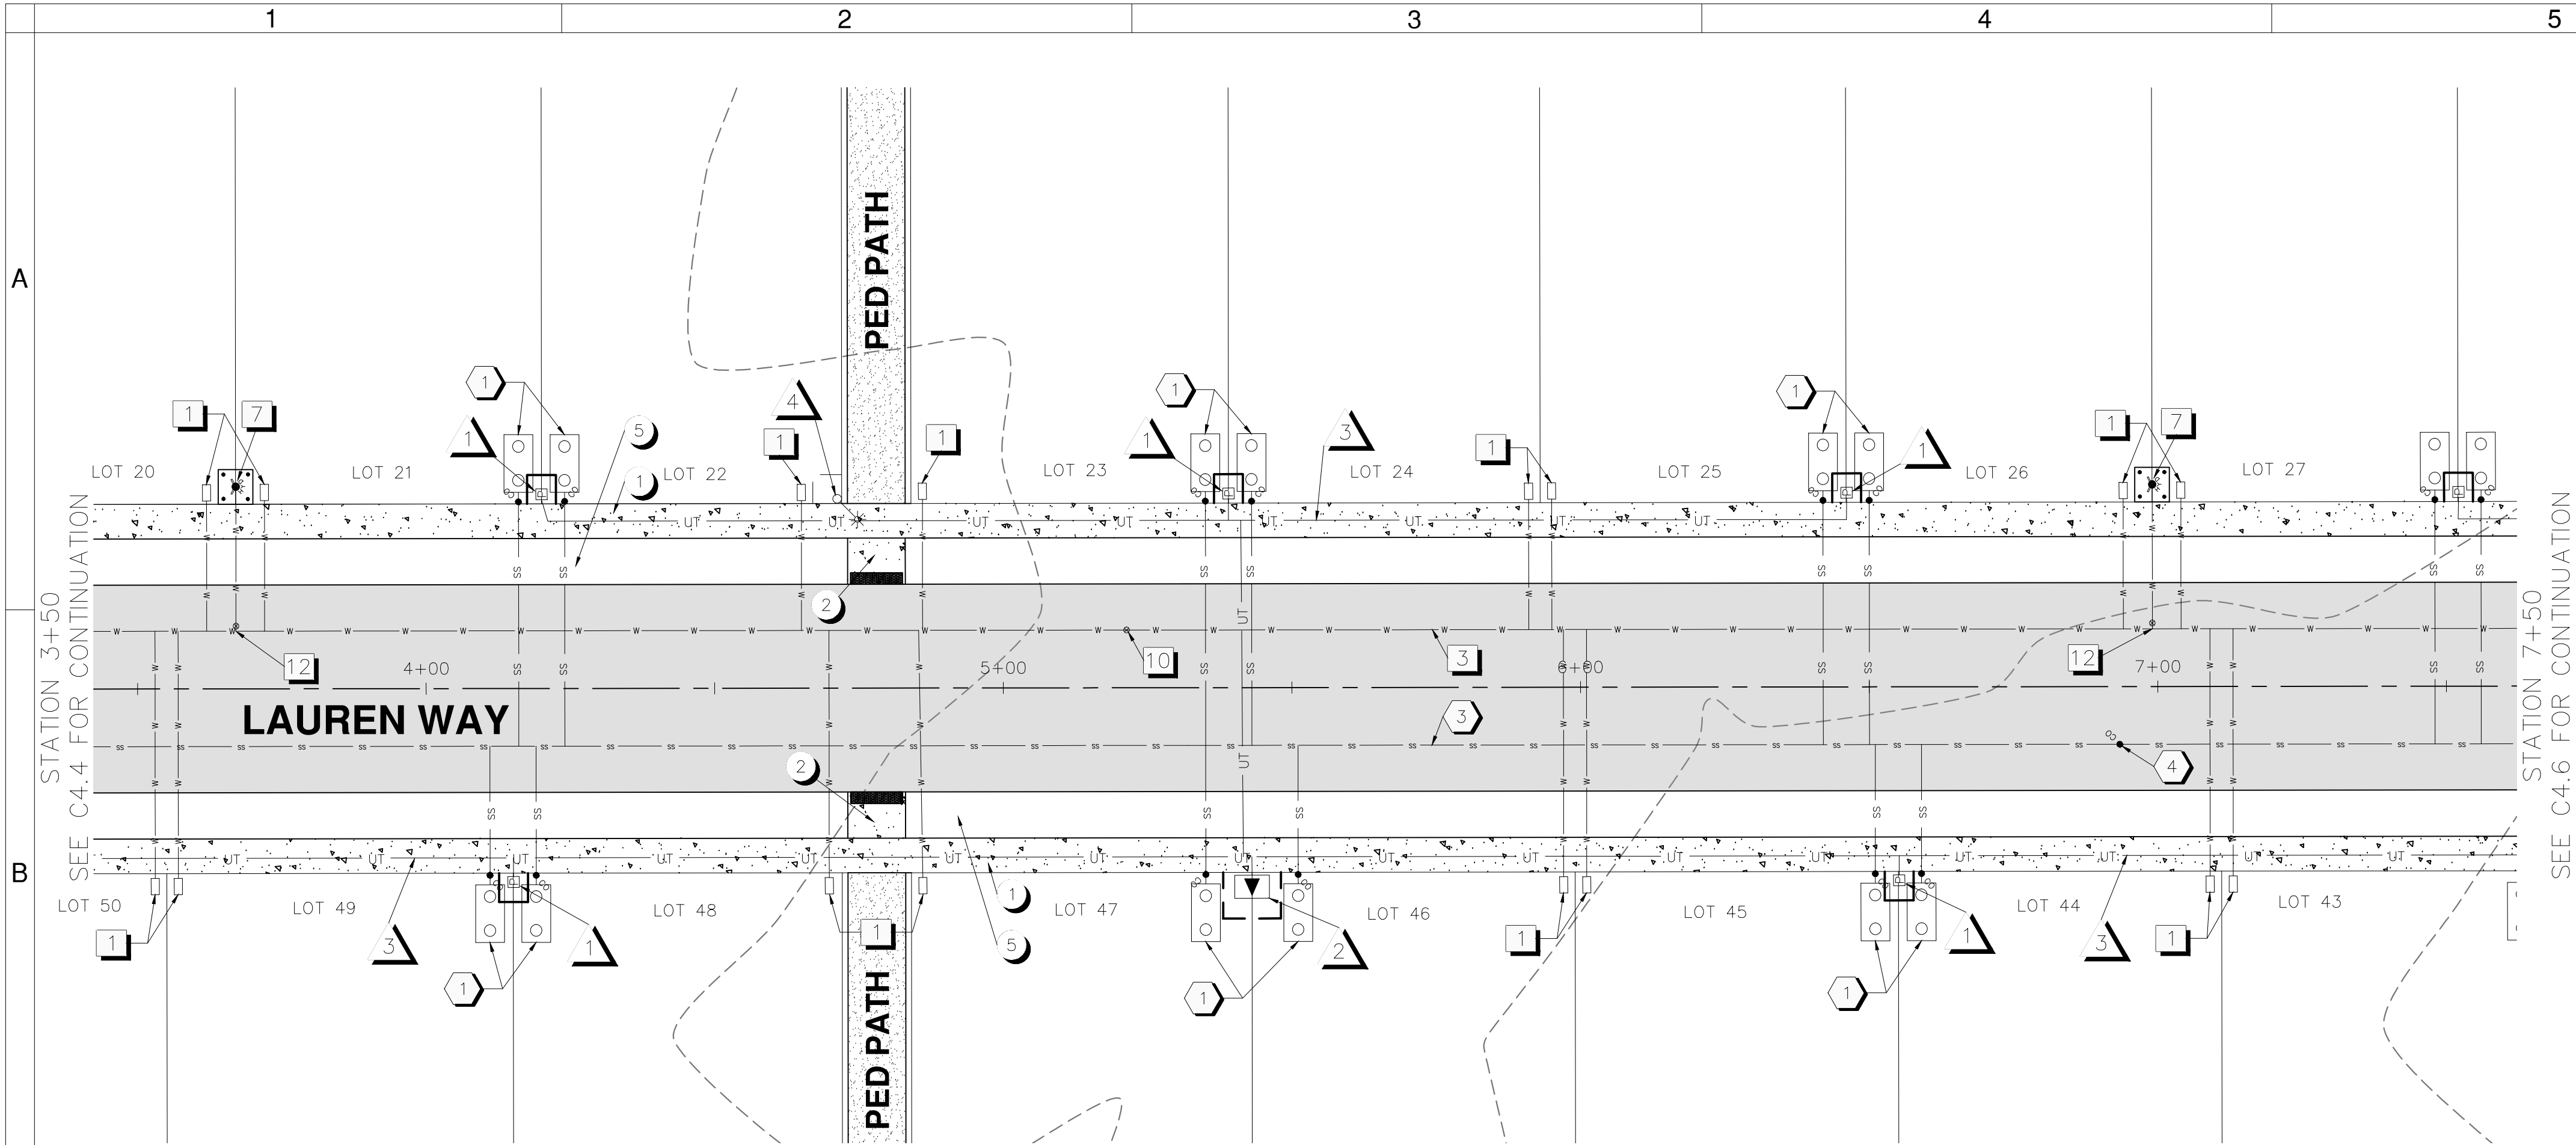

LAUREN WAY PLAN VIEW
SCALE: 1"=20'

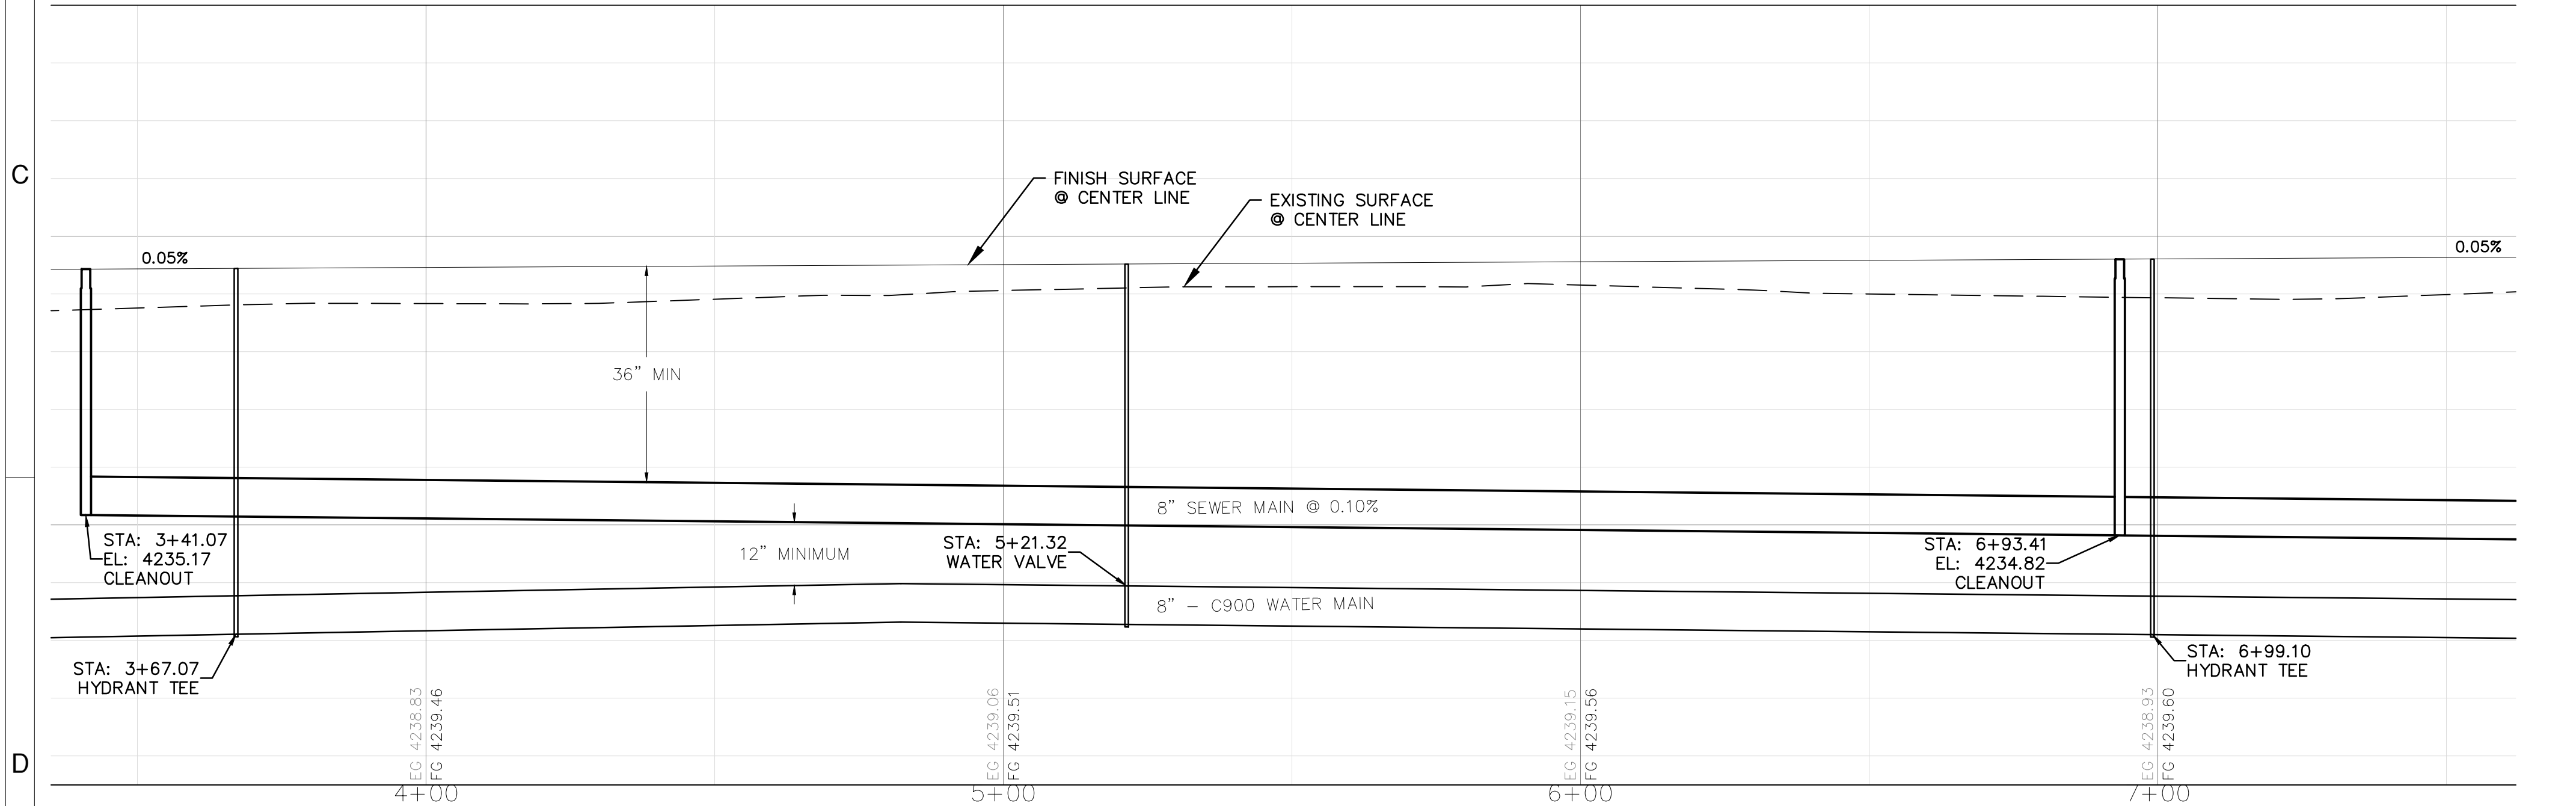

LAUREN WAY PROFILE VIEW
SCALE: 1" = 2'V, 1" = 20'H

SITE NOTES

- 1 CONCRETE SIDEWALK PER DETAILS SHEETS
- 2 ADA RAMP TO BE CONSTRUCTED
- 5 DRAINAGE SWALE

WATER NOTES


- 1 1" WATER SERVICE PER CITY STANDARDS
- 3 8" C900 WATER MAIN PER CITY STANDARDS
- 7 FIRE HYDRANT WITH PAD AND BOLLARDS PER CITY STANDARDS
- 10 8" GATE VALVE
- 12 8" X 6" TEE WITH GATE VALVE

SEWER NOTES

- 1 4" SEWER SERVICE PER CITY STANDARDS. 1000 GAL SEPTIC TANK TO BE INSTALLED.
- 3 8" PVC SEWER MAIN PER CITY STANDARDS
- 4 SEWER CLEANOUT

FRANCHISE UTILITY NOTES

- 1 POWER SERVICE PEDESTAL PER MIDSTATE
- 2 644 TRANSFORMER VAULT PER MIDSTATE
- 3 JOINT UTILITY TRENCH. REFER TO MIDSTATE POWER PLAN AND GAS AND TELCO UTILITY PLANS.
- 4 LIGHT POLE PER MIDSTATE.

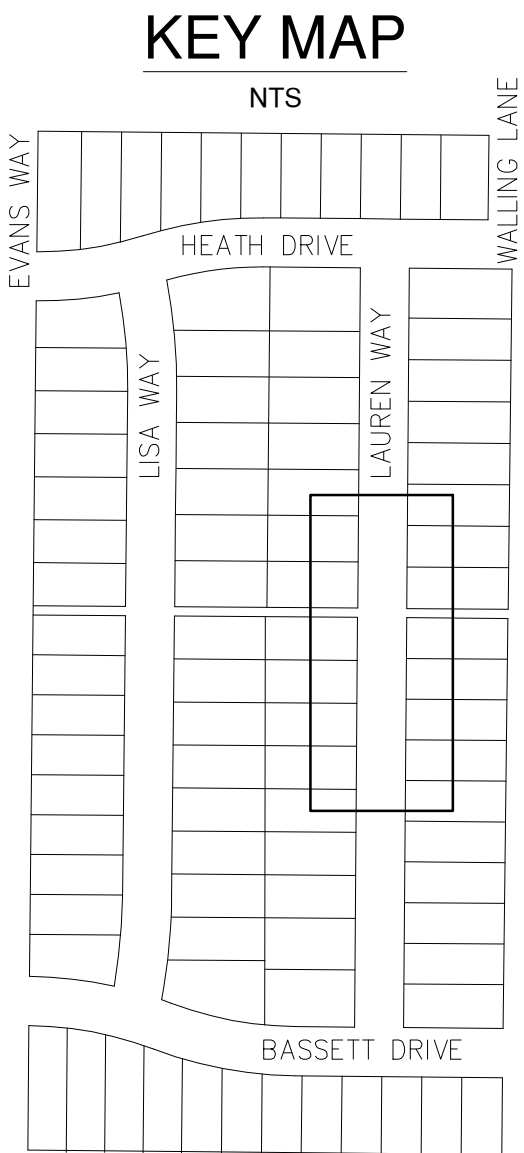

**FINLEY BUTTE RANCH
RESIDENTIAL SUBDIVISION
ROAD IMPROVEMENTS - LAUREN WAY**
CITY OF LA PINE, DESCHUTES COUNTY, OREGON



REVISIONS:	
1.	
2.	
3.	

BECON
549 SW MILL VIEW WAY
SUITE 100
BEND, OREGON 97702
(541) 633-3140
www.becconeng.com

Civil Engineering & Land Surveying



DESIGNED BY: TRM
DRAWN BY: SMA
SCALE: 1"=20'
FILE: 24004
DATE: 09/10/2024

VERIFY SCALES
0 1"
BAR EQUALS ONE INCH
ON ORIGINAL DRAWING

SHEET: **C4.5**

10 OF 15

PERMIT# 02SUB-24

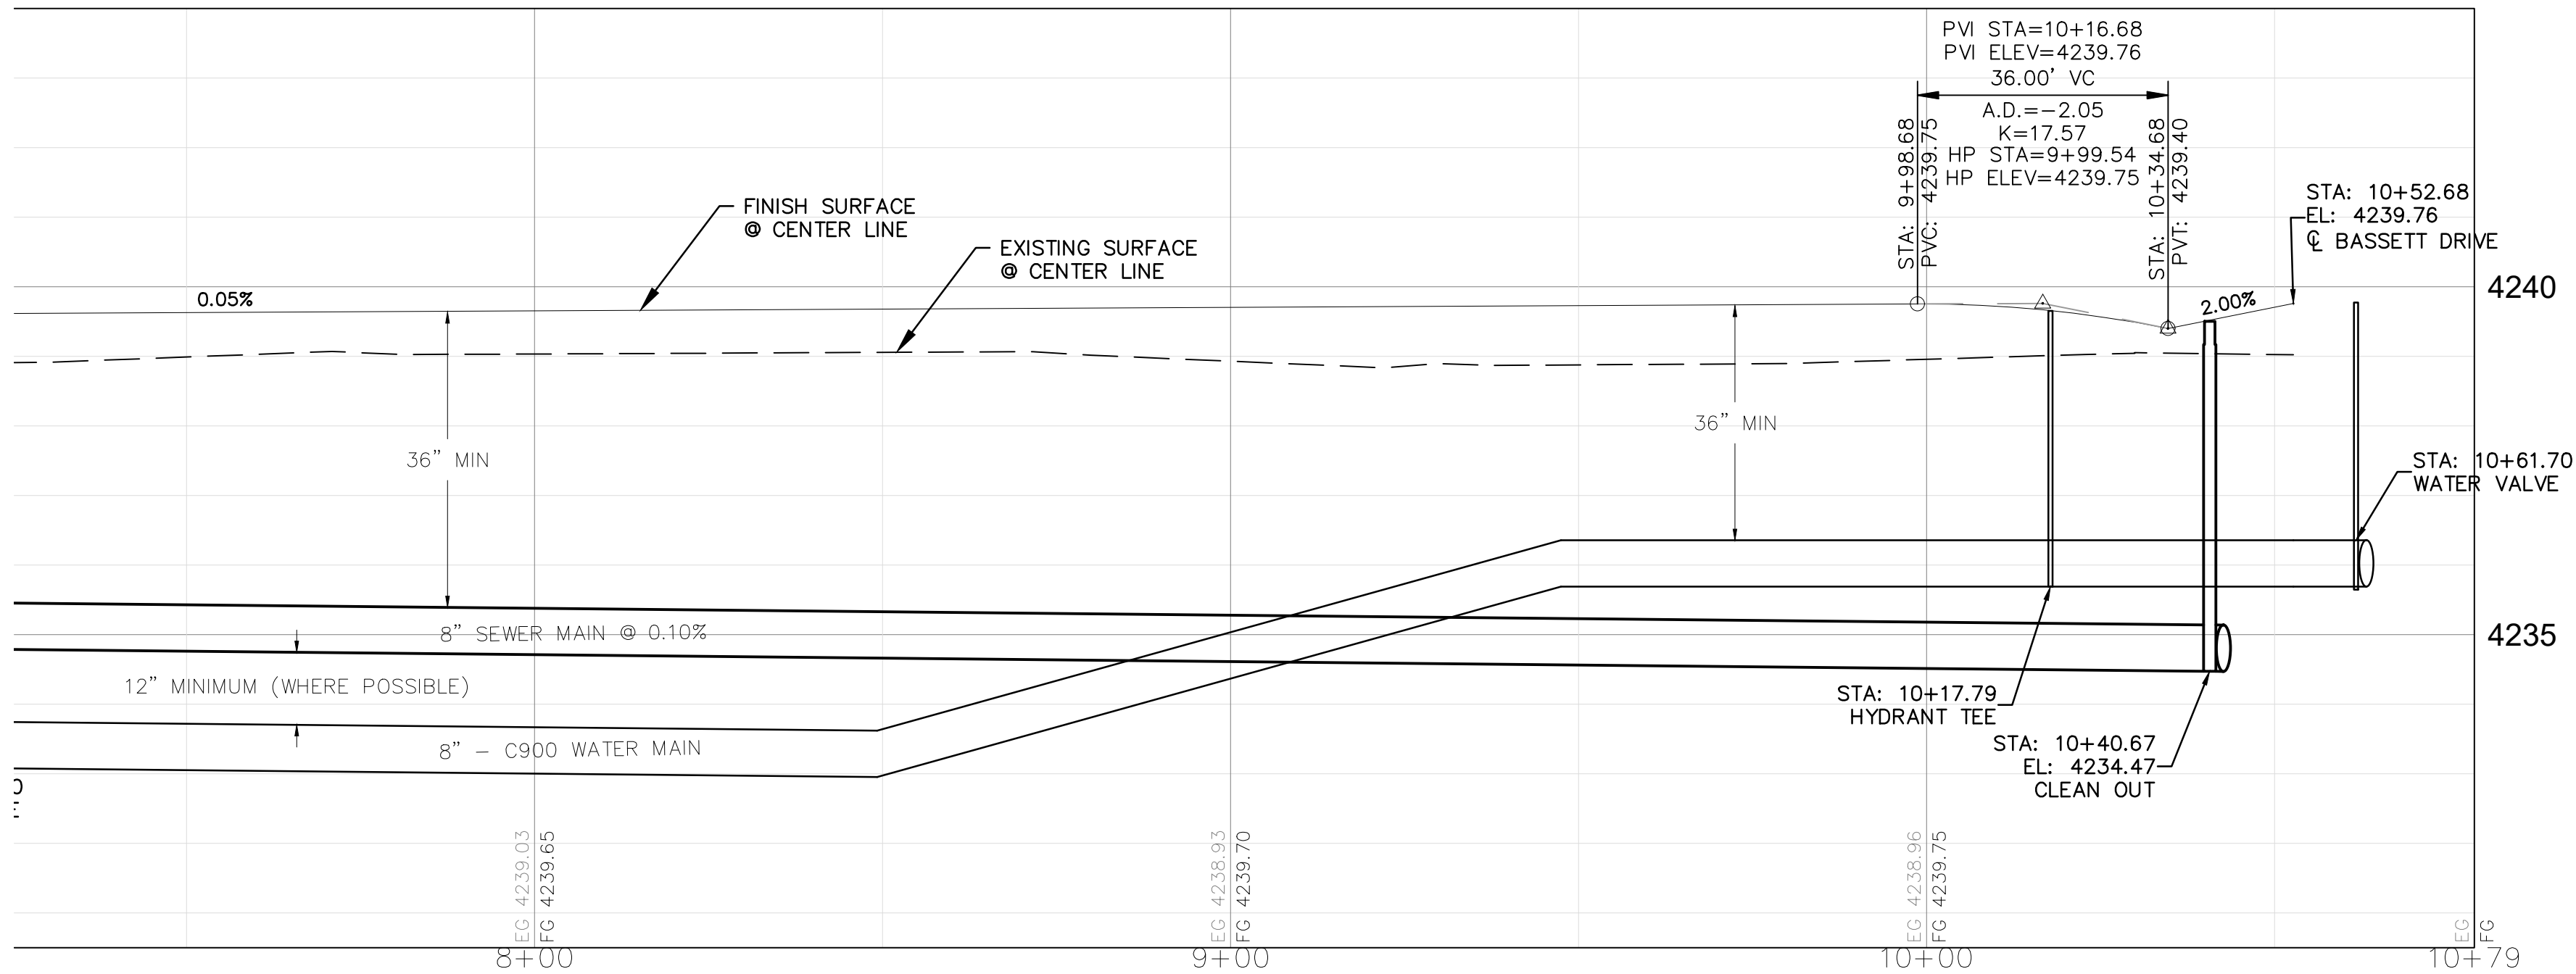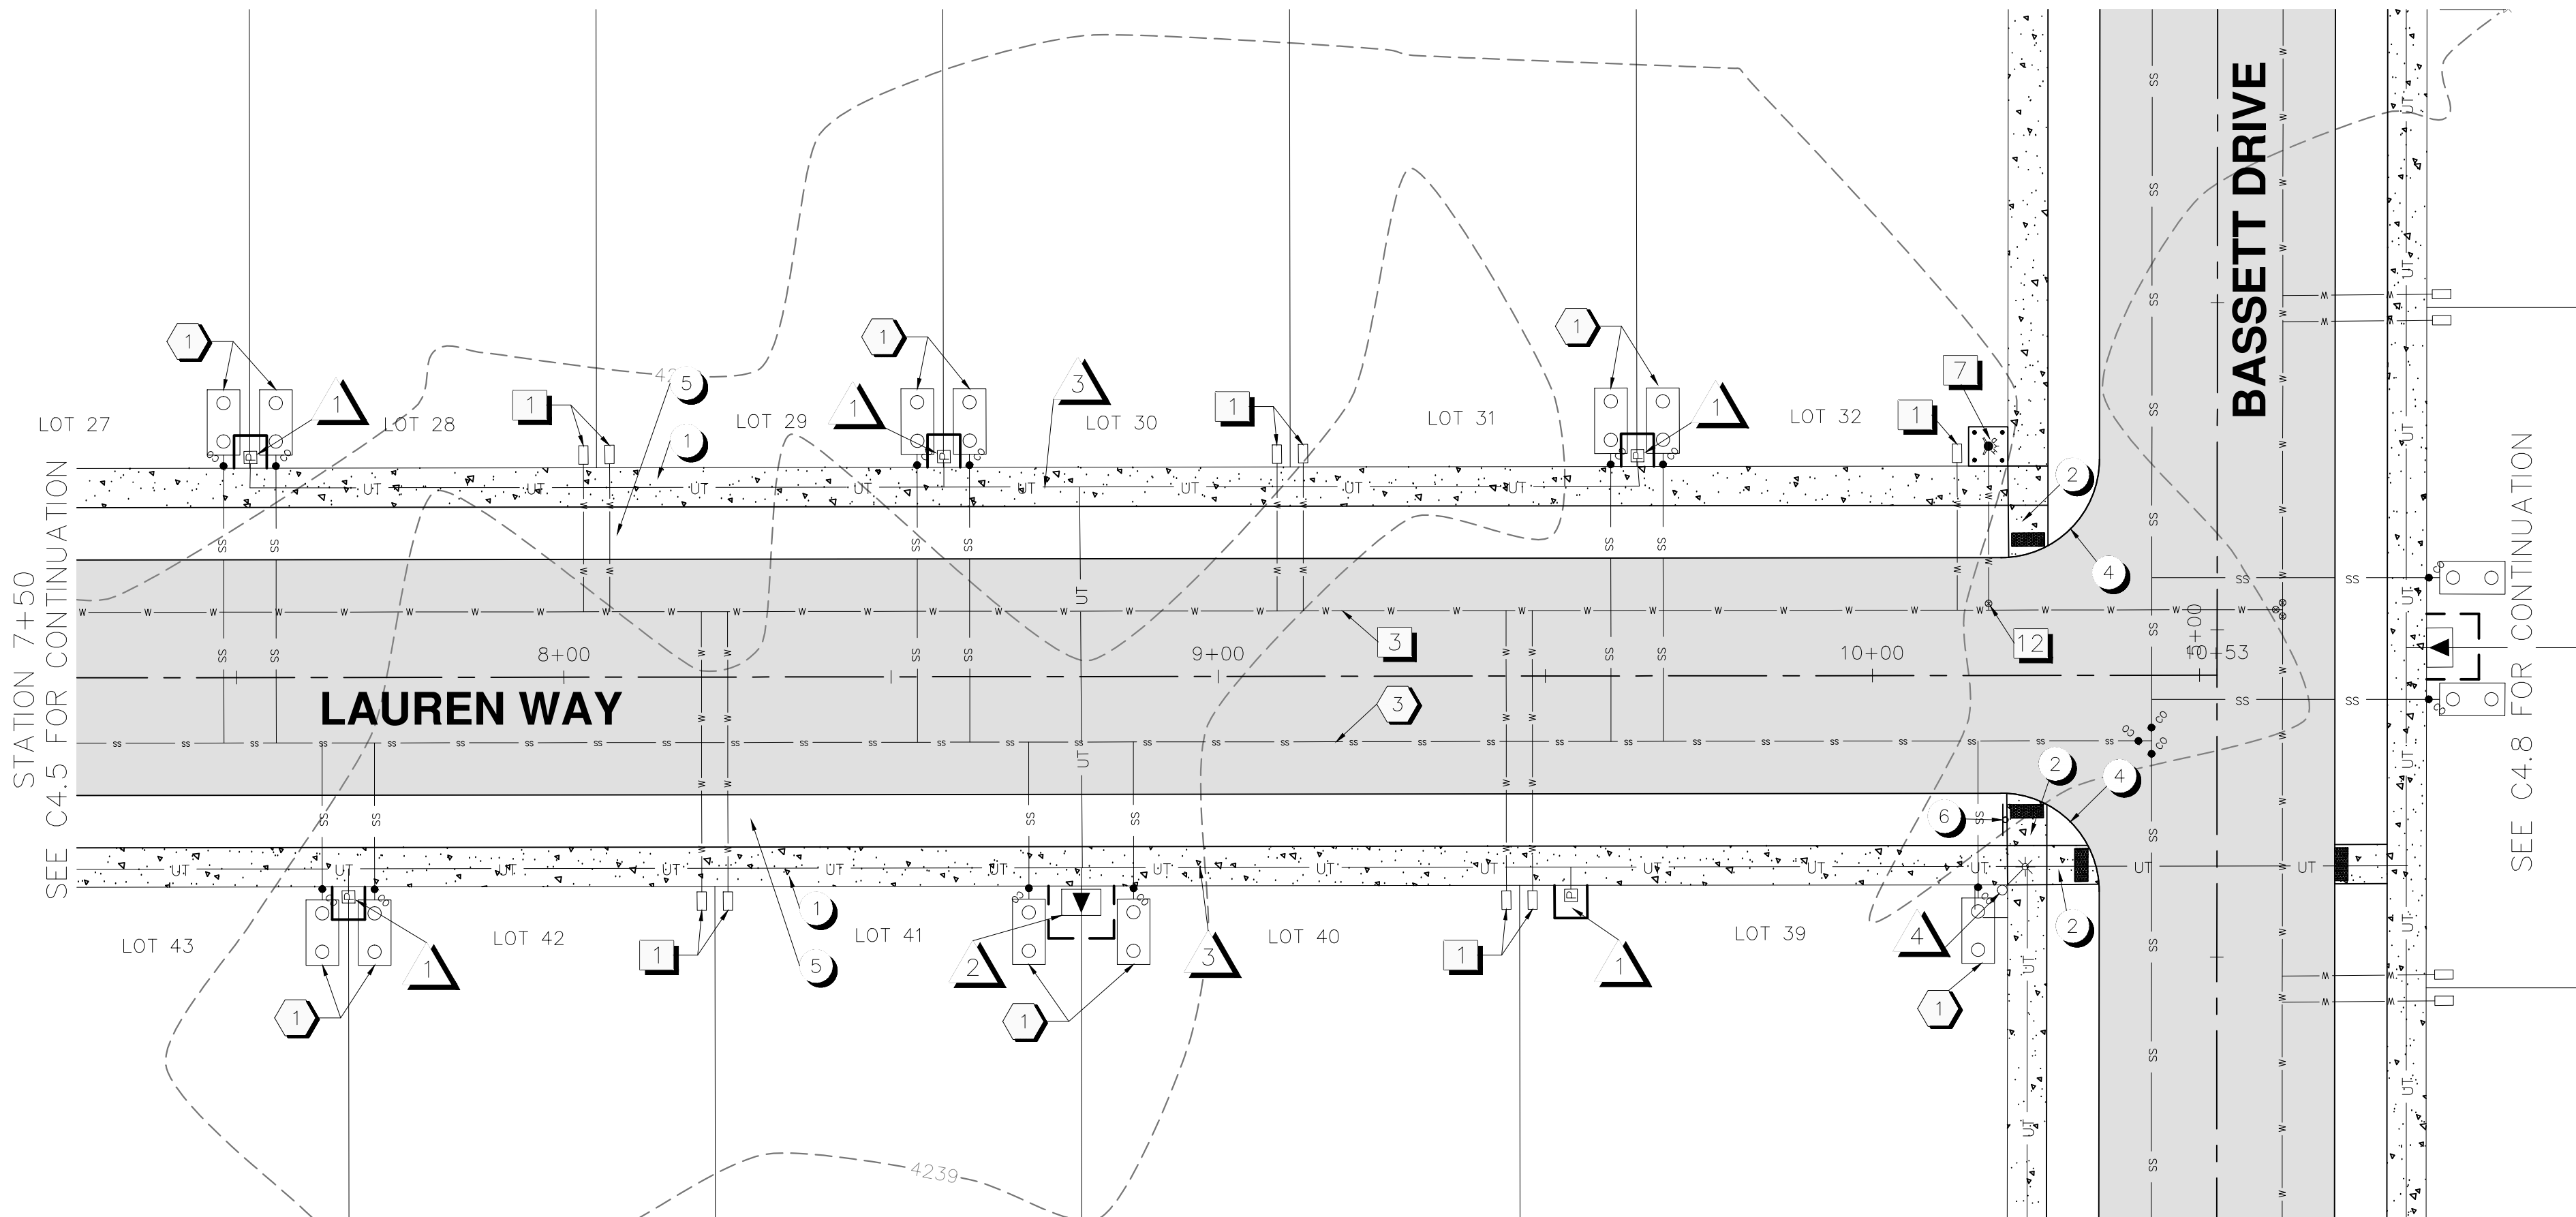

SITE NOTES

- 1 CONCRETE SIDEWALK PER DETAILS SHEETS
- 2 ADA RAMP TO BE CONSTRUCTED
- 4 15' RADIUS
- 5 DRAINAGE SWALE
- 6 STOP SIGN WITH ROAD NAMES PER CITY STANDARDS

WATER NOTES


- 1 1" WATER SERVICE PER CITY STANDARDS
- 3 8" C900 WATER MAIN PER CITY STANDARDS
- 7 FIRE HYDRANT WITH PAD AND BOLLARDS PER CITY STANDARDS
- 12 8" X 6" TEE WITH GATE VALVE

SEWER NOTES

- 1 4" SEWER SERVICE PER CITY STANDARDS. 1000 GAL SEPTIC TANK TO BE INSTALLED.
- 3 8" PVC SEWER MAIN PER CITY STANDARDS

FRANCHISE UTILITY NOTES

- 1 POWER SERVICE PEDESTAL PER MIDSTATE
- 2 644 TRANSFORMER VAULT PER MIDSTATE
- 3 JOINT UTILITY TRENCH. REFER TO MIDSTATE POWER PLAN AND GAS AND TELCO UTILITY PLANS.
- 4 LIGHT POLE PER MIDSTATE.

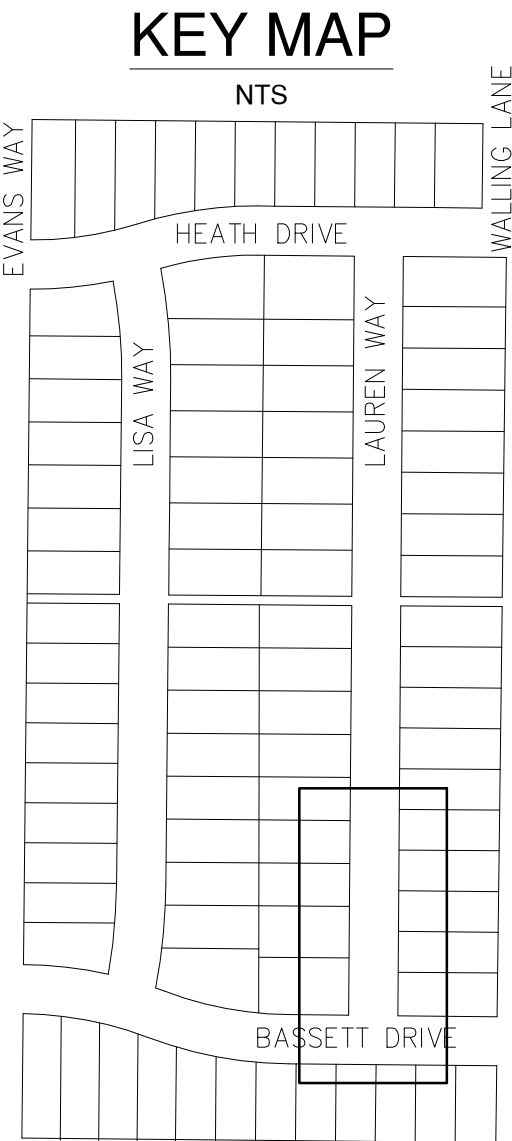

FINLEY BUTTE RANCH
RESIDENTIAL SUBDIVISION
ROAD IMPROVEMENTS - LAUREN WAY
CITY OF LA PINE, DESCHUTES COUNTY, OREGON



REVISIONS:
1.
2.
3.



DESIGNED BY: TRM	DATE: 09/10/2024
DRAWN BY: SMA	
SCALE: 1"=20'	
FILE: 24004	



VERIFY SCALES
0 1"
BAR EQUALS ONE INCH
ON ORIGINAL DRAWING

SHEET: C4.6

11 OF 15

PERMIT# 02SUB-24

ENGINEERING SET

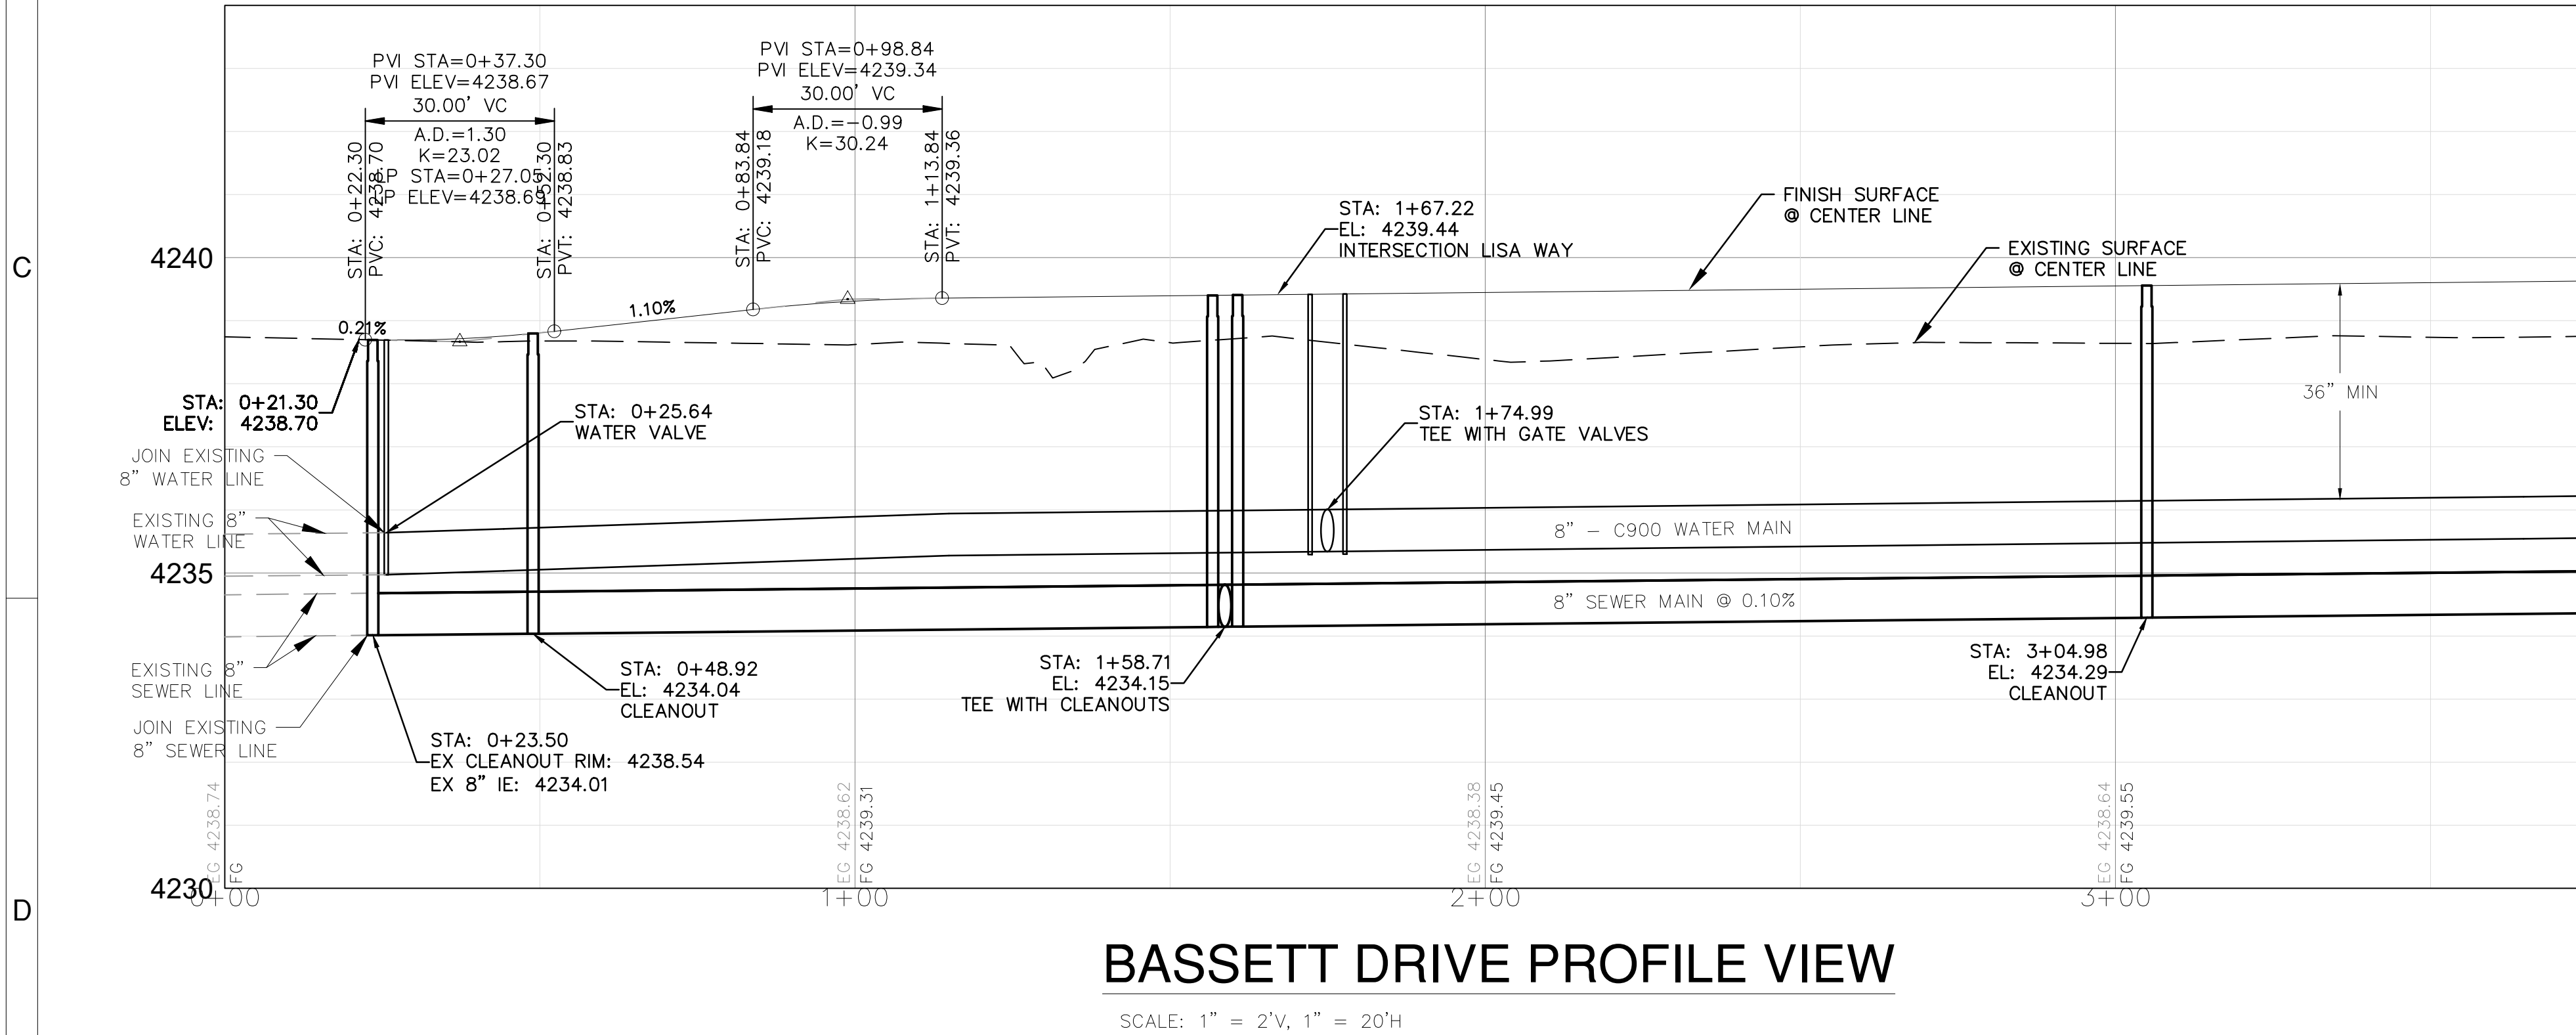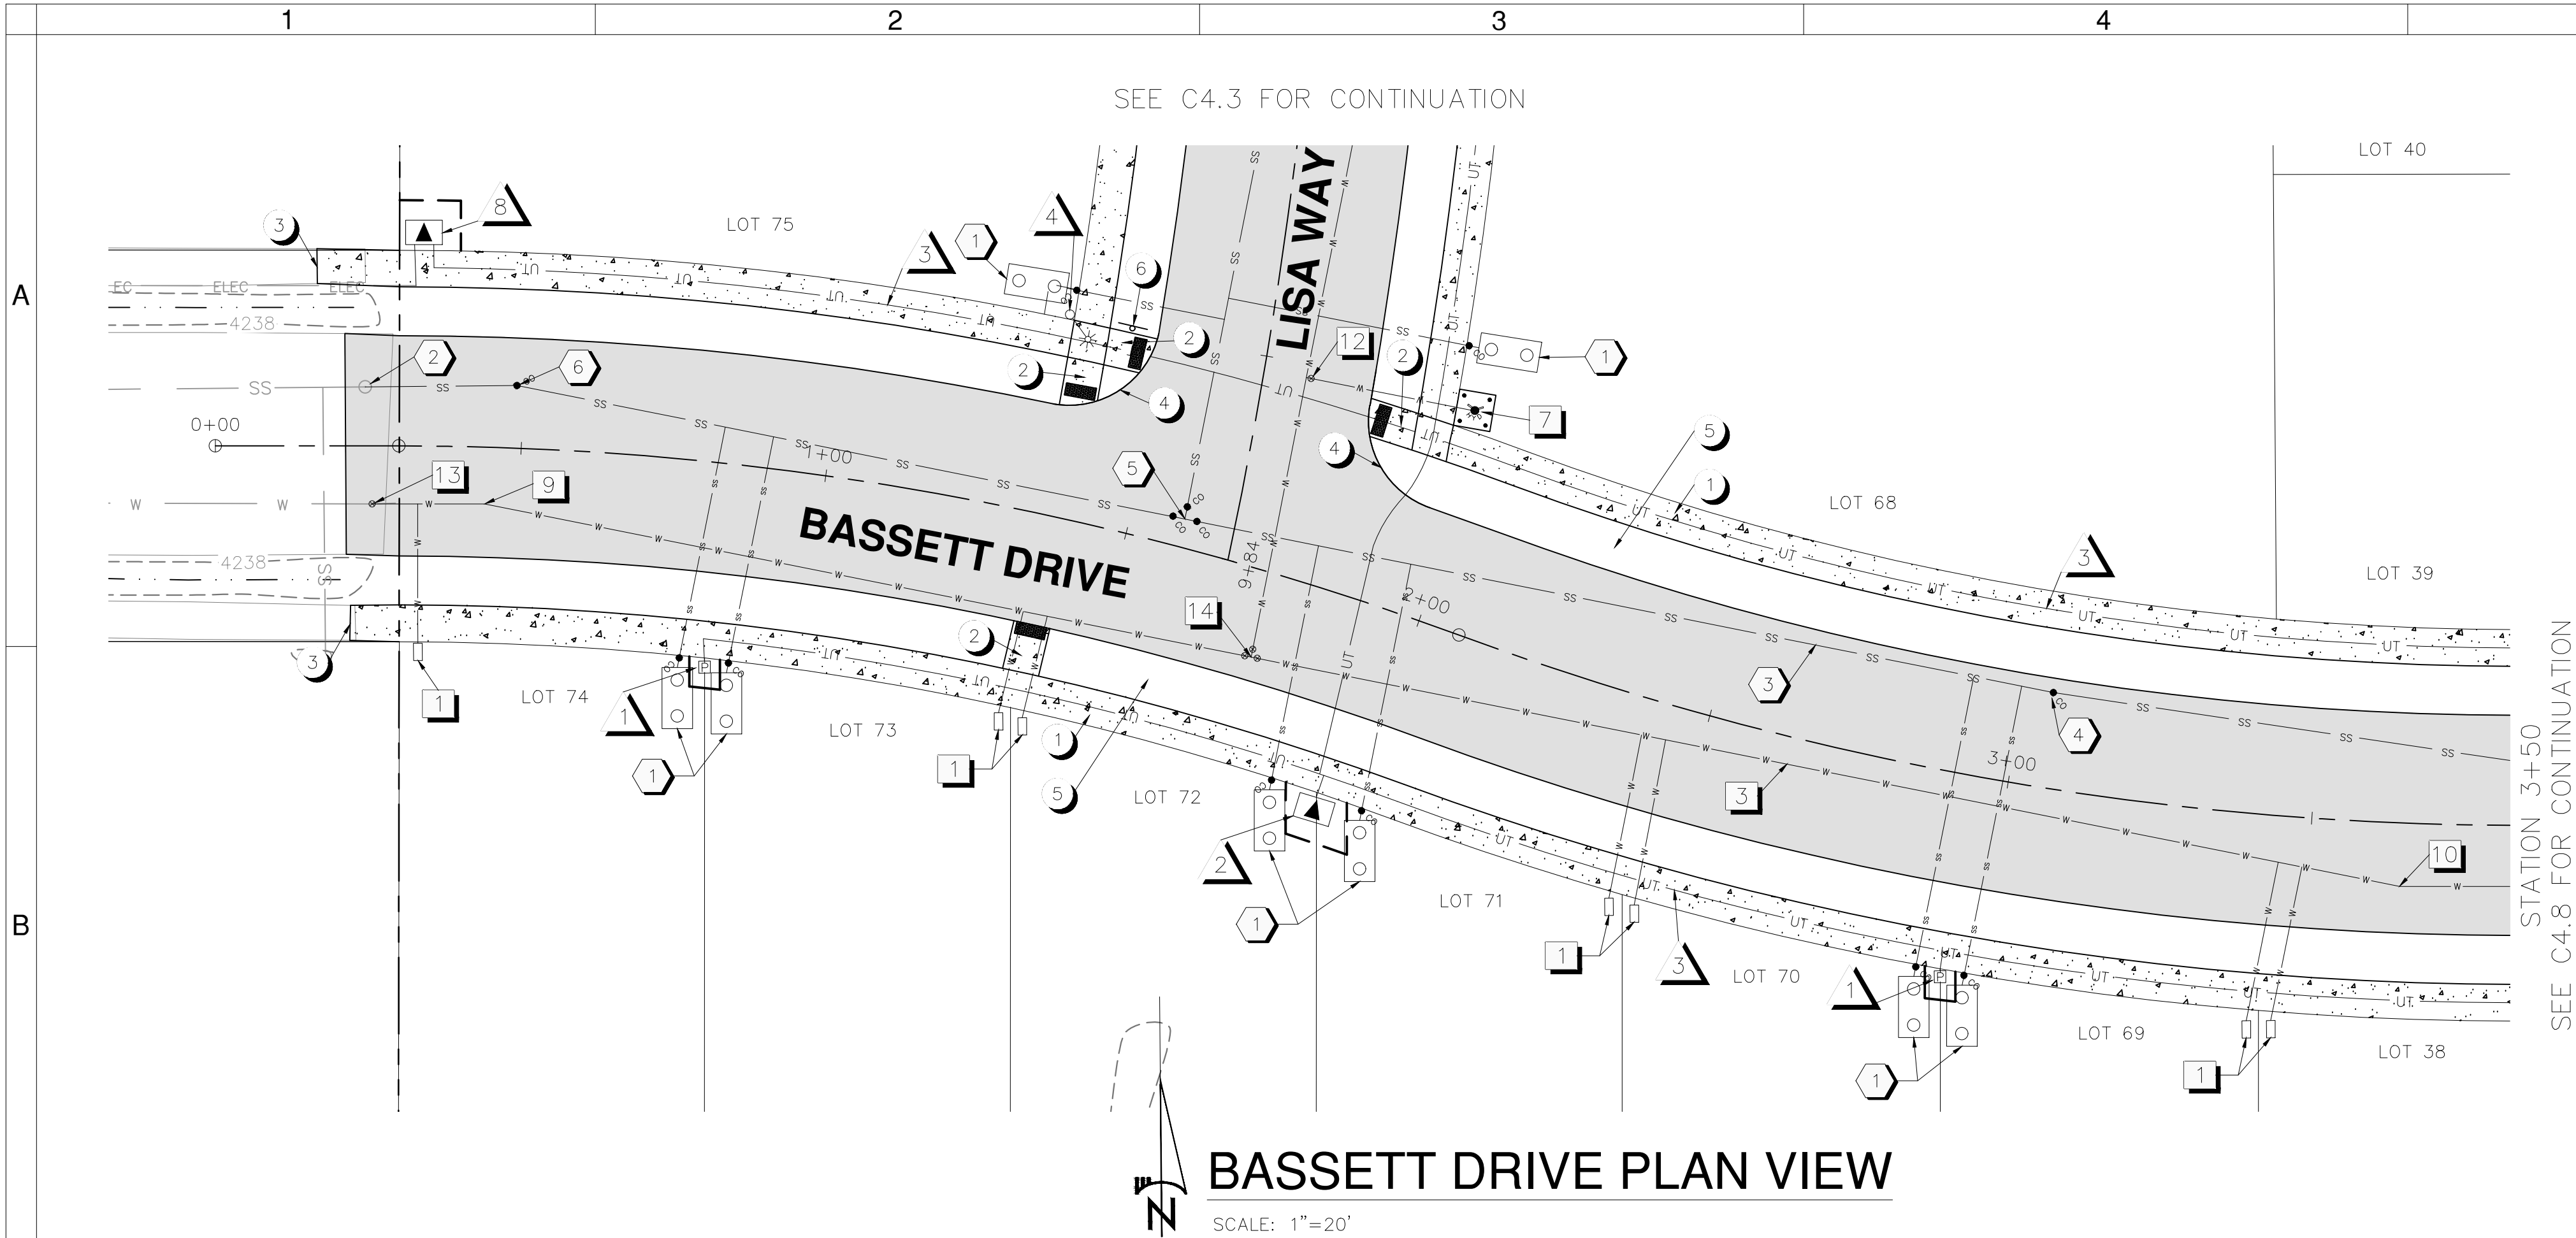

SITE NOTES

- 1 CONCRETE SIDEWALK PER DETAILS SHEETS
- 2 ADA RAMP TO BE CONSTRUCTED
- 3 MATCH GRADE - BEGIN SIDEWALK
- 4 15' RADIUS
- 5 DRAINAGE SWALE
- 6 STOP SIGN WITH ROAD NAMES PER CITY STANDARDS

WATER NOTES


- 1 1" WATER SERVICE PER CITY STANDARDS
- 3 8" C900 WATER MAIN PER CITY STANDARDS
- 7 FIRE HYDRANT WITH PAD AND BOLLARDS PER CITY STANDARDS
- 10 8" - 11.25' BEND
- 12 8" X 6" TEE WITH GATE VALVE
- 13 REMOVE BLOW OFF AND CONNECT TO EXISTING 8" WATER MAIN. INSTALL GATE VALVE.
- 14 8" TEE WITH GATE VALVES

SEWER NOTES

- 1 4" SEWER SERVICE PER CITY STANDARDS. 1000 GAL SEPTIC TANK TO BE INSTALLED.
- 2 REMOVE CLEANOUT AND CONNECT TO EXISTING SEWER MAIN
- 3 8" PVC SEWER MAIN PER CITY STANDARDS
- 4 SEWER CLEANOUT
- 5 TEE WITH CLEANOUTS
- 6 11.25' BEND WITH CLEANOUT

FRANCHISE UTILITY NOTES

- 1 POWER SERVICE PEDESTAL PER MIDSTATE
- 2 644 TRANSFORMER VAULT PER MIDSTATE
- 3 JOINT UTILITY TRENCH. REFER TO MIDSTATE POWER PLAN AND GAS AND TELCO UTILITY PLANS.
- 4 LIGHT POLE PER MIDSTATE.
- 8 575 VAULT PER MIDSTATE

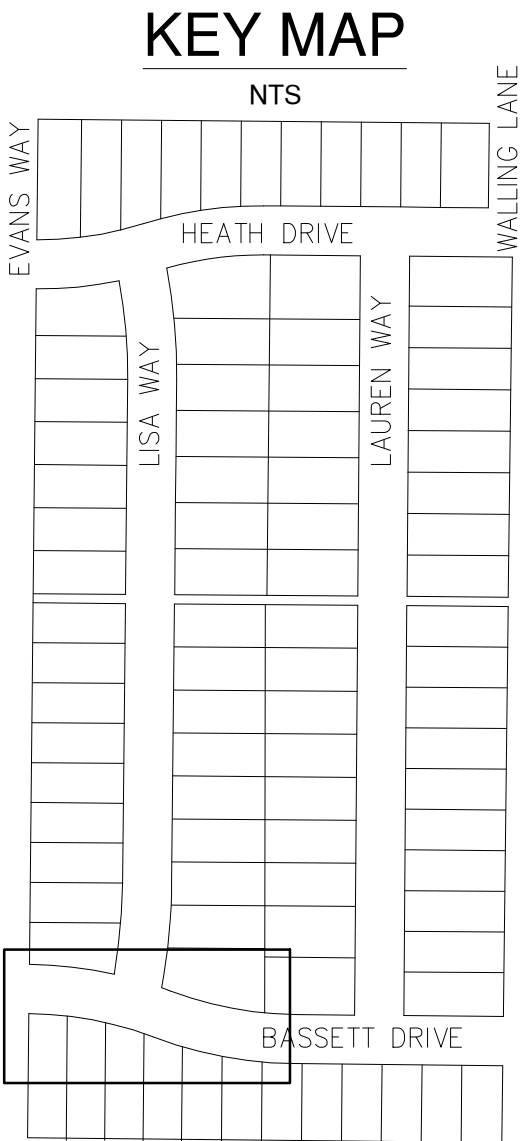

FINLEY BUTTE RANCH
RESIDENTIAL SUBDIVISION
ROAD IMPROVEMENTS - BASSETT DRIVE
CITY OF LA PINE, DESCHUTES COUNTY, OREGON



REVISIONS:	1.	2.	3.



DESIGNED BY: TRM
DRAWN BY: SMA
SCALE: 1"=20'
FILE: 24004
DATE: 09/10/2024


VERIFY SCALES
0 1"
BAR EQUALS ONE INCH
ON ORIGINAL DRAWING

SHEET: **C4.7**


12 OF 15

PERMIT# 02SUB-24


ENGINEERING SET

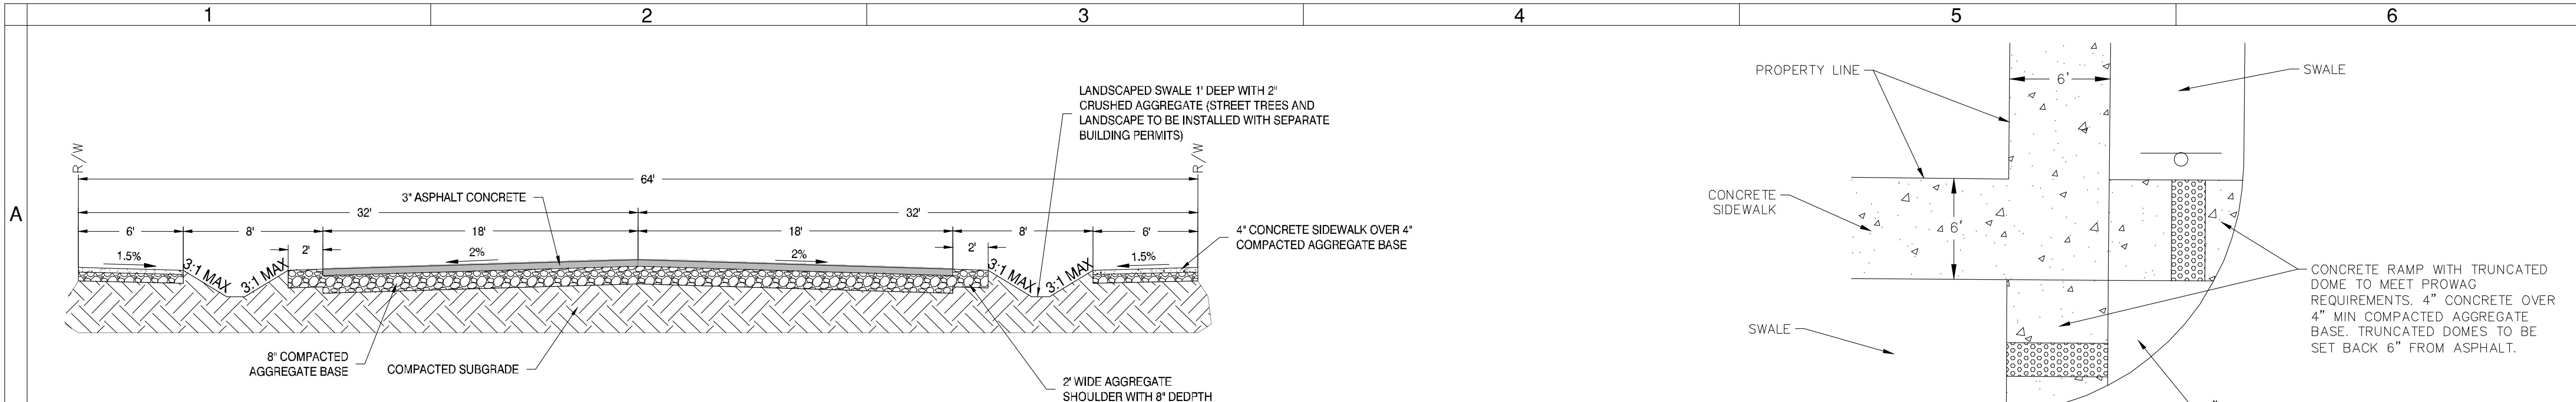


TYPICAL SECTION - LOCAL STREET
SCALE: NTS

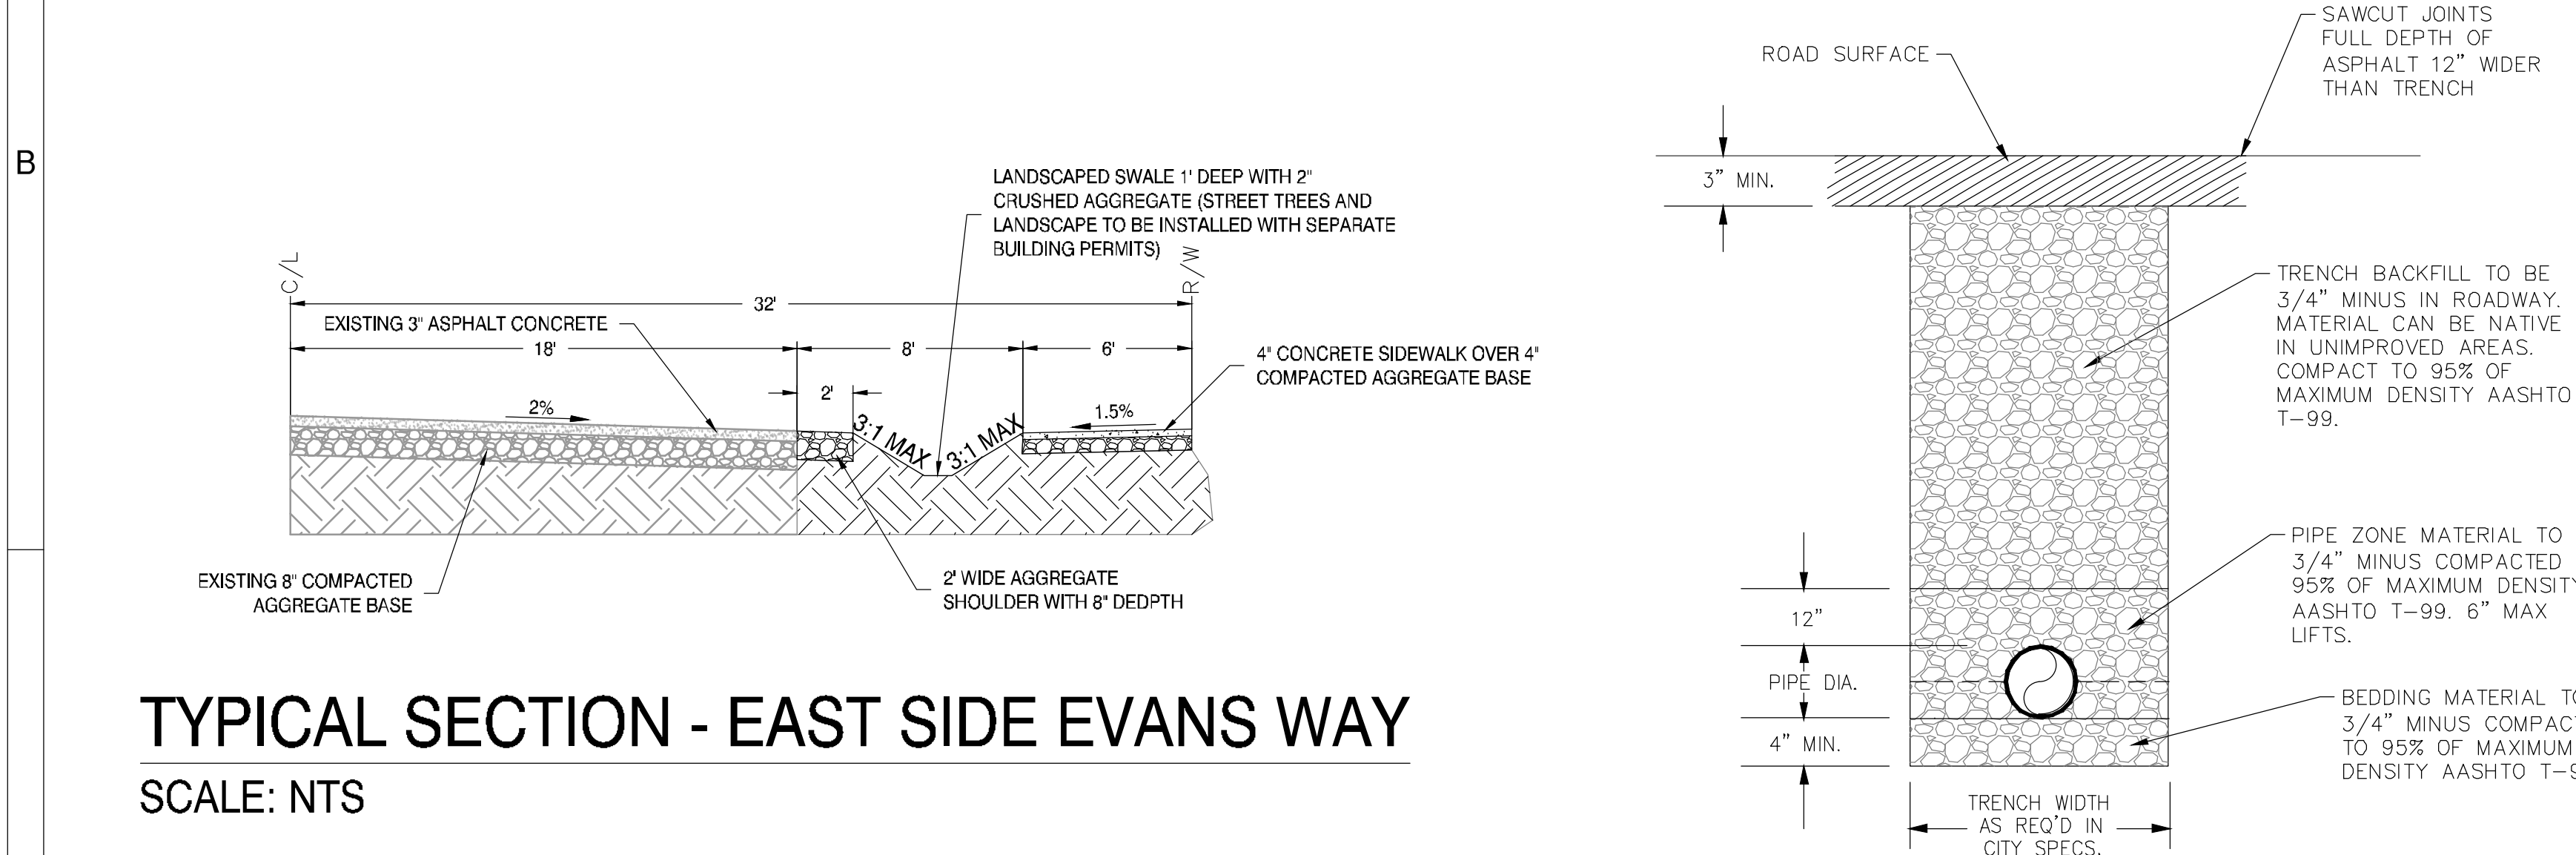


TYPICAL SECTION - EAST SIDE EVANS WAY
SCALE: NTS

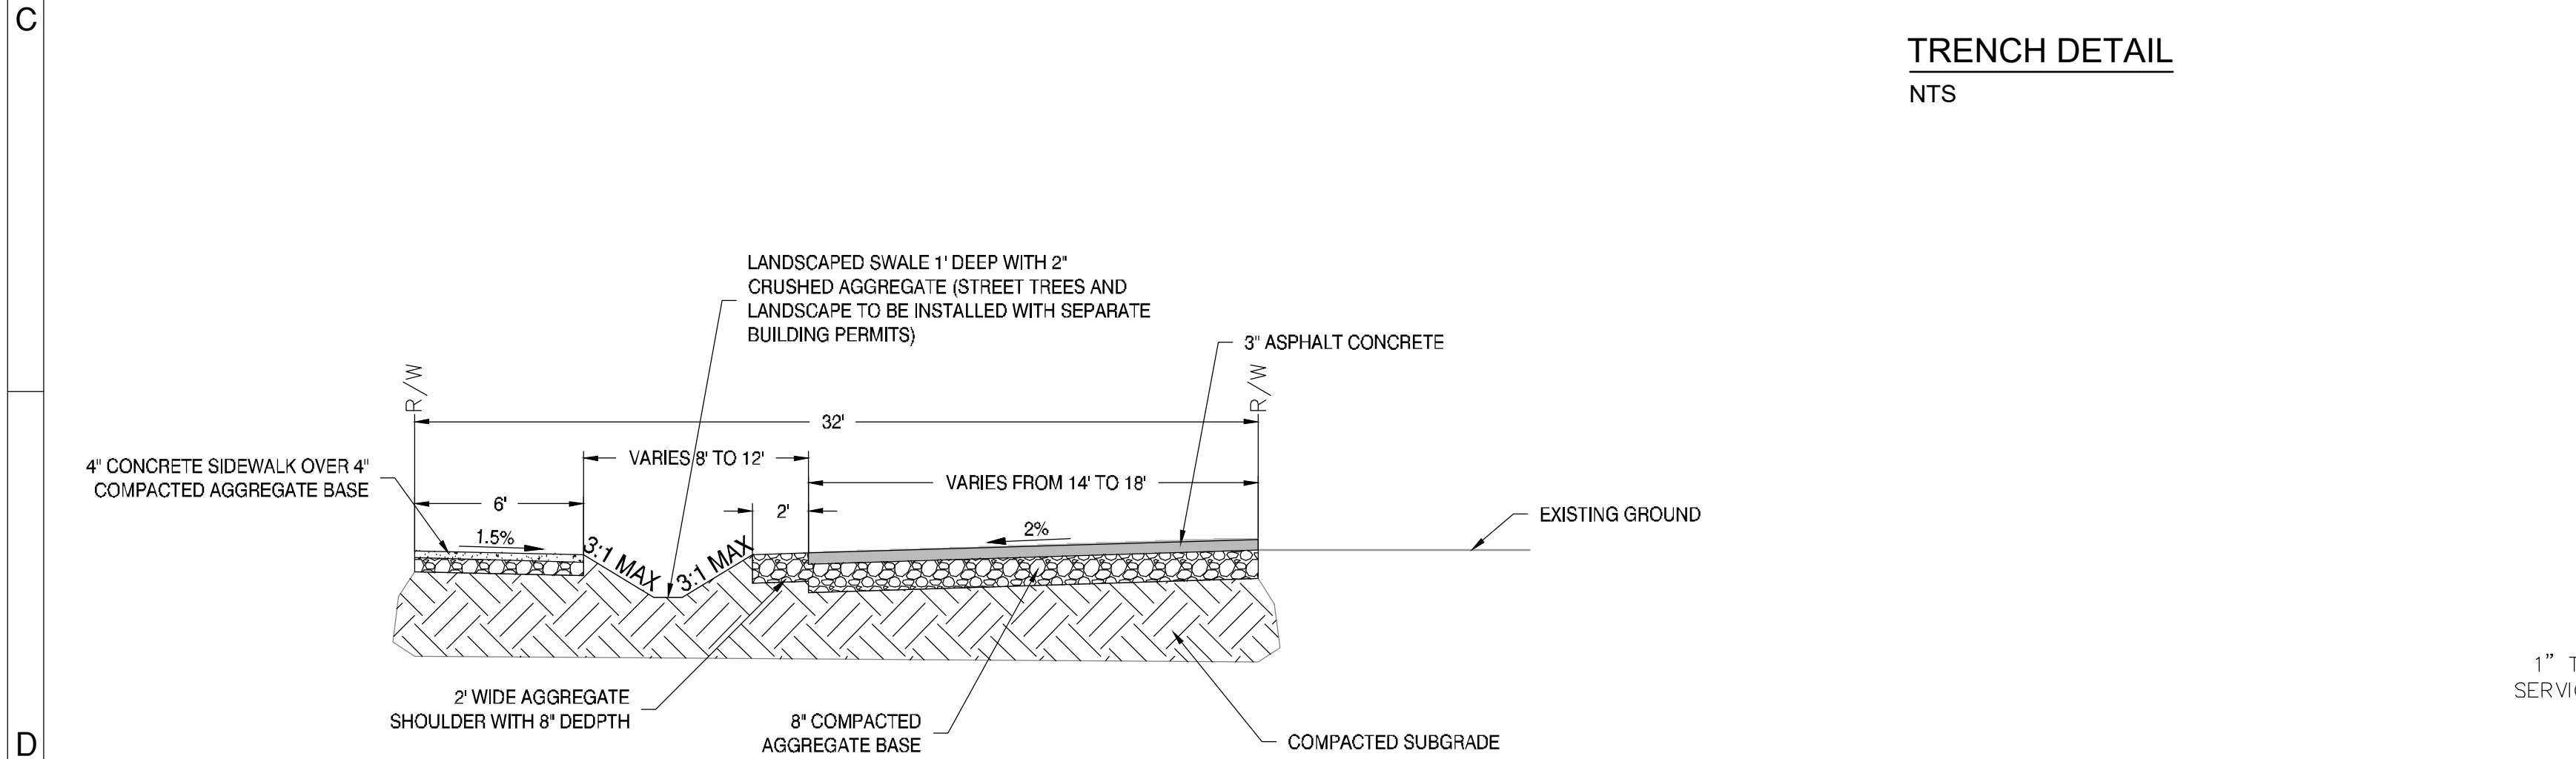


TYPICAL SECTION - WEST SIDE WALLING LANE
SCALE: NTS

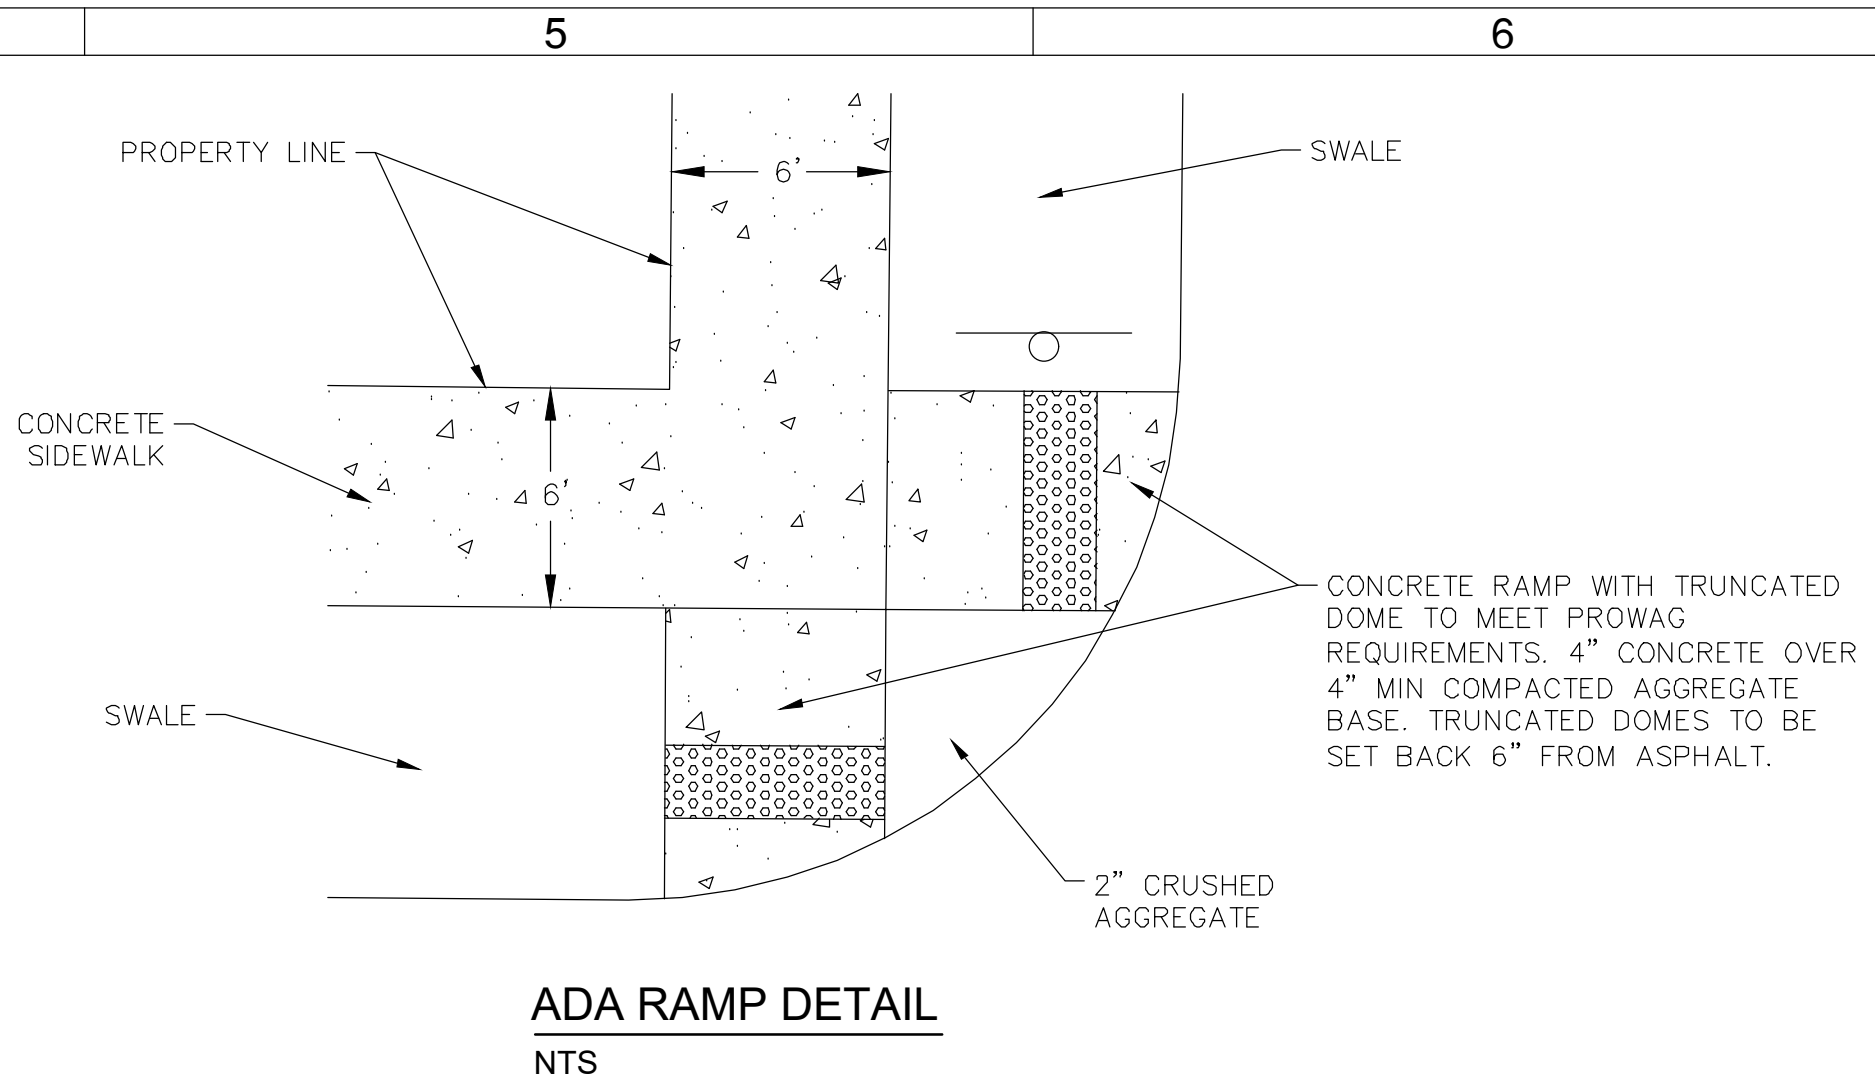

ADA RAMP DETAIL
NTS

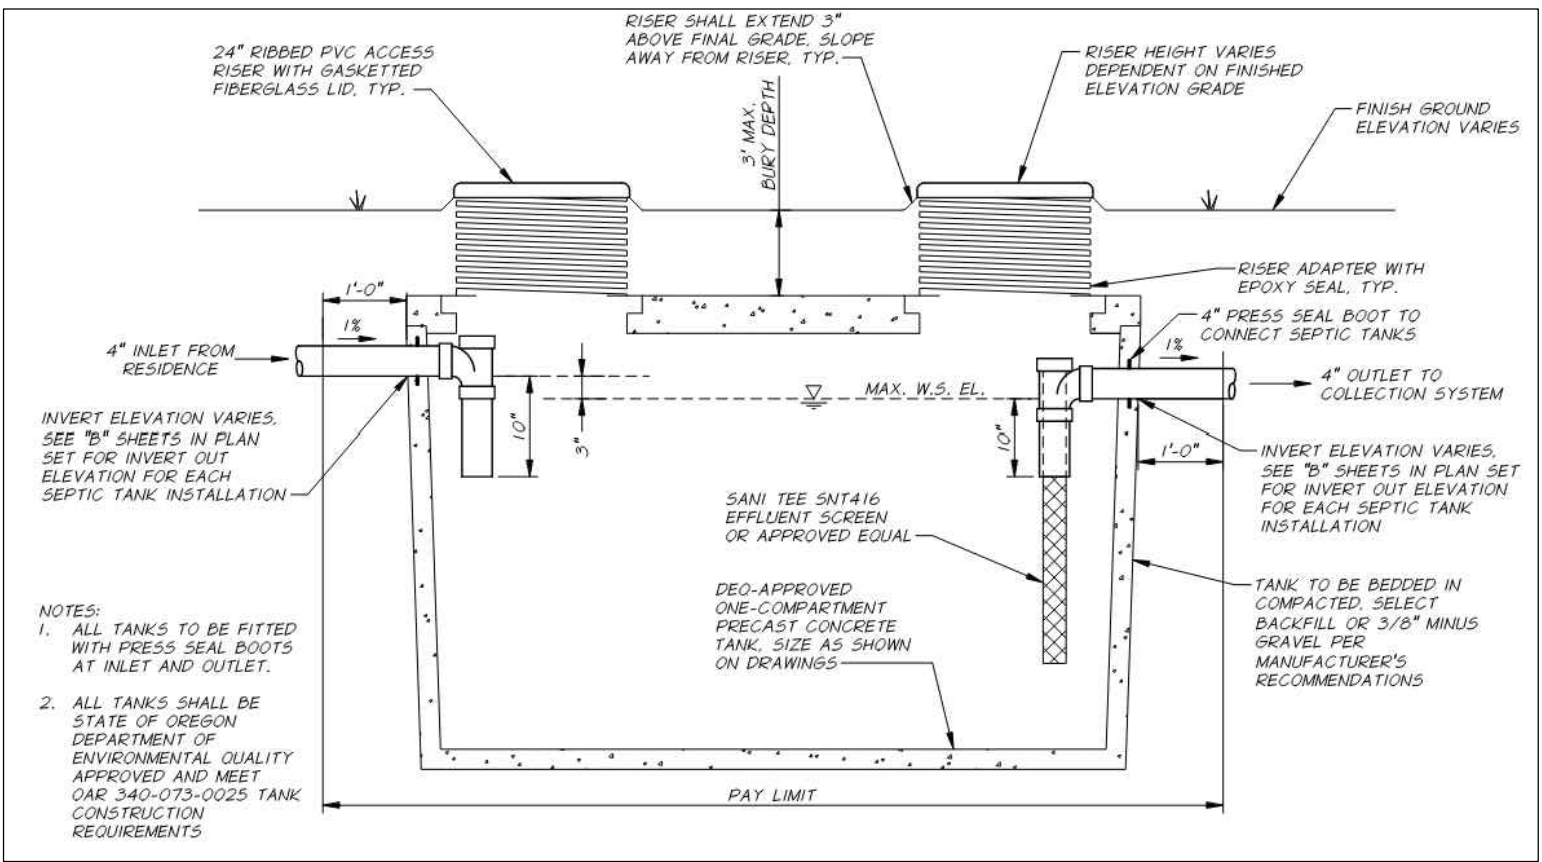

TYPICAL 1,000 GALLON TYPE A SEPTIC TANK DETAIL
NTS

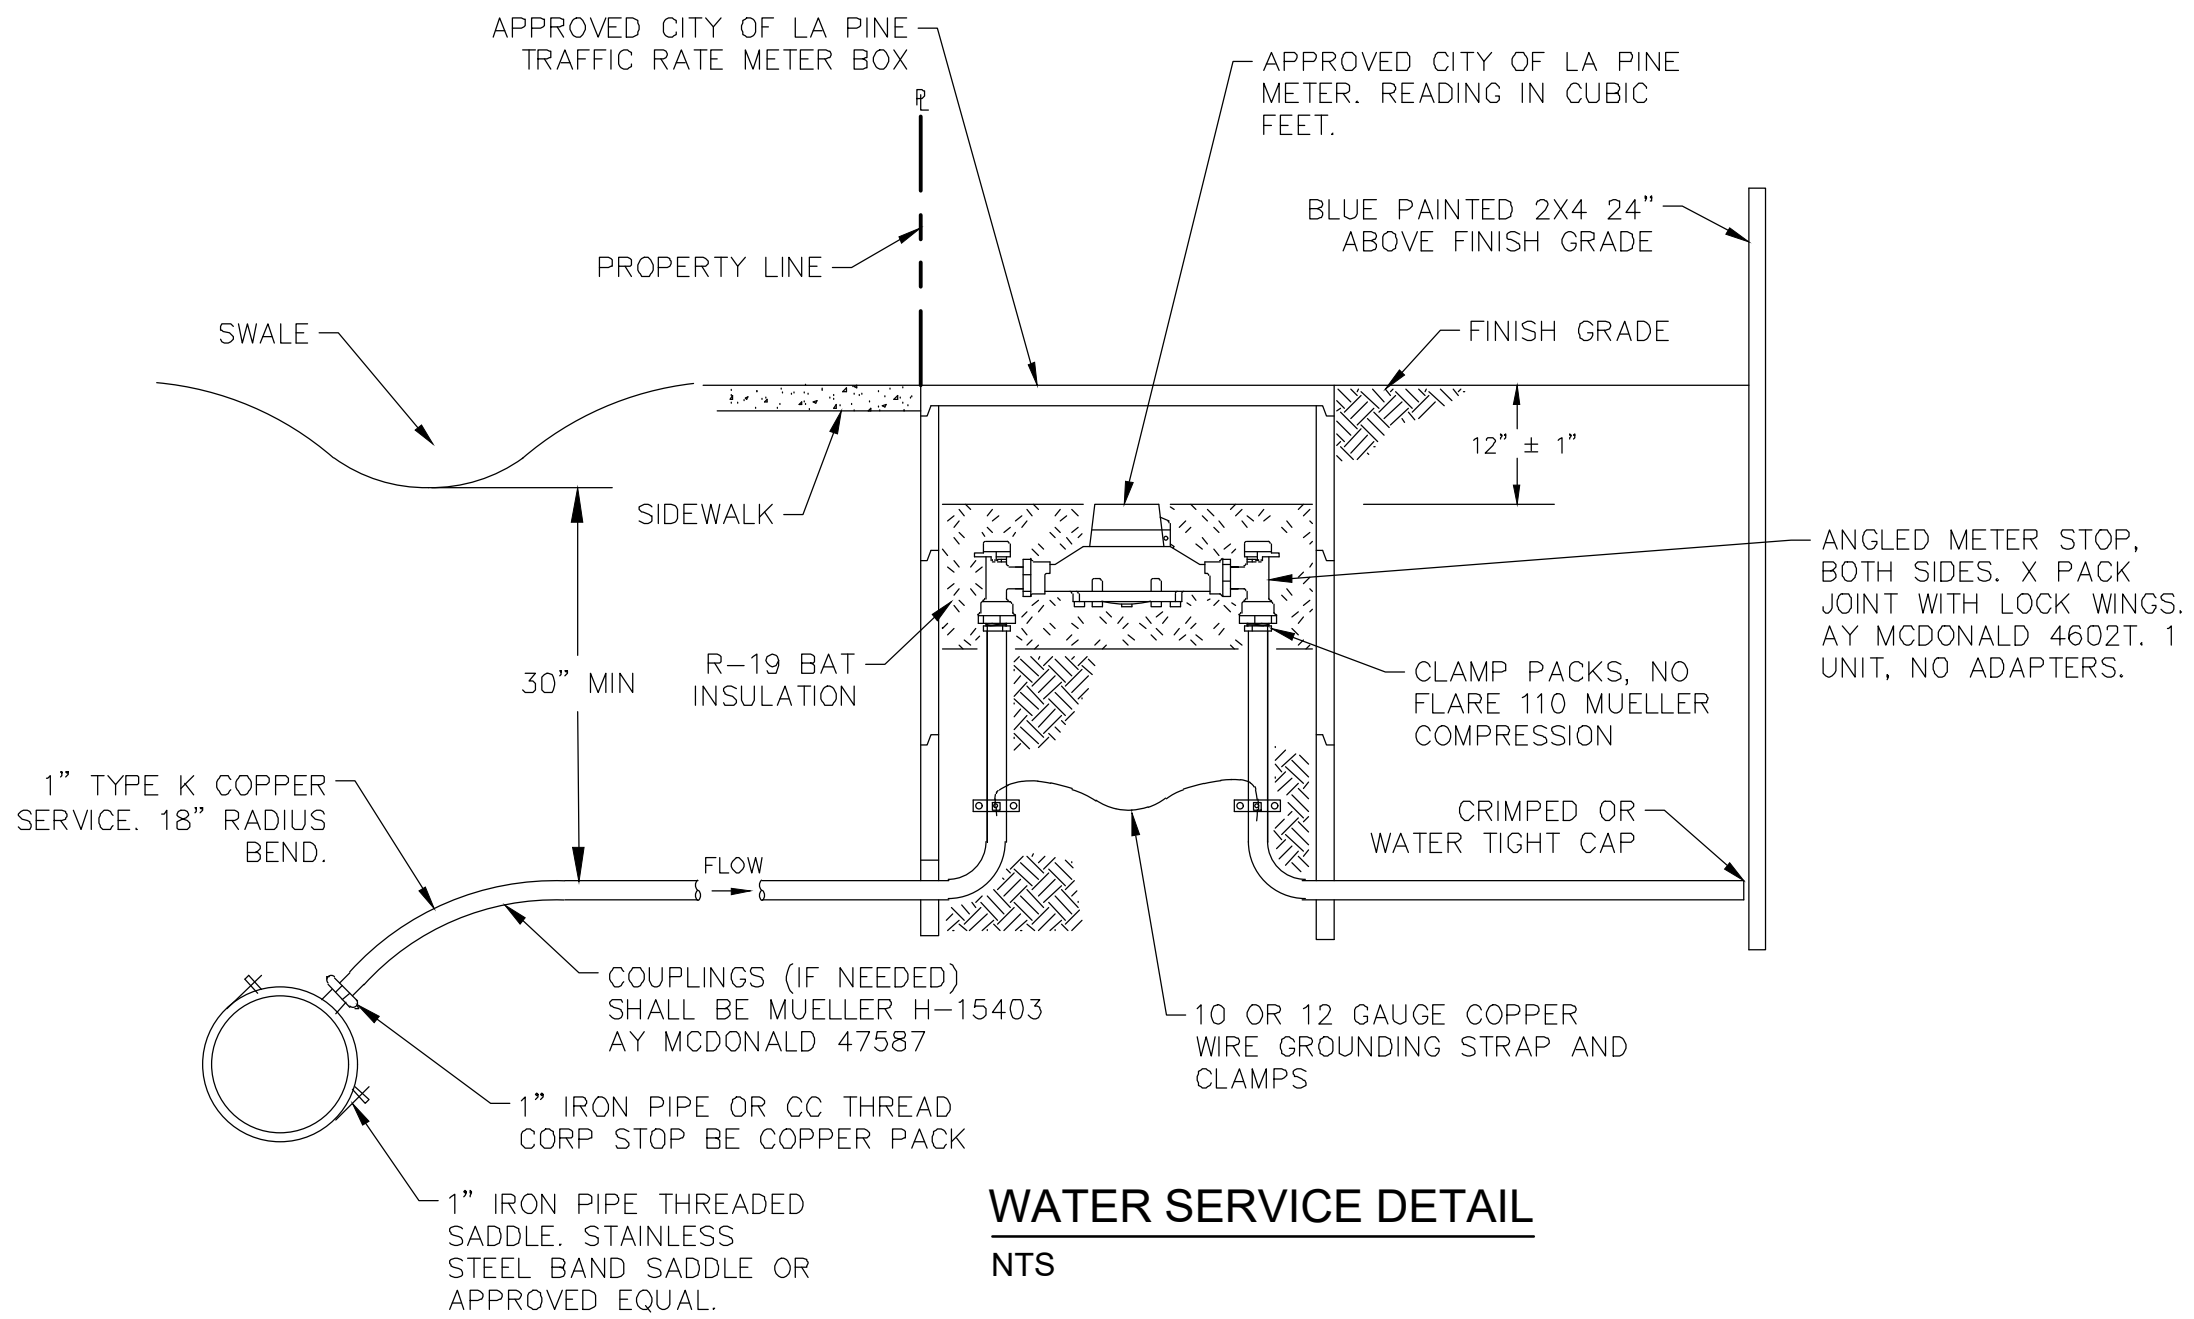

WATER SERVICE DETAIL
NTS

REGISTERED PROFESSIONAL
ENGINEER
79414
OREGON
SEPT. 12, 2017
TAYLOR RYAN MUNRO
RENEWS: DECEMBER 31, 2024

FINLEY BUTTE RANCH
RESIDENTIAL SUBDIVISION
DETAILS
CITY OF LA PINE, DESCHUTES COUNTY, OREGON

LAPINE
OREGON

REVISIONS:
1. _____
2. _____
3. _____

DESIGNED BY: TRM
DRAWN BY: SMA
SCALE: NTS
FILE: 24004
DATE: 09/10/2024

549 SW MILL VIEW WAY
SUITE 100
BEND, OREGON 97702
(541) 633-3140
www.beconeng.com

BECON
CIVIL ENGINEERING
& LAND SURVEYING

VERIFY SCALES
0 1"
BAR EQUALS ONE INCH
ON ORIGINAL DRAWING

SHEET:
C5.0

14 OF 15

PERMIT# 02SUB-24

