


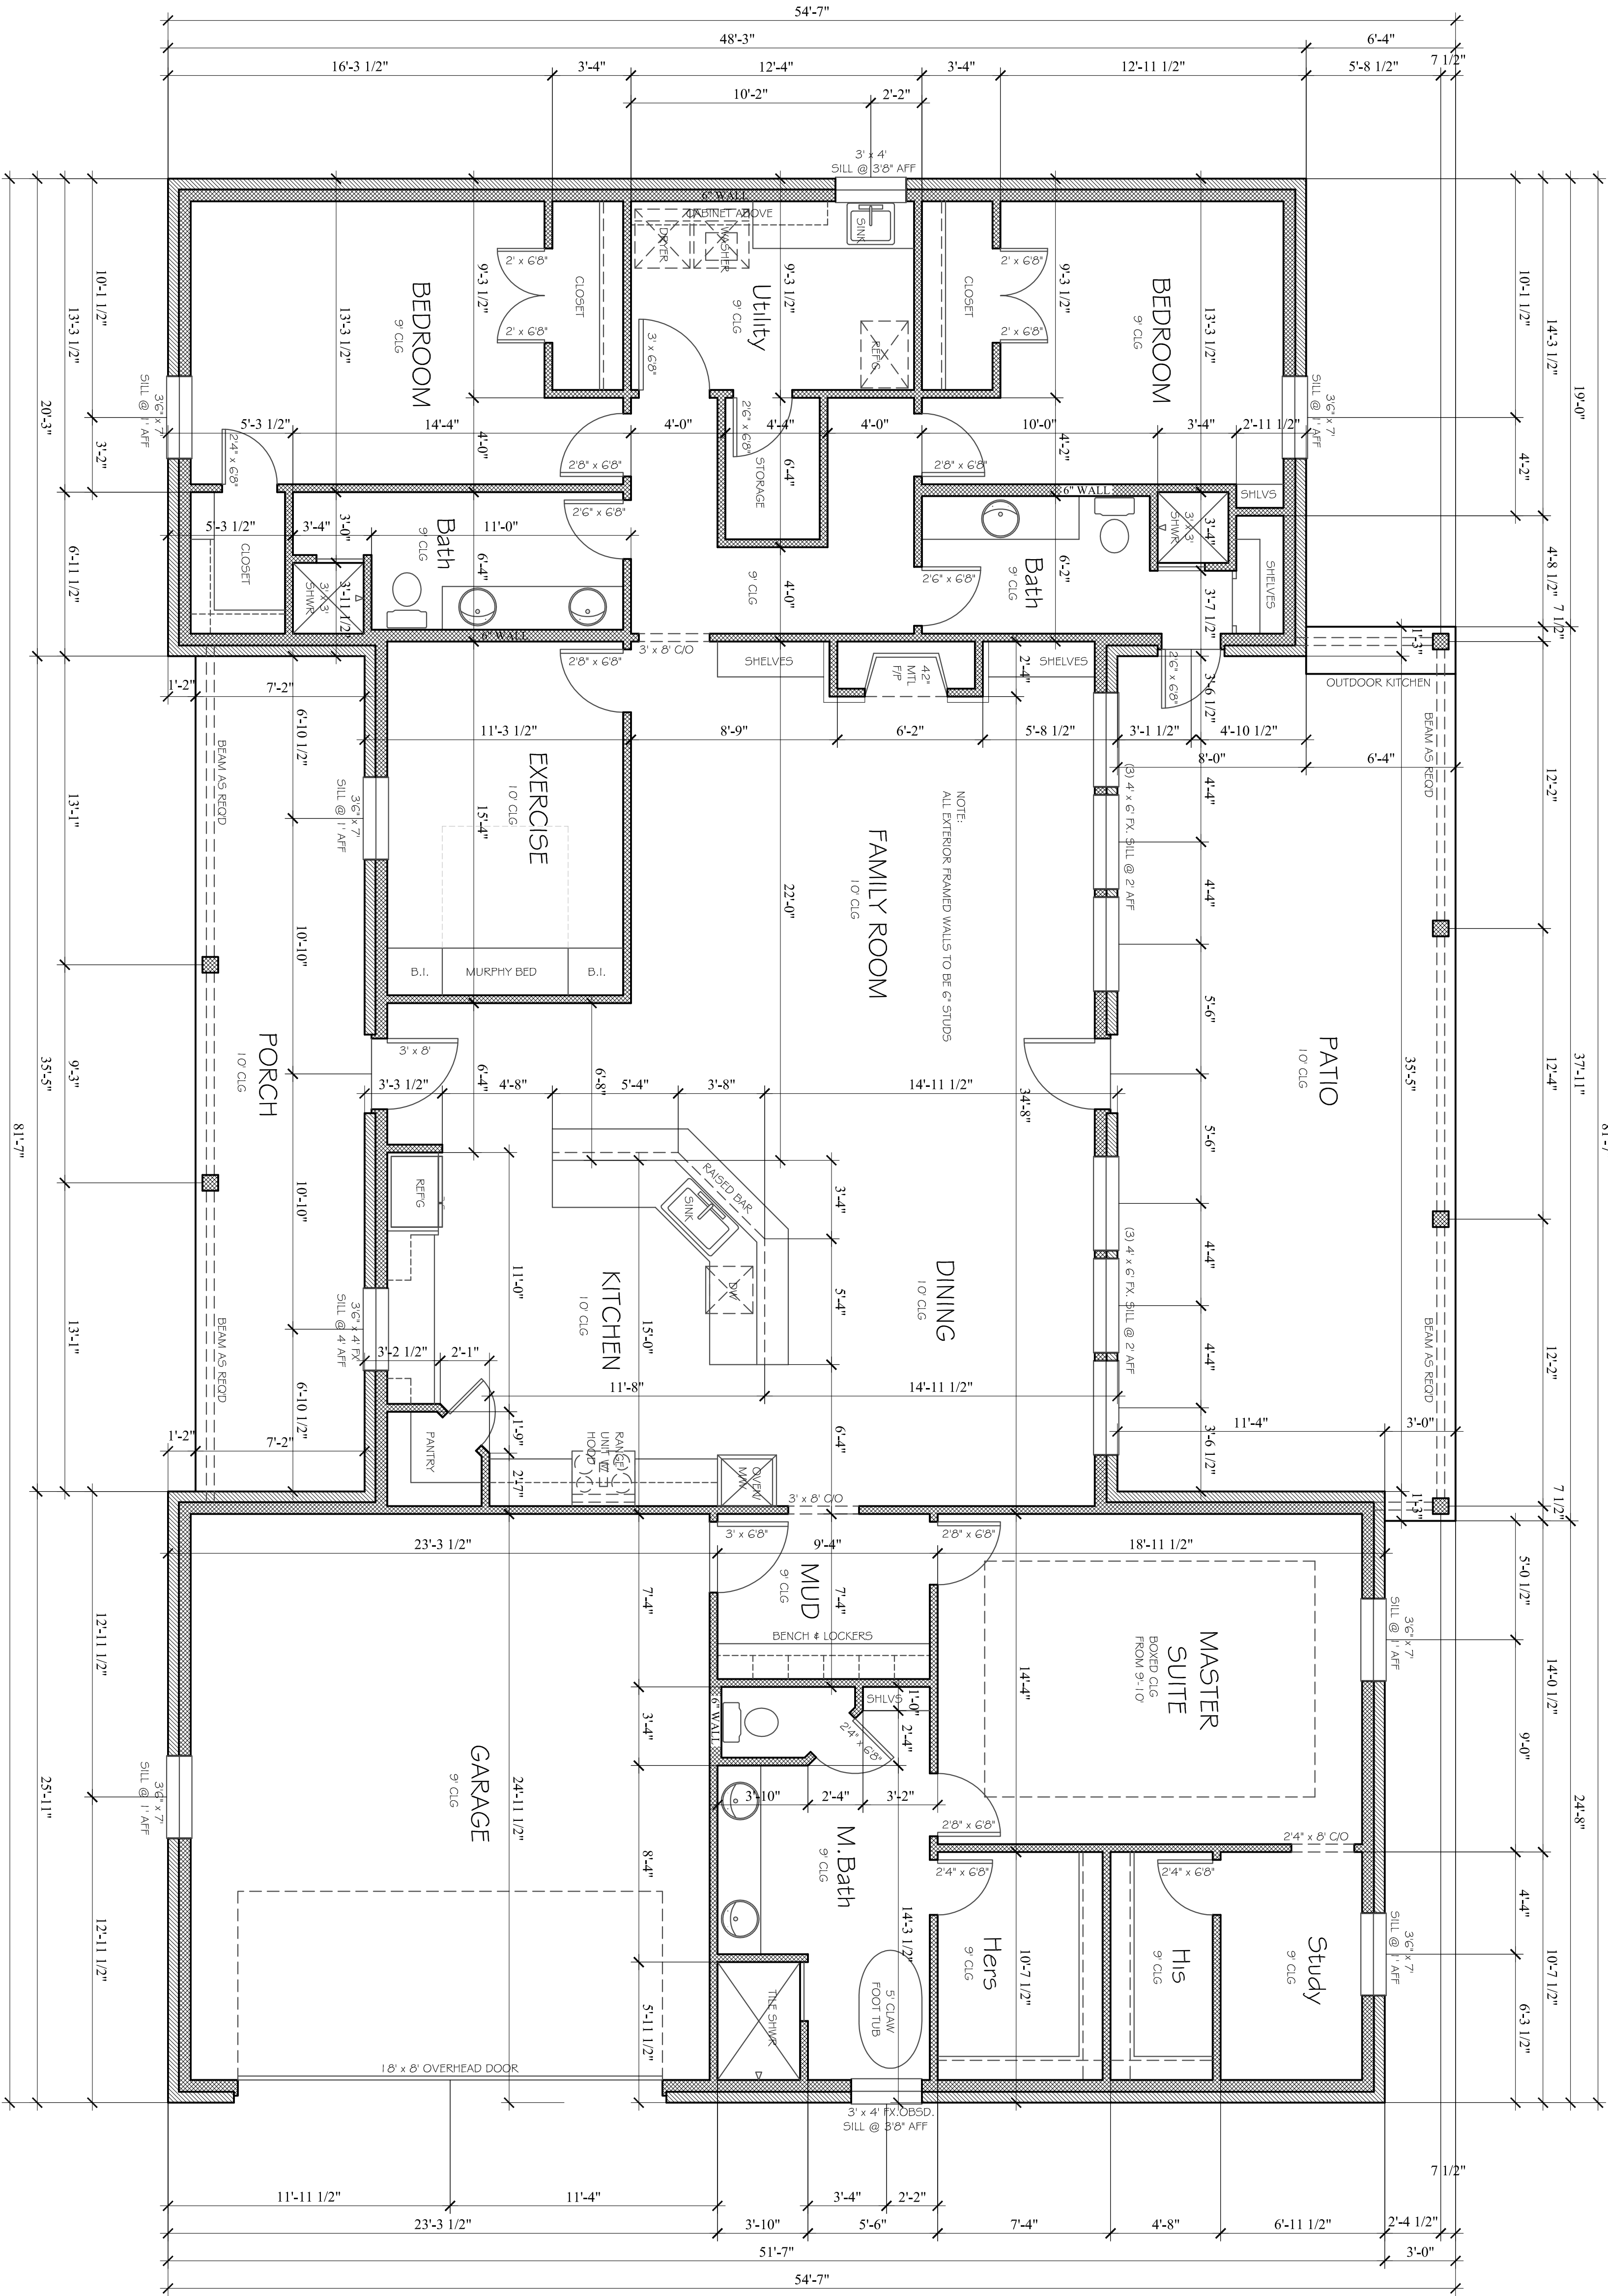

FLOOR PLAN

SCALE: 1/4"=1'-0"

AREAS		SQ.FT.
HOUSE PROPERTIES (A/C)	2863	
GARAGE	591	
PORCH	254	
PATIO AREA UNDER ROOF	519	
SCREENED PORCH	4517	
TOTAL SLAB	4517	

CUSTOM		
Drawn By	Checked By	
CN	CN	

THESE PLANS ARE INTENDED TO PROVIDE BASIC INFORMATION FOR THE HOMEOWNER AND ARE NOT TO BE USED FOR CONSTRUCTION. THESE PLANS MUST BE VERIFIED AND CHECKED BY THE CONTRACTOR AND ALL CONTRACTORS OF THIS JOB PRIOR TO CONSTRUCTION. THE CONTRACTOR SHALL BE RESPONSIBLE FOR OBTAINING ALL NECESSARY PERMITS AND ENGINEERING SERVICES NECESSARY BEFORE BEGINNING CONSTRUCTION OF ANY AND ALL FEDERAL, STATE, AND LOCAL CODES AND ORDINANCES TAKE PRECEDENCE OVER ANY OTHERS. THE HOMEOWNER SHALL BE RESPONSIBLE FOR OBTAINING ALL NECESSARY PERMITS AND ENGINEERING SERVICES NECESSARY BEFORE BEGINNING CONSTRUCTION OF ANY AND ALL FEDERAL, STATE, AND LOCAL CODES AND ORDINANCES TAKE PRECEDENCE OVER ANY OTHERS. THE HOMEOWNER SHALL BE RESPONSIBLE FOR OBTAINING ALL NECESSARY PERMITS AND ENGINEERING SERVICES NECESSARY BEFORE BEGINNING CONSTRUCTION OF ANY AND ALL FEDERAL, STATE, AND LOCAL CODES AND ORDINANCES TAKE PRECEDENCE OVER ANY OTHERS.

INCLUDED IN THIS SET OF PLANS	
SITE PLAN (IF NEEDED)	
DIMENSIONED FLOOR PLAN	
4 ELEVATIONS	
ROOF PLAN	
ELECTRICAL PLAN	
CLASS C FOUNDATION PLAN	

A Custom Residence For:

HOUSTON & JULIE TUEL

Builder:

WILL STEED HOMES

CHAD NORTON
OWNER
(817) 573-4269



C & C Custom Home Designs

Plan Name:	TUEL - 2863
Sheet No:	1 of 6